


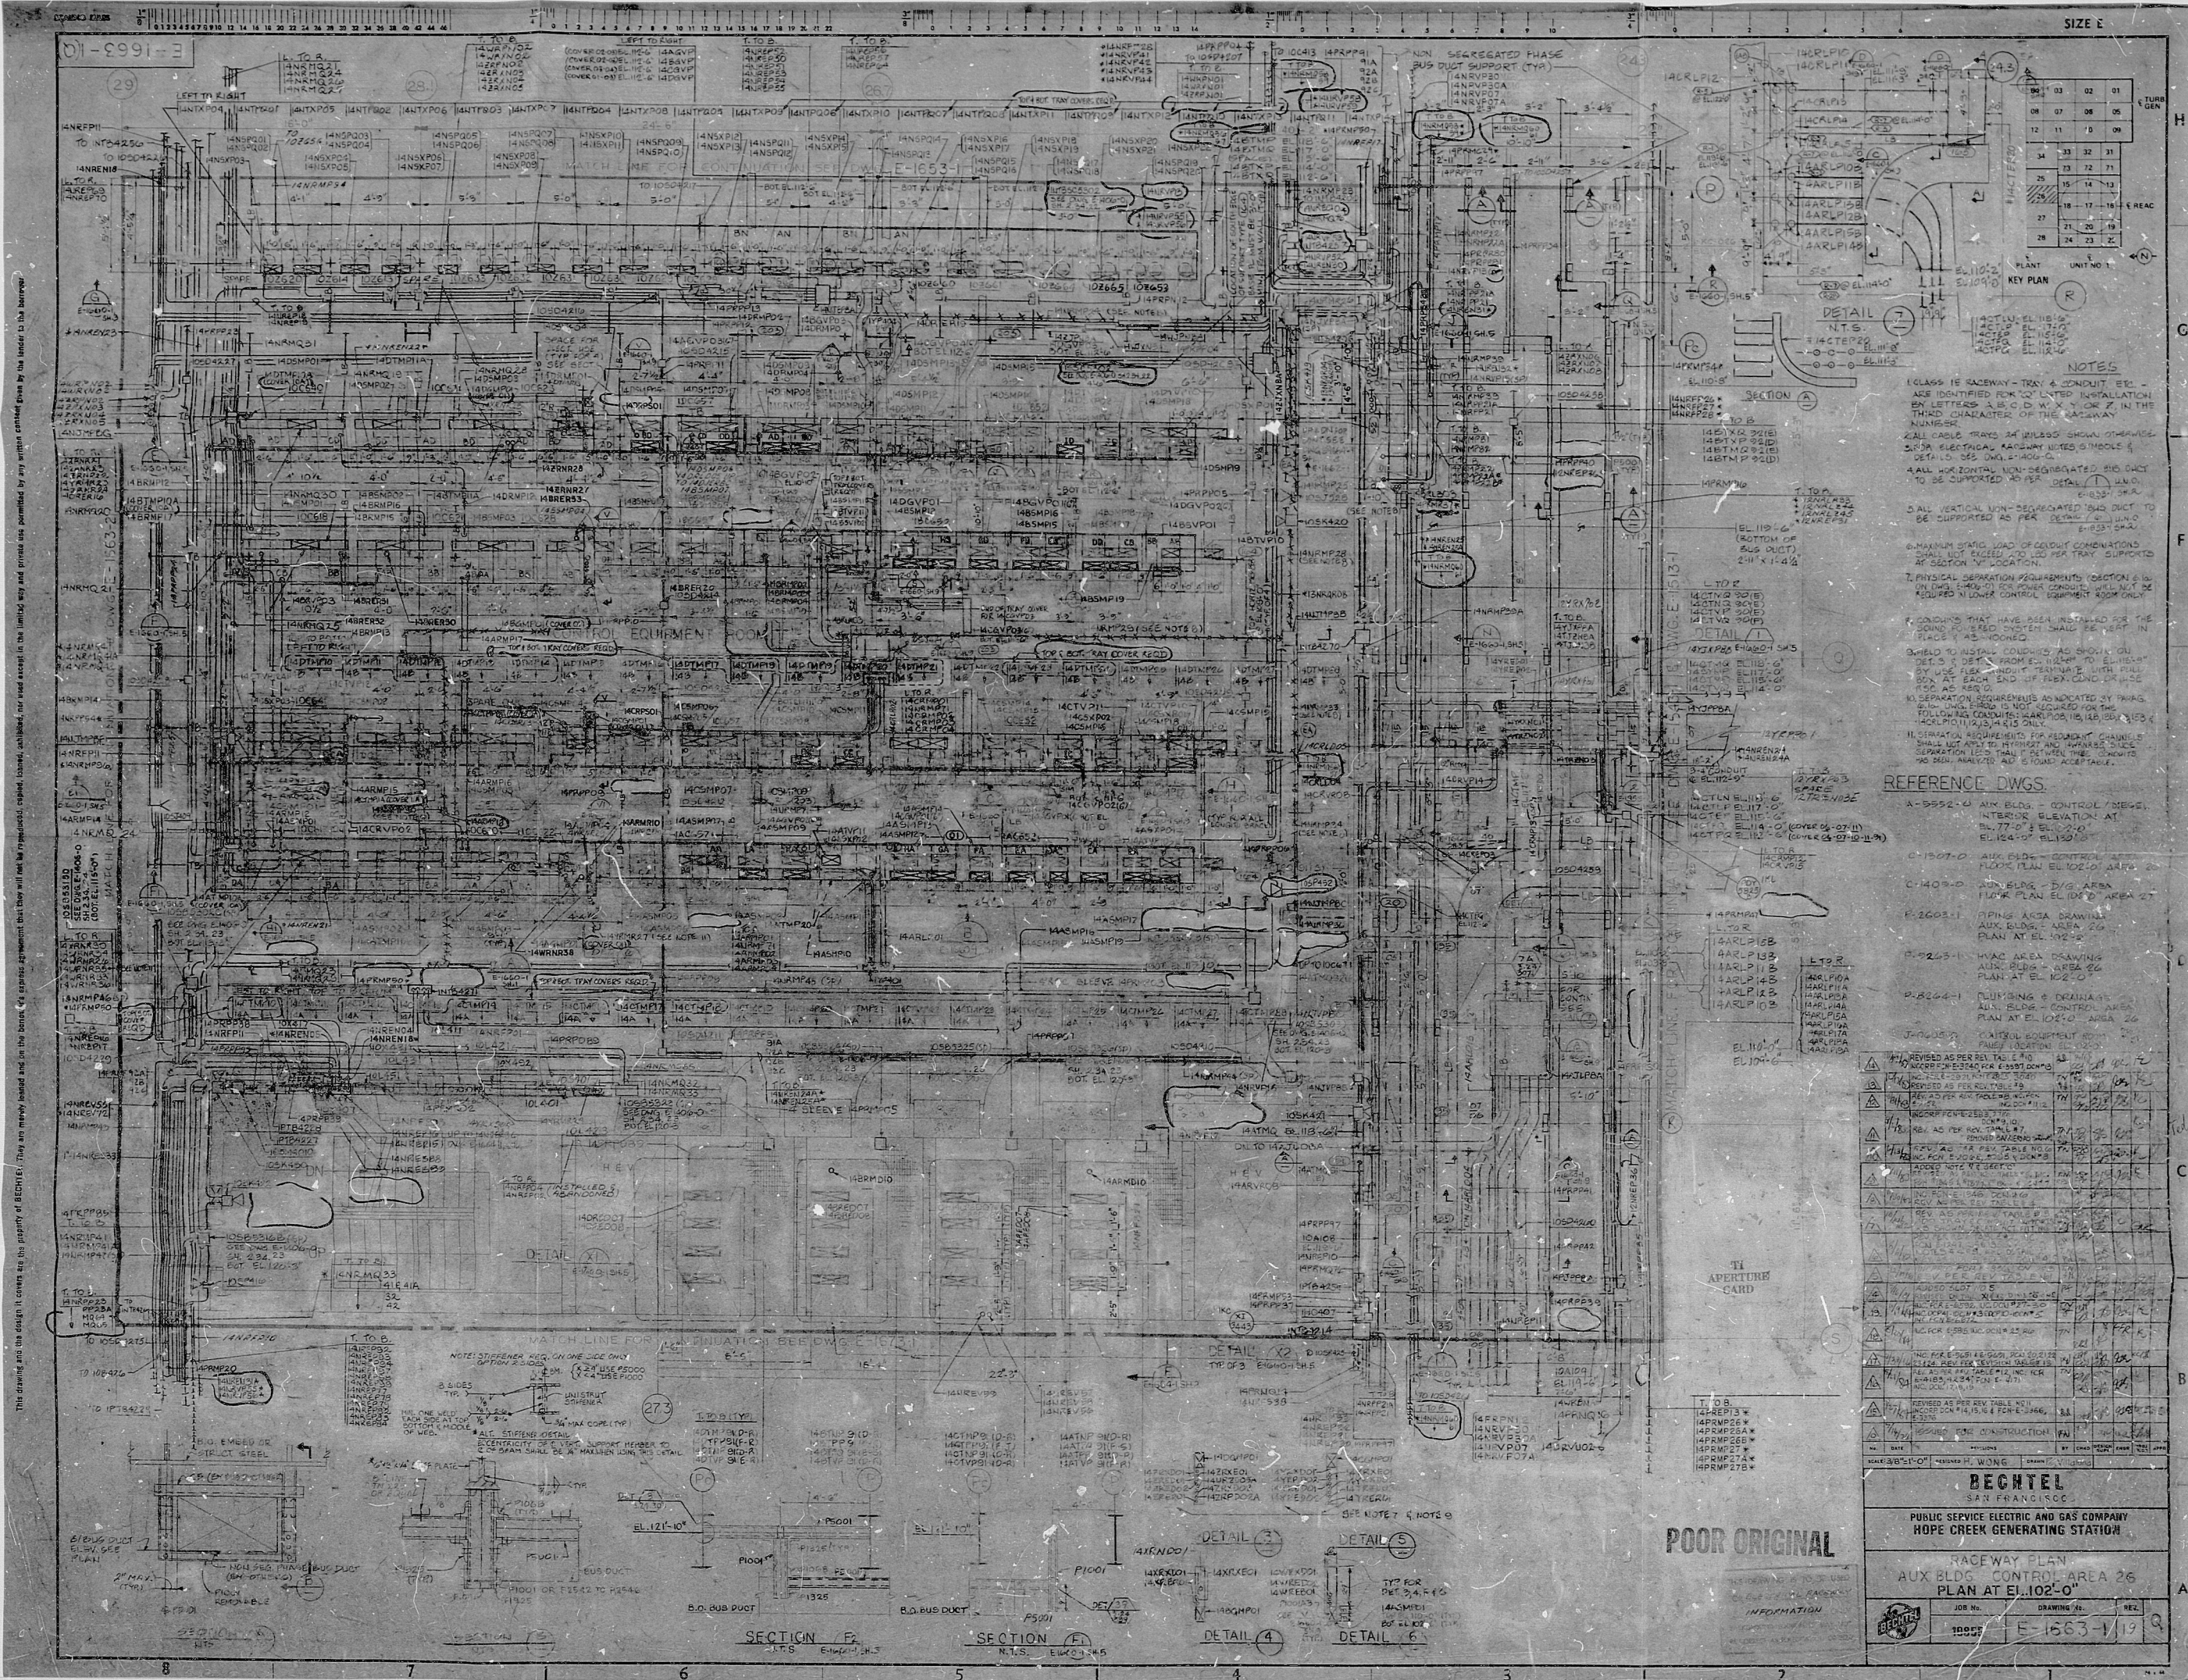

This drawing is the design of the raceway and is not to be used for construction purposes. It is the property of BECHTEL. Any use of this drawing for construction purposes without the written consent of BECHTEL is prohibited.

- NOTES**
1. CLASS 15 RACEWAY - TRAY & CONDUIT ETC. - ARE IDENTIFIED FOR LISTED INSTALLATION BY LETTERS A, B, C, D, W, X, Y, OR Z, IN THE THIRD CHARACTER OF THE RACEWAY NUMBER.
 2. ALL CABLE TRAYS ARE SHOWN WITH SPACERS. SEE ELECTRICAL RACEWAY NOTES, 0.1 MOBILE & DETAIL 0. SEE DWG. E-1663-1/19.
 3. ALL HORIZONTAL NON-SEGREGATED RACEWAY DUCT TO BE SUPPORTED AS PER DETAIL 0. SEE DWG. E-1663-1/19.
 4. MAXIMUM STATIC LOAD OF CONDUIT COMBINATIONS SHALL NOT EXCEED 200 LBS. PER TRAY SUPPORTED AT SECTION "A" LOCATION.
 5. PHYSICAL SEPARATION REQUIREMENTS (SECTION 0.6) IN THIS RACEWAY SHALL BE MAINTAINED. RACEWAY SHALL BE REQUIRED IN LOWER CONTROL EQUIPMENT ROOM ONLY.
 6. CONDUITS THAT HAVE BEEN INSTALLED FOR THE RACEWAY SHALL BE IDENTIFIED BY LETTERS A, B, C, D, W, X, Y, OR Z, IN THE THIRD CHARACTER OF THE RACEWAY NUMBER.
 7. SEPARATION REQUIREMENTS ASSOCIATED WITH THIS RACEWAY SHALL BE MAINTAINED. RACEWAY SHALL BE REQUIRED IN LOWER CONTROL EQUIPMENT ROOM ONLY.
 8. SEPARATION REQUIREMENTS ASSOCIATED WITH THIS RACEWAY SHALL BE MAINTAINED. RACEWAY SHALL BE REQUIRED IN LOWER CONTROL EQUIPMENT ROOM ONLY.

REFERENCE DWGS.

NO.	DESCRIPTION
A-5552-0	ARM BLDG - CONTROL / DIESEL INTERIOR ELEVATION AT EL. 77'-0" TO 102'-0" EL. 102'-0" EL. 102'-0"
C-1507-0	AUX BLDG - CONTROL AREA FLOOR PLAN EL. 102'-0" AREA 26
C-1408-0	AUX BLDG - D/G AREA FLOOR PLAN EL. 102'-0" AREA 27
F-2603-1	PIPEING AREA DRAWING AUX. BLDG. AREA 26 PLAN AT EL. 102'-0"
F-2625-1	HAZ. AREA DRAWING AUX. BLDG. AREA 26 PLAN AT EL. 102'-0"
F-2626-1	PIPEING & DRAINAGE AUX. BLDG. CONTROL AREA PLAN AT EL. 102'-0" AREA 26
J-7610-0	CONTROL EQUIPMENT ROOM FLOOR PLAN EL. 102'-0"

REVISIONS

NO.	DESCRIPTION	DATE	BY	CHKD.
1	REVISED AS PER REV. TABLE 0.1	1/19/63	WONG	WONG
2	REVISED AS PER REV. TABLE 0.1	1/19/63	WONG	WONG
3	REVISED AS PER REV. TABLE 0.1	1/19/63	WONG	WONG
4	REVISED AS PER REV. TABLE 0.1	1/19/63	WONG	WONG
5	REVISED AS PER REV. TABLE 0.1	1/19/63	WONG	WONG
6	REVISED AS PER REV. TABLE 0.1	1/19/63	WONG	WONG
7	REVISED AS PER REV. TABLE 0.1	1/19/63	WONG	WONG
8	REVISED AS PER REV. TABLE 0.1	1/19/63	WONG	WONG
9	REVISED AS PER REV. TABLE 0.1	1/19/63	WONG	WONG
10	REVISED AS PER REV. TABLE 0.1	1/19/63	WONG	WONG

BECHTEL
SAN FRANCISCO
PUBLIC SERVICE ELECTRIC AND GAS COMPANY
HOPE CREEK GENERATING STATION

RACEWAY PLAN
AUX BLDG CONTROL AREA 26
PLAN AT EL. 102'-0"

JOB NO. 10000
DRAWING NO. E-1663-1/19
DATE 1/19/63

POOR ORIGINAL

PDR RIDS

8503060198

