
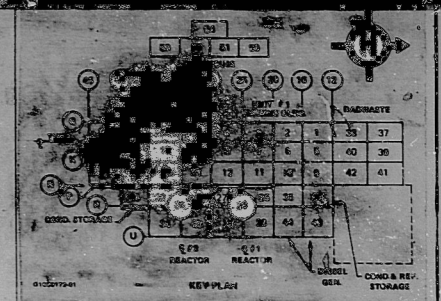


This drawing and the design it covers are the property of BECHTEL. They are hereby loaned and the borrower's express agreement that they will not be reproduced, copied, loaned, exhibited, or used except in the manner and for the purposes intended by the issuer to the borrower.

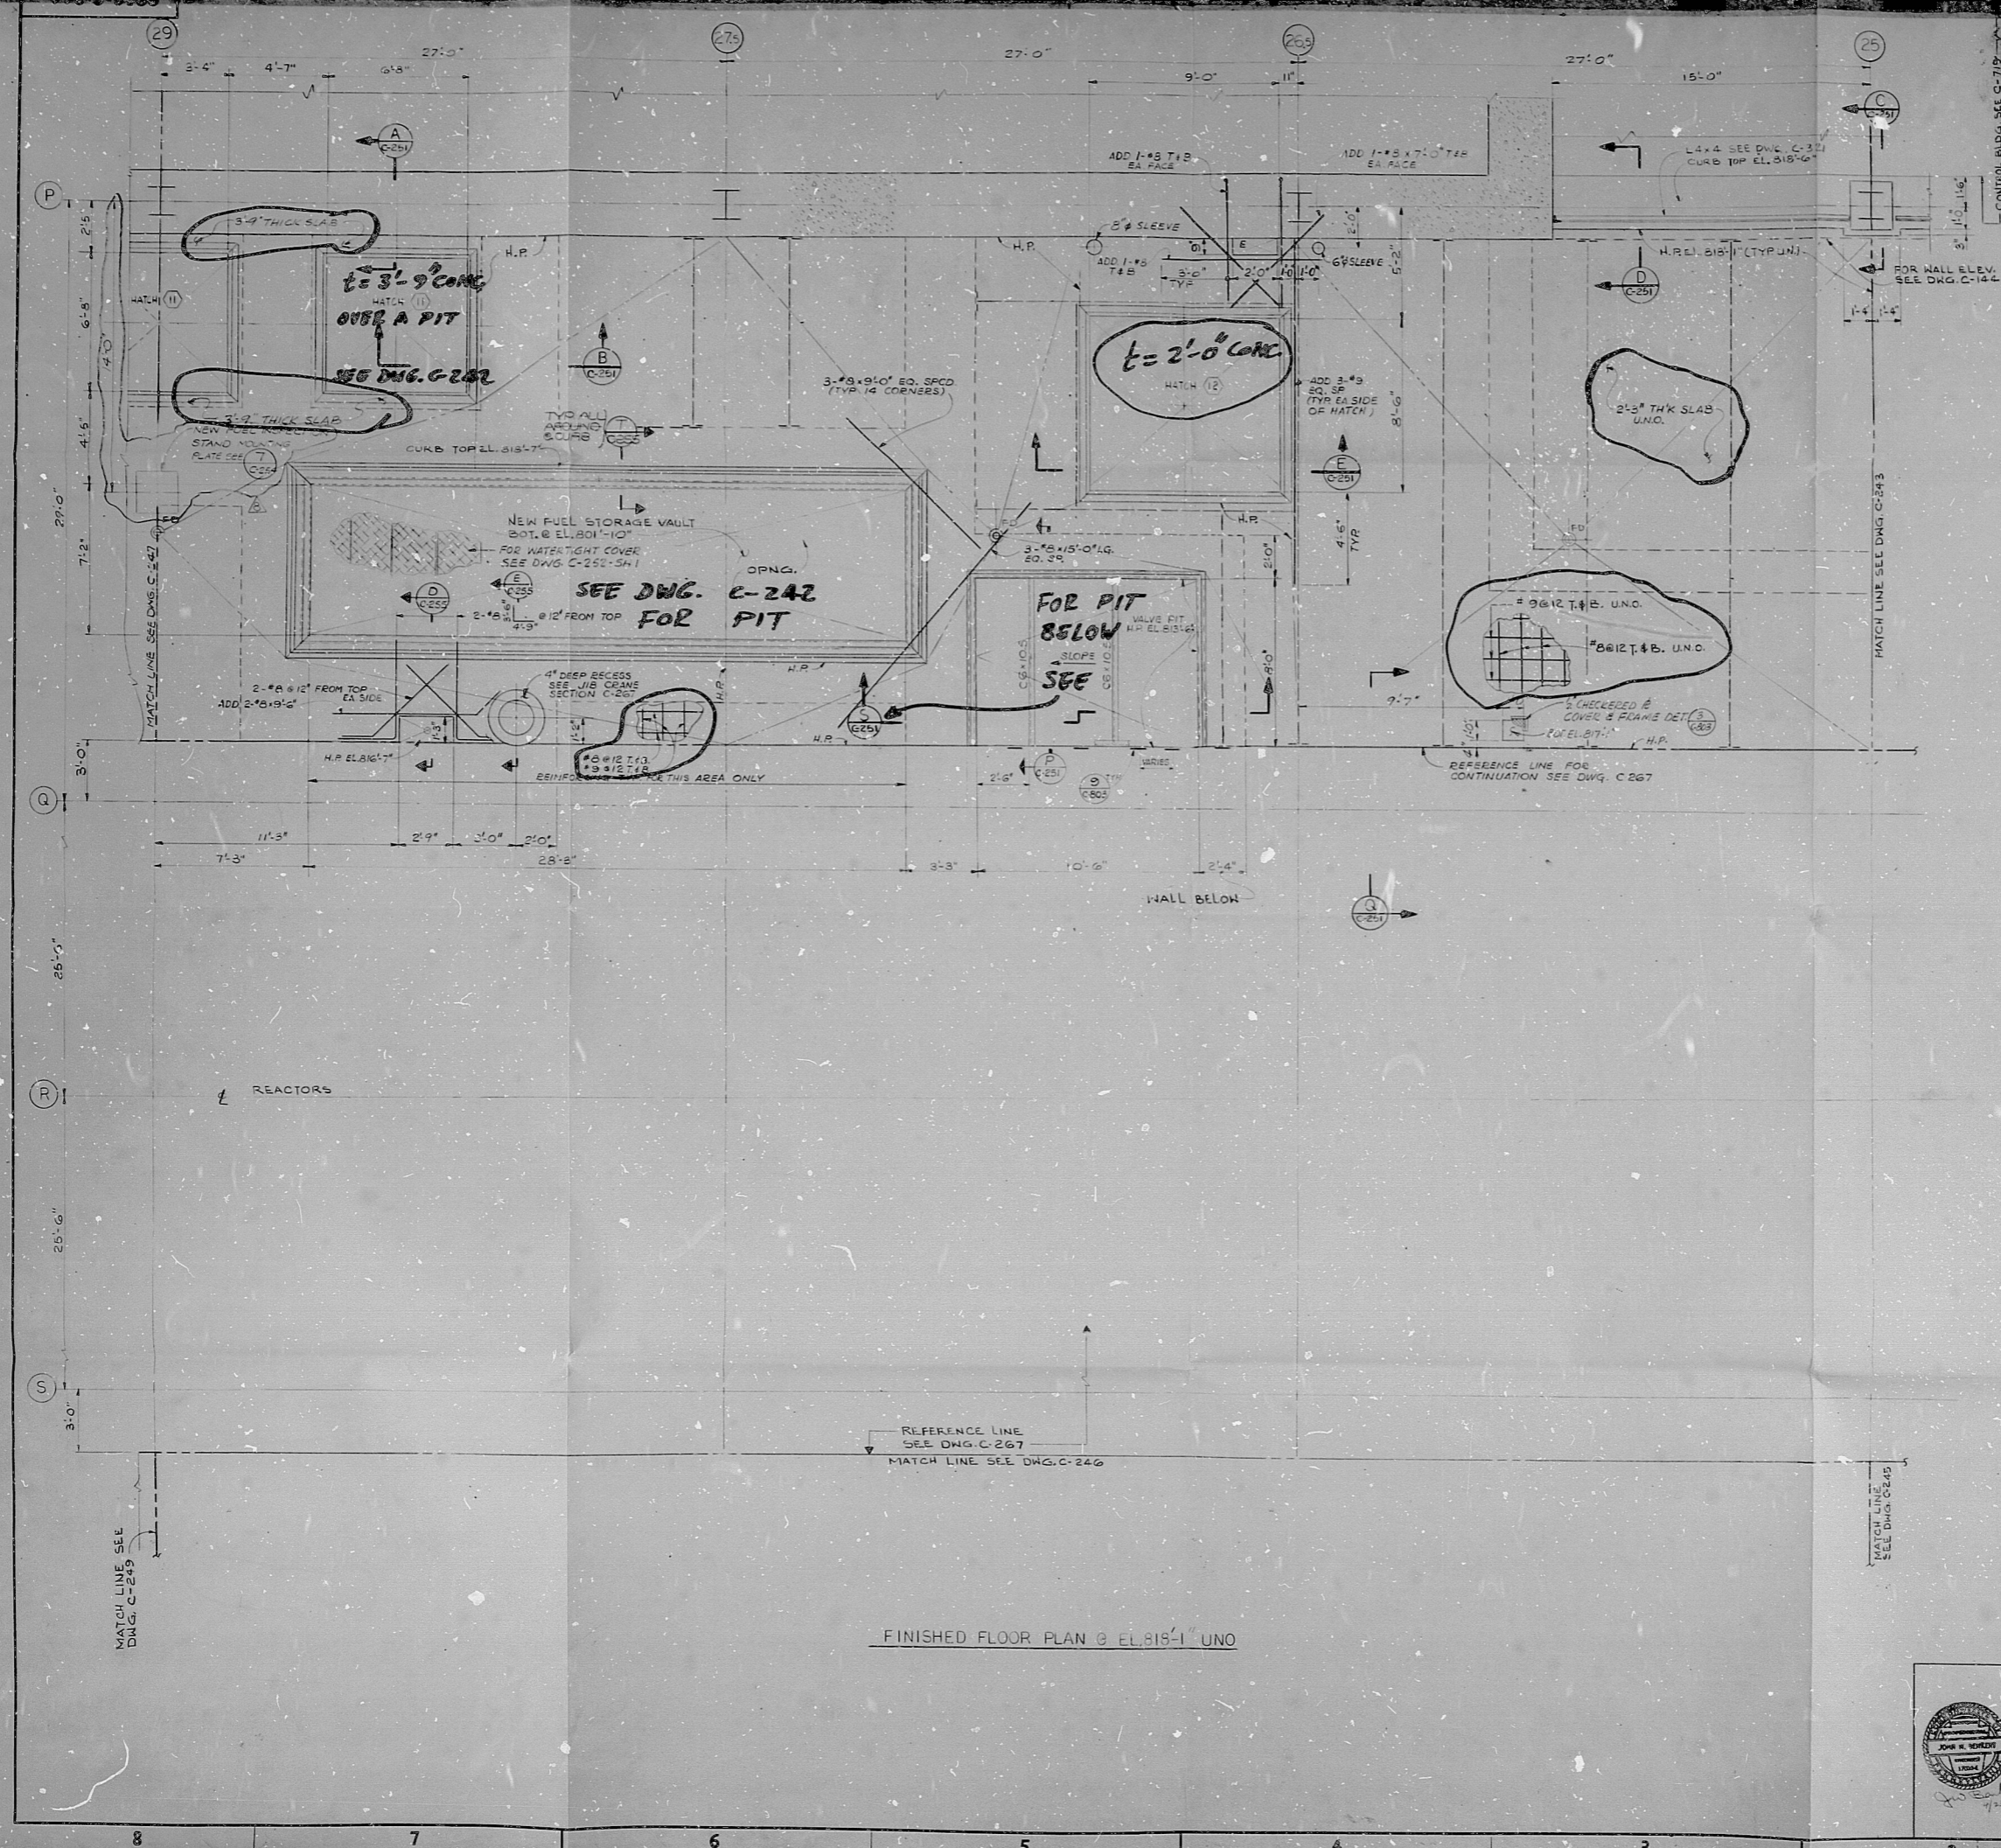

NOTES

1. FOR GENERAL NOTES, NOTES AND REFERENCE DRAWINGS SEE DWG. C-243
2. CONCRETE SHALL BE 4,000 PSI (FC) UNO.
3. ALLOWABLE FLOOR LIVE LOAD = 950 P.S.F.
4. FOR ADDITIONAL PENETRATIONS SEE PLANT DESIGN X-SERIES DWG. WHERE CONFLICT EXISTS X-DRAWINGS SHALL GOVERN.

REFERENCE DWG'S.		REFERENCE DWG'S.	
BECHTEL NO.	PL. NO.	BECHTEL NO.	PL. NO.
C-144	E-105213 SH1	C-258	E-105276
C-230	E-105260 SH1	C-267	E-105284
C-243	E-105266	C-719	E-105527 SH1
C-245	E-105268	C-261	E-105274 SH1
C-246	E-105269	C-252	E-105274 SH2
C-247	E-105270	C-255	E-105274 SH3
C-249	E-105272	C-1099	E-105256
C-251	E-105274 SH1	C-803	E-105277 SH1
C-254	E-105274		

TERRA APERTUR CARD

NO.	DATE	REVISIONS	BY	CHECKED	APPROVED
1	7/20/70	ISSUED FOR CLIENT REVIEW	J. KOZLEE		
2	7/21/70	ISSUED FOR FABRICATION	J. KOZLEE		
3	7/22/70	ISSUED FOR CONSTRUCTION	J. KOZLEE		
4	7/23/70	ISSUED FOR CONSTRUCTION	J. KOZLEE		
5	7/24/70	ISSUED FOR CONSTRUCTION	J. KOZLEE		
6	7/25/70	ISSUED FOR CONSTRUCTION	J. KOZLEE		
7	7/26/70	ISSUED FOR CONSTRUCTION	J. KOZLEE		
8	7/27/70	ISSUED FOR CONSTRUCTION	J. KOZLEE		
9	7/28/70	ISSUED FOR CONSTRUCTION	J. KOZLEE		
10	7/29/70	ISSUED FOR CONSTRUCTION	J. KOZLEE		

SCALE 3/8" = 1'-0"

DESIGNED BY J. KOZLEE

DRAWN BY J. KOZLEE

PENNSYLVANIA POWER & LIGHT COMPANY

ALLENTOWN, PENNSYLVANIA

SUSQUEHANNA STEAM ELECTRIC STATION - UNIT 1, UNIT 2

BECHTEL - SAN FRANCISCO

REACTOR BUILDING UNIT 1

FLOOR PLAN


ELEVATION 818'-1" AREA 27

JOB NO.	DRAWING NO.	REV.
8856	C-244	3

801216067

501216067

FINISHED FLOOR PLAN @ EL. 818'-1" UNO

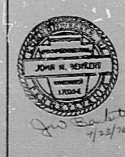

801216067

REDS-PDR

8012160067

