


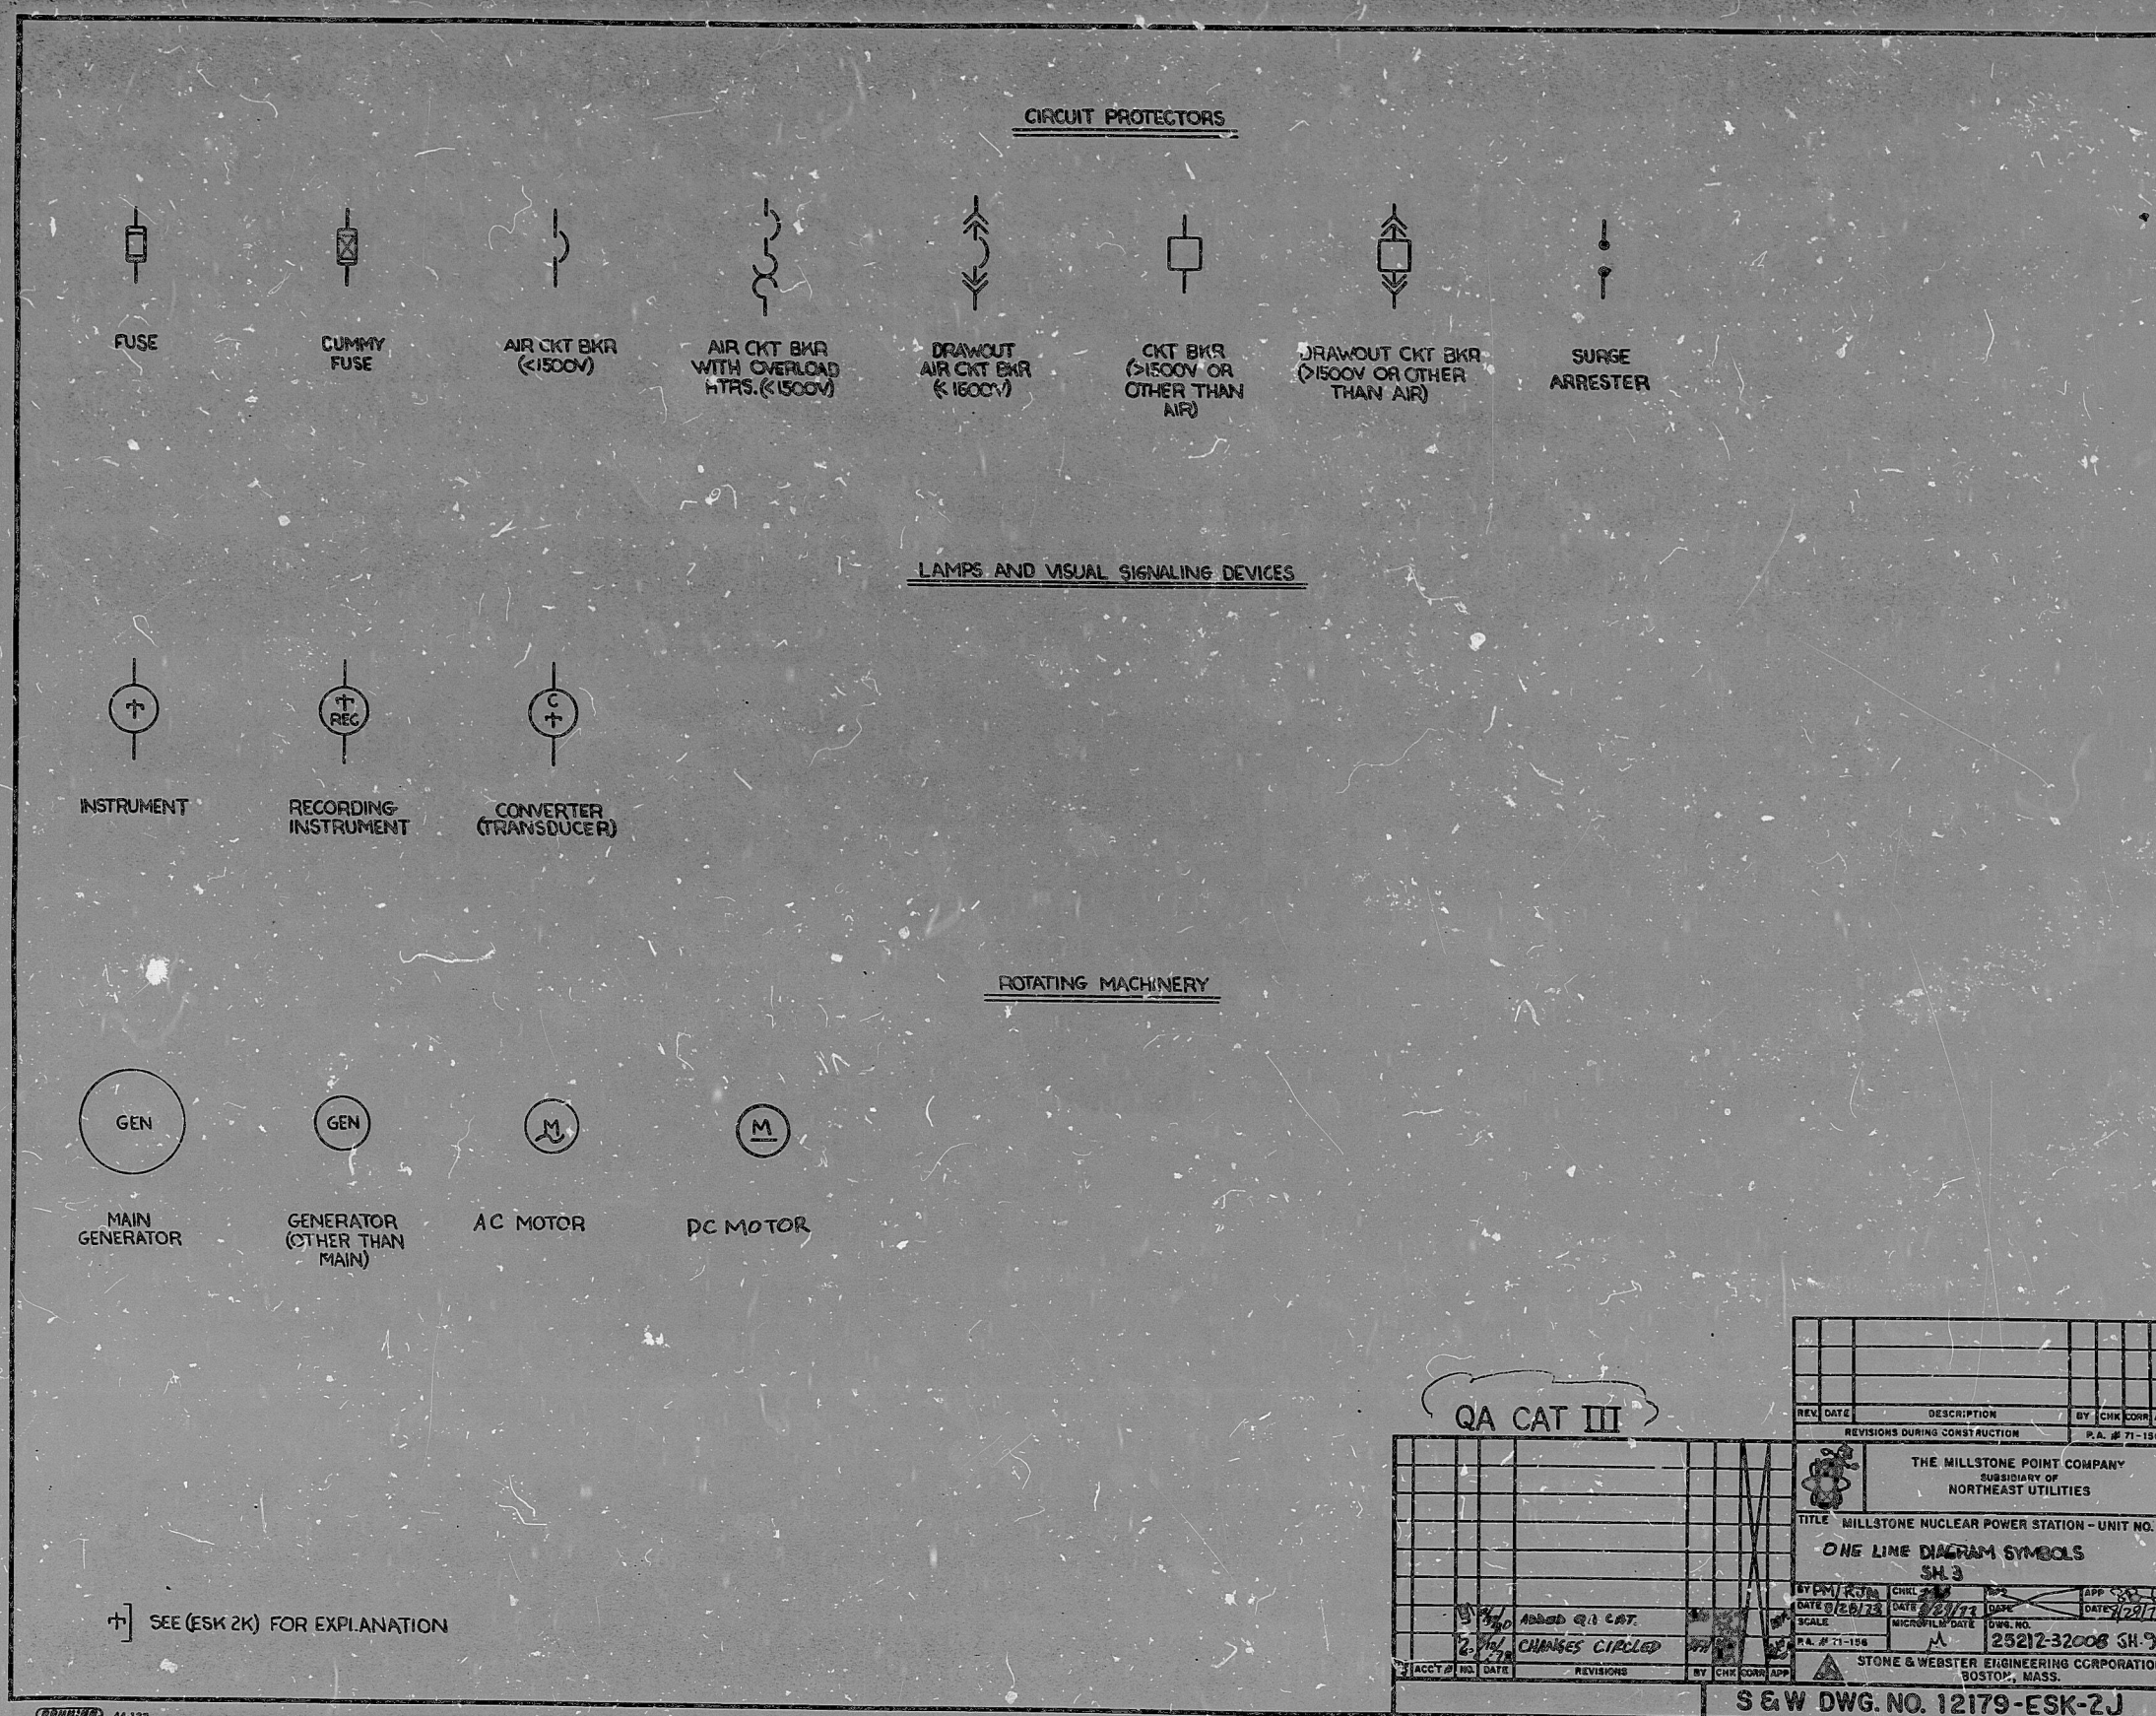

QA CAT III

REV	DATE	DESCRIPTION	BY	CHK	DATE	APP
REVISIONS DURING CONSTRUCTION						
P.A. # 71-196						
THE MILLSTONE POINT COMPANY SUBSIDIARY OF NORTHEAST UTILITIES						
TITLE: MILLSTONE NUCLEAR POWER STATION - UNIT NO. 3						
ONE LINE DIAGRAM SYMBOLS SH. 3						
BY	DATE	CHK	DATE	APP	DATE	APP
DATE 2/28/73	DATE 2/28/73	DATE 2/28/73	DATE 2/28/73	DATE 2/28/73	DATE 2/28/73	DATE 2/28/73
SCALE		MICROFILM DATE		DWN. NO.		APP. NO.
P.A. # 71-196				25212-32008 SH. 3		
STONE & WEBSTER ENGINEERING CORPORATION BOSTON, MASS.						
S & W DWG. NO. 12179-ESK-2J						

TI
APERTURE
CARD

PDR RIDS

8503270457

