


FORMER ORDER NO. 254-44377  
 DWG. NO. 2L-138A-CD-81

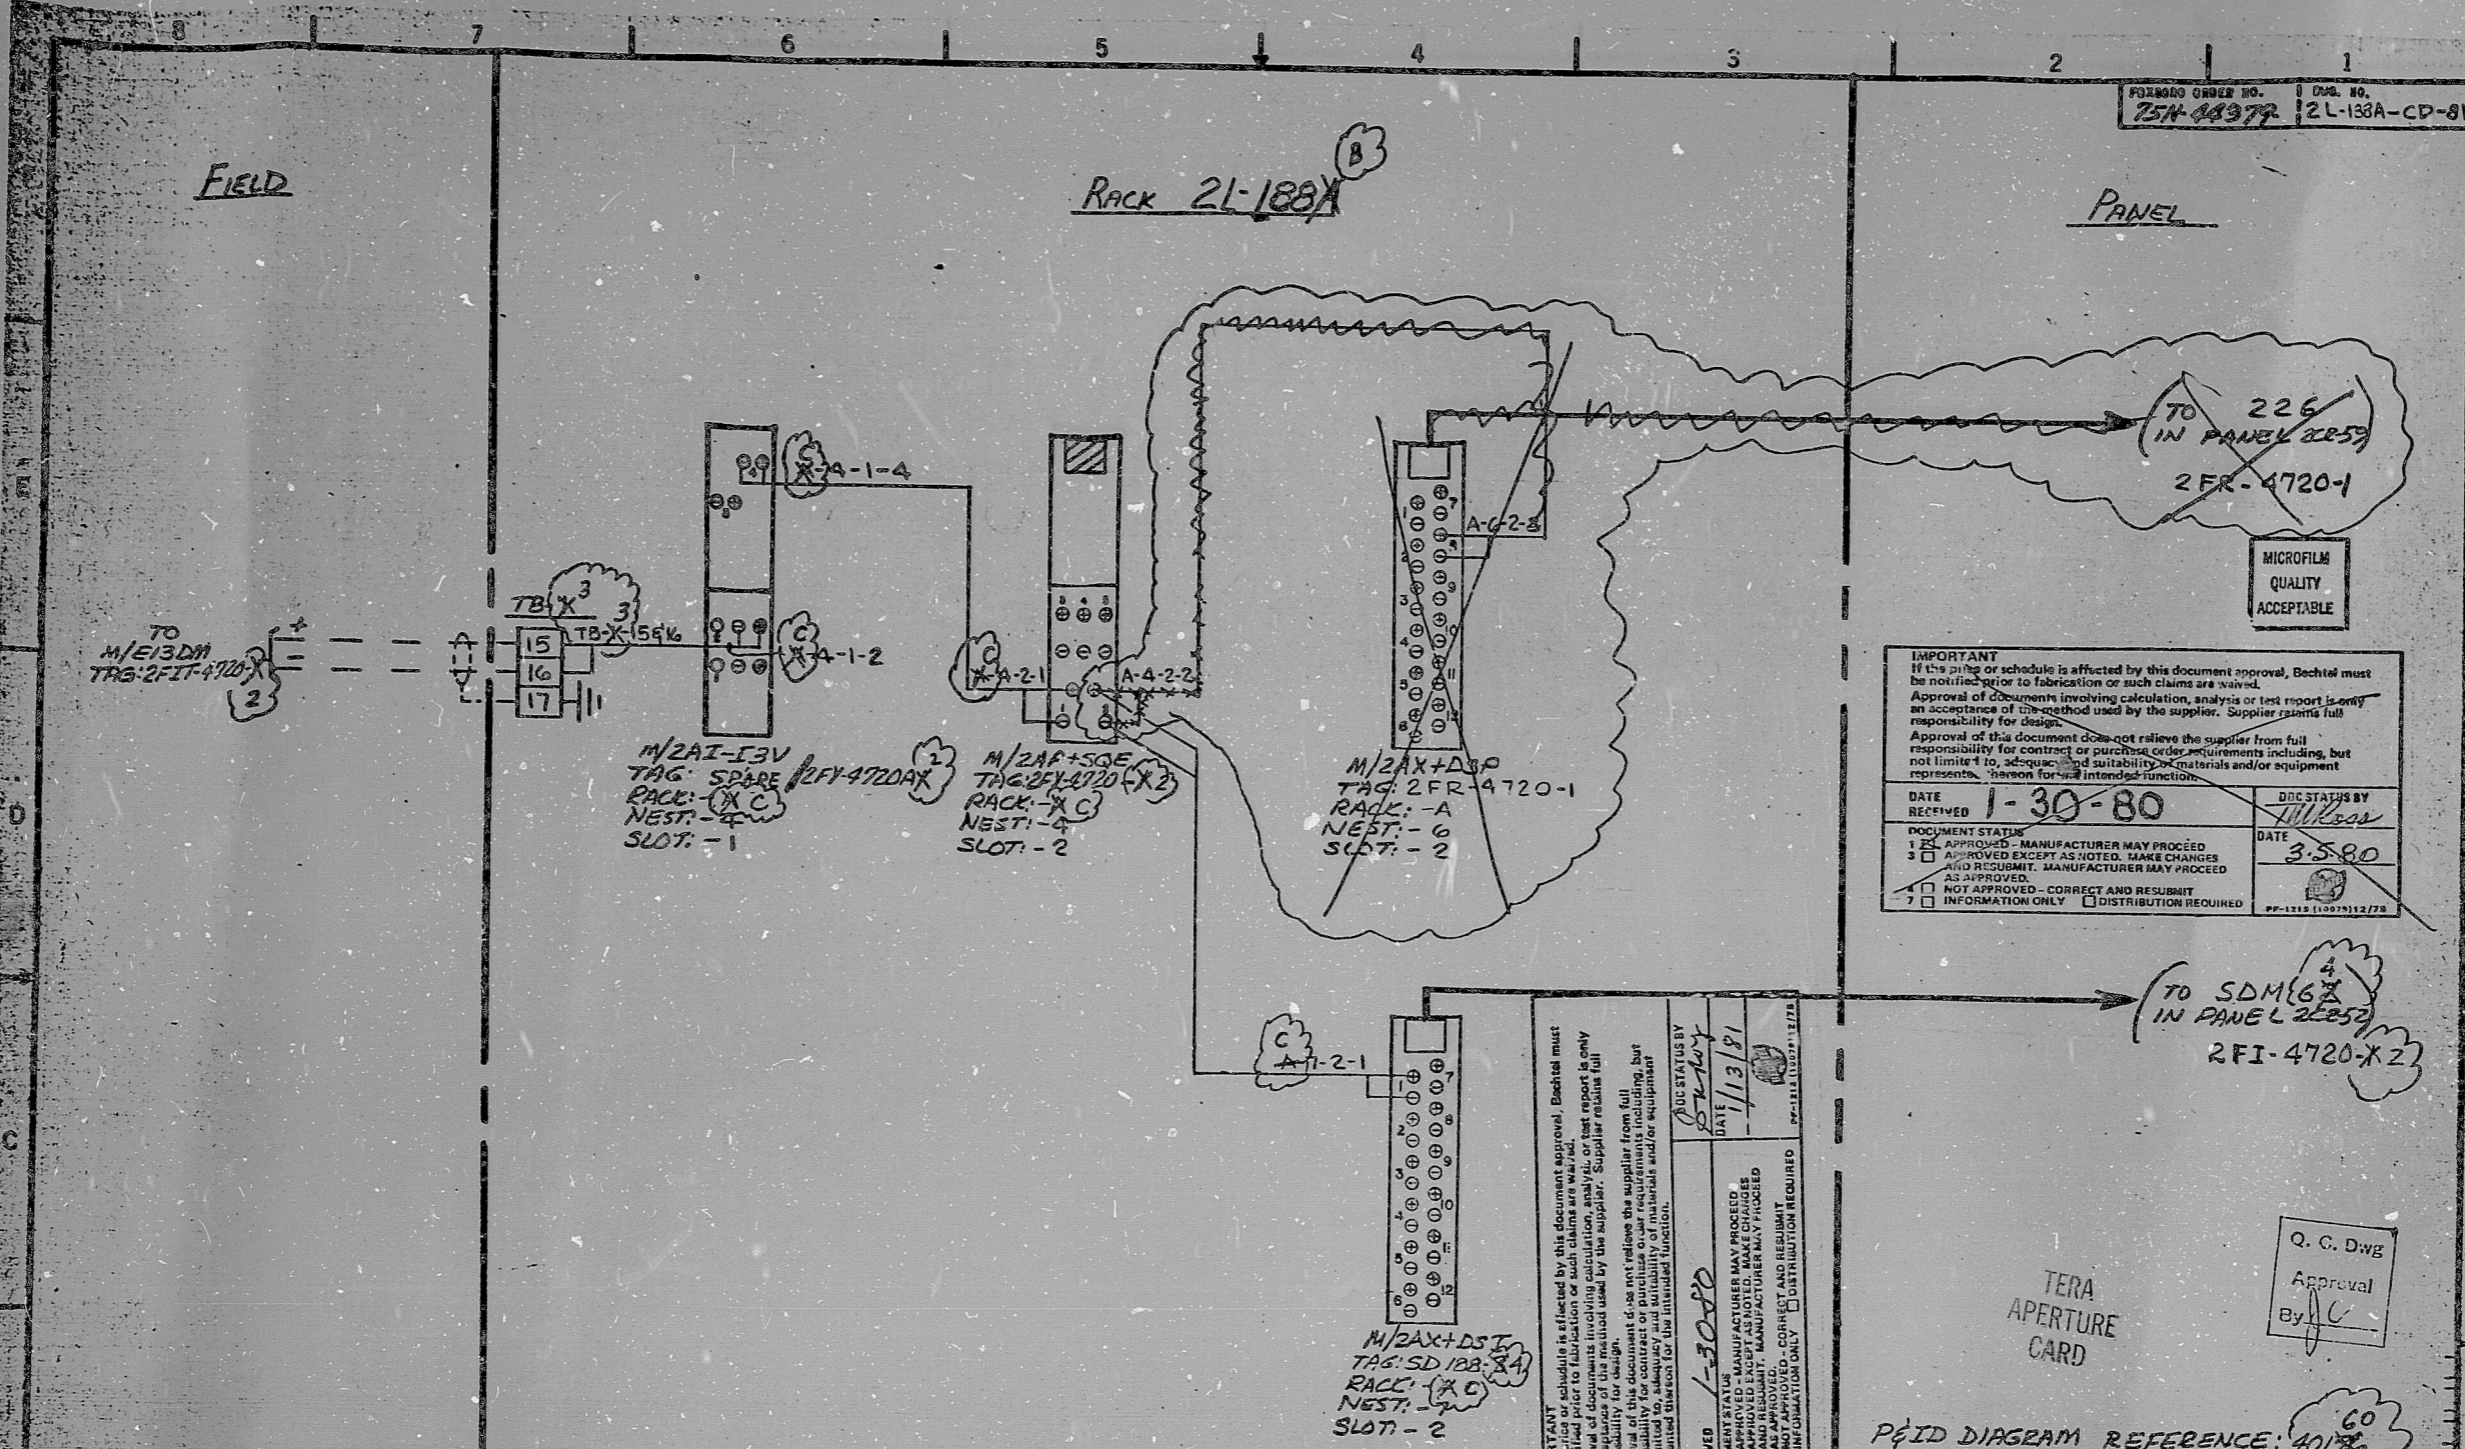

**IMPORTANT**  
 If the price or schedule is affected by this document approval, Bechtel must be notified prior to fabrication or such claims are waived.  
 Approval of documents involving calculation, analysis or test reports is only an acceptance of the method used by the supplier. Supplier retains full responsibility for design.  
 Approval of this document does not relieve the supplier from full responsibility for contract or purchase order requirements including, but not limited to, adequacy and suitability of materials and/or equipment resources. Reason for each intended function.

DATE RECEIVED 1-30-80  
 DATE 3-5-80  
 DDC STATUS BY [Signature]  
 DATE 3-5-80

1  APPROVED - MANUFACTURER MAY PROCEED  
 2  APPROVED EXCEPT AS NOTED. MAKE CHANGES AND RESUBMIT. MANUFACTURER MAY PROCEED AS APPROVED.  
 3  NOT APPROVED - CORRECT AND RESUBMIT  
 4  INFORMATION ONLY  DISTRIBUTION REQUIRED

**IMPORTANT**  
 If the price or schedule is affected by this document approval, Bechtel must be notified prior to fabrication or such claims are waived.  
 Approval of documents involving calculation, analysis or test reports is only an acceptance of the method used by the supplier. Supplier retains full responsibility for design.  
 Approval of this document does not relieve the supplier from full responsibility for contract or purchase order requirements including, but not limited to, adequacy and suitability of materials and/or equipment resources. Reason for each intended function.

DATE RECEIVED 1-30-80  
 DATE 1/13/81  
 DDC STATUS BY [Signature]  
 DATE 1/13/81

1  APPROVED - MANUFACTURER MAY PROCEED  
 2  APPROVED EXCEPT AS NOTED. MAKE CHANGES AND RESUBMIT. MANUFACTURER MAY PROCEED AS APPROVED.  
 3  NOT APPROVED - CORRECT AND RESUBMIT  
 4  INFORMATION ONLY  DISTRIBUTION REQUIRED

**GENERAL NOTE:**  
 A. FOR UNIT #3 SUBSTITUTE A NUMBER 3 FOR THE NUMBER 2 WHICH PREFIXES THE TAG NUMBER.  
 B. ALL 2/3 PREFIX TAG NO'S ARE COMMON TO BOTH UNITS AND APPEAR ON UNIT 2 RACK ONLY.

TERA APERTURE CARD  
 Q. C. DWG  
 Approval By [Signature]  
 P&ID DIAGRAM REFERENCE: 401X  
 COORDINATE: BR 63  
 SCB #0503  
 S023-504-3-355-45

REVISION				REFERENCE DRAWINGS	
NO.	DATE	BY	REASON		
1	1/17/77	AS	BUILT	LOOP 2FIT-4720-X2	
2	10/17/79	W/S	FIELD CHANGE	AUX. FEEDWATER TO SIM GEN. E088 SOUTHERN CALIFORNIA EDISON SAN ONOFRE NUCLEAR GEN. STA. BECHTEL POWER CORP.	
3					
4					
5					
6					
7					
8					
9					

THE FOXBORO COMPANY  
 FOXBORO, MASSACHUSETTS, U.S.A.

DESIGNED BY R. SCUSA  
 CHECKED BY [Signature]  
 DATE 1/13/81

CUSTOMER ORDER NO. V4105091  
 PROJECT NO. [Blank]  
 SHEET 1 of 1  
 DRAWING NO. 2L-138A-CD-81

FOXBORO COMPANY  
 CERTIFIED PRINT  
 BY WLS DATE 3/1/77

8.5"  
 11"  
 17"

8  
 11  
 17

RTDS—

8152040618

