


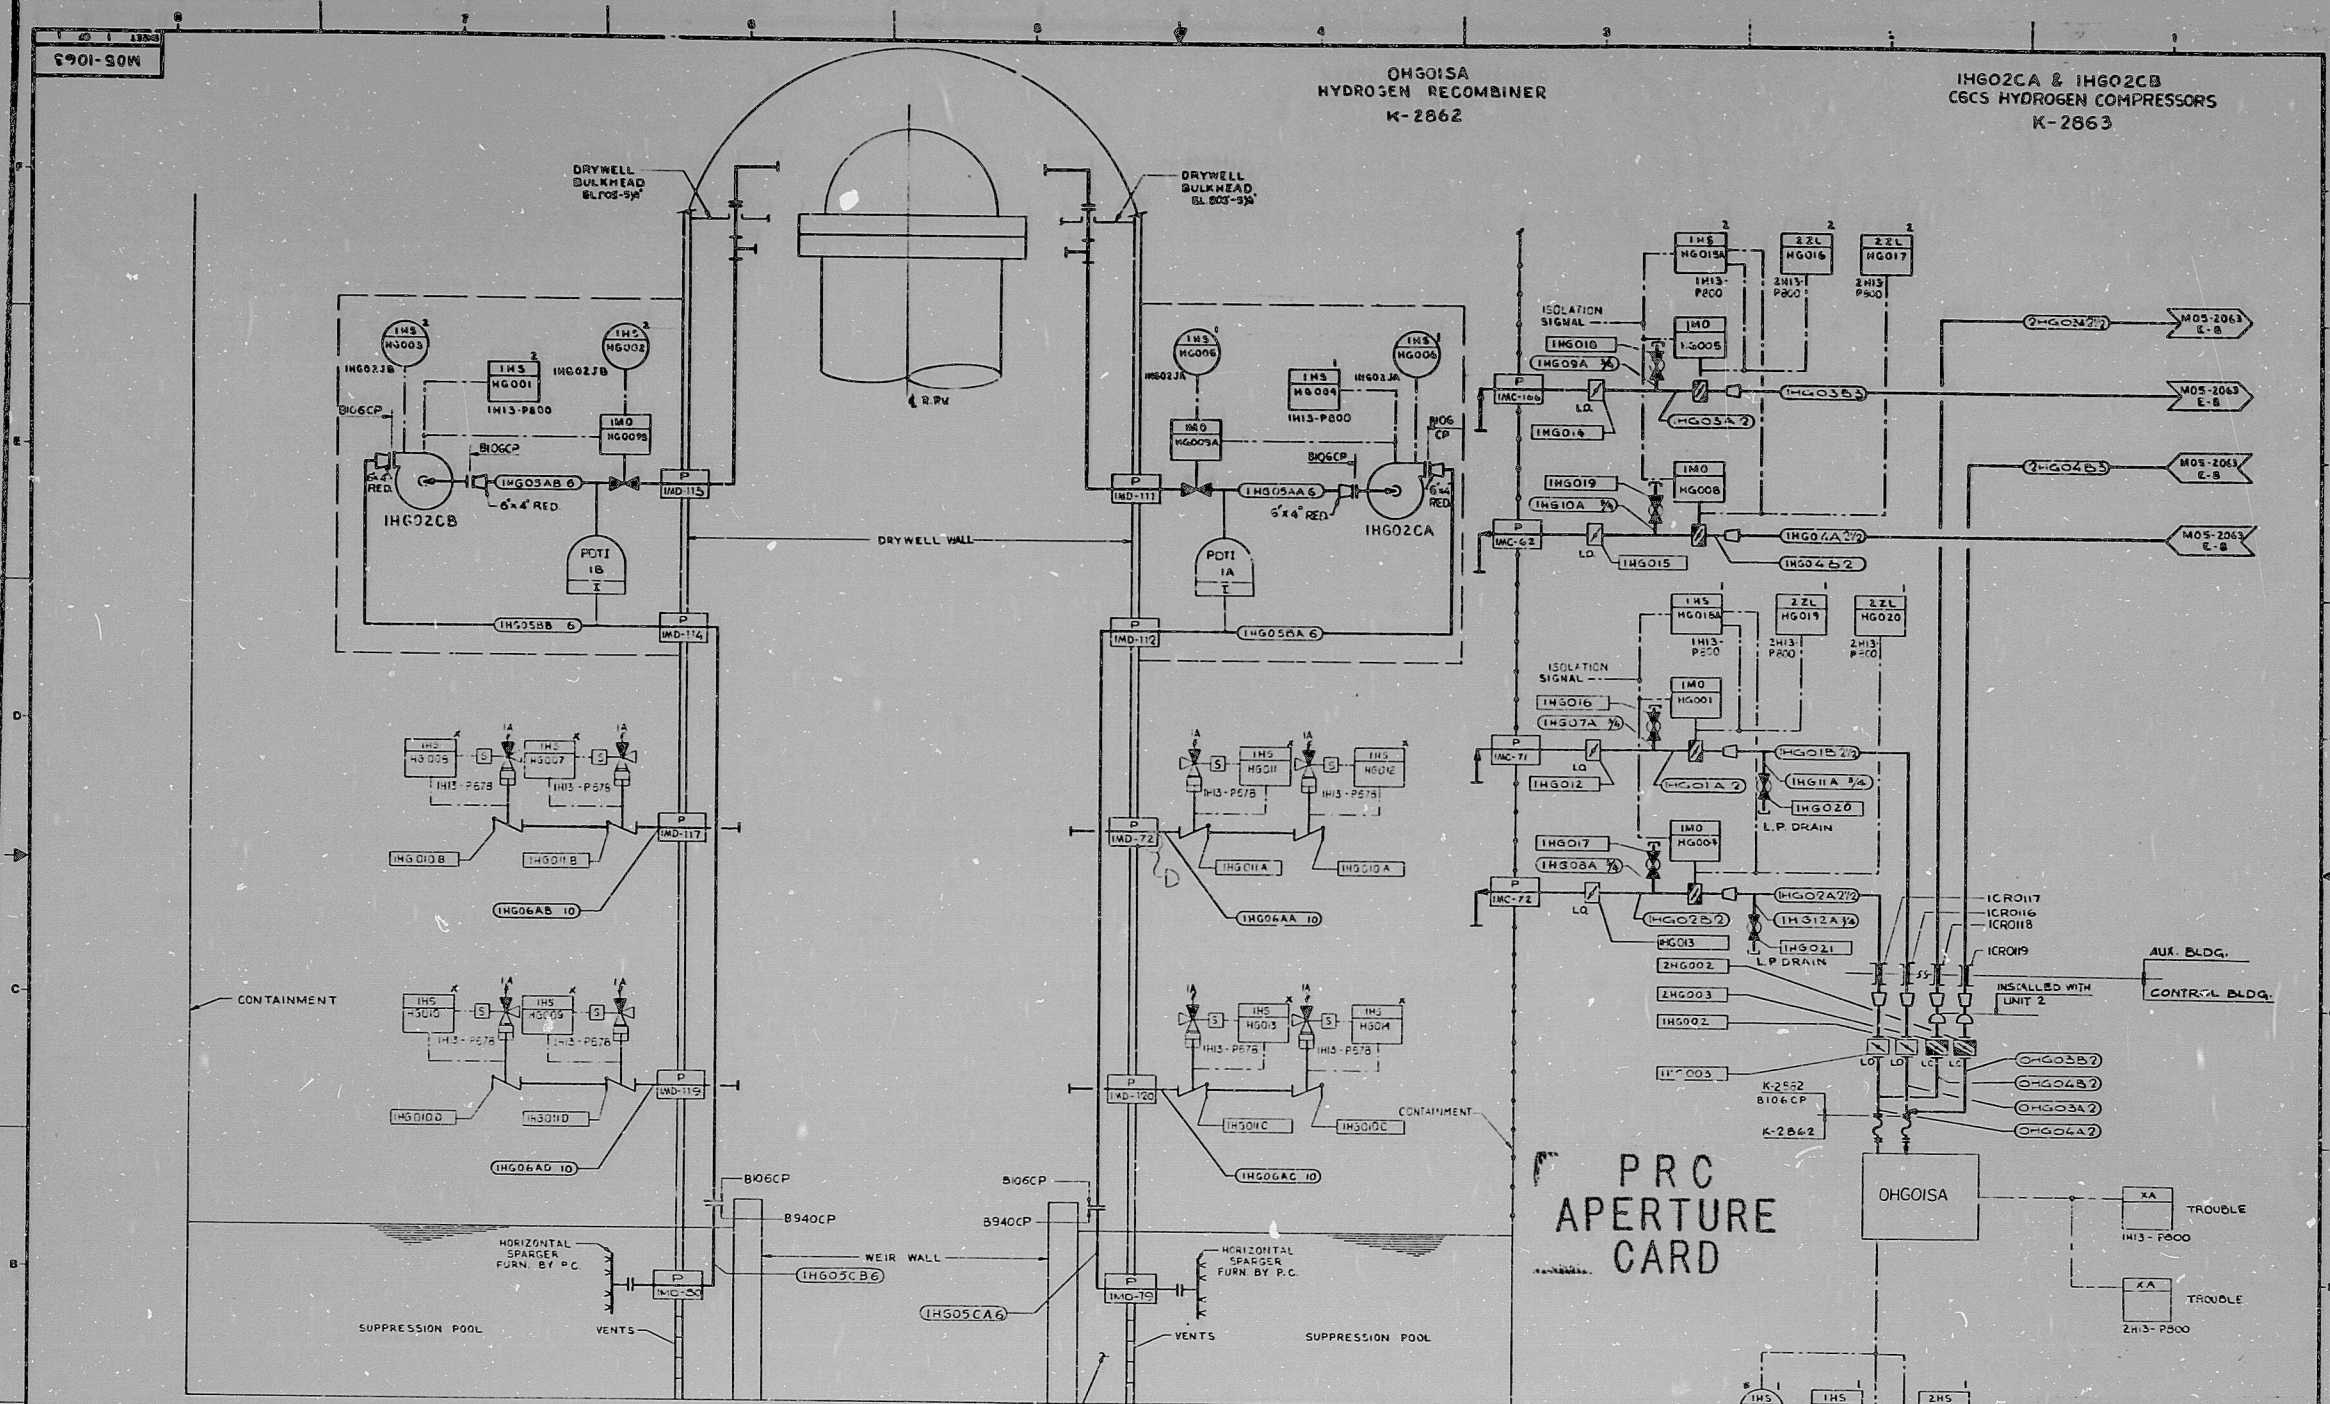


NOTE: 1. WHEN UNIT 2 IS INSTALLED, VALVES IHG006 AND IHG007 SHALL BE LOCKED CLOSED, AND VALVES ZHG006 AND ZHG007 SHALL BE LOCKED OPEN.
2. PIPE SIZE TO CHANGE FROM 2" TO 3" AFTER THE HIGH POINT IN ROUTING.

NUCLEAR SAFETY RELATED ITEMS ARE SHOWN ON THIS DRAWING (FOR SAFETY CLASSIFICATION SEE PIPING, EQUIPMENT, VALVE, OR INSTRUMENT LISTS.)

NOTE: THE P&ID C&I DIAGRAMS FOR THE C&I FUNCTION SYMBOLS ARE SHOWN ON DRAWING M05-1063. UNLESS OTHERWISE NOTED, SHEET NUMBER & DIAGRAM REFERENCE ARE SHOWN IN THE FUNCTION SYMBOL.

DRAWING RELEASE RECORD					FINAL ALPHA-NUMERICAL REVISION WAS REV. A-1 01-07-78				
REV	DATE	FIELD	PREPARED	REVIEWED	APPROVED	PURPOSE	REV	DATE	FIELD
A	5-16-78	01-07-78	W. J. H. H.	W. J. H. H.	W. J. H. H.	FOR FABRICATION & CONSTRUCTION - SPEC. K-2882			
B	2-12-79	01-07-79	W. J. H. H.	W. J. H. H.	W. J. H. H.	FOR CONSTRUCTION SPEC. K-2882 - L.P. DRAINS ADDED AND INSTRUMENTATION REVISED			
C	5-1-80	01-07-80	W. J. H. H.	W. J. H. H.	W. J. H. H.	FOR CONSTRUCTION SPEC. K-2882 - INSTRUMENTATION REVISED			
D	10-10-80	01-07-80	W. J. H. H.	W. J. H. H.	W. J. H. H.	FOR CONSTRUCTION SPEC. K-2882 - PENETRATION NO. CHANGED			

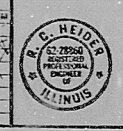

SCALE: NONE
PROJECT NUMBER: 4336
P&ID COMBUSTIBLE GAS CONTROL SYSTEM (HG) CLINTON POWER STATION UNIT #1 ILLINOIS POWER COMPANY CLINTON, ILLINOIS
DRAWING NO. M05-1063
SHEET 1 OF 1

RIDS

8204200044

