


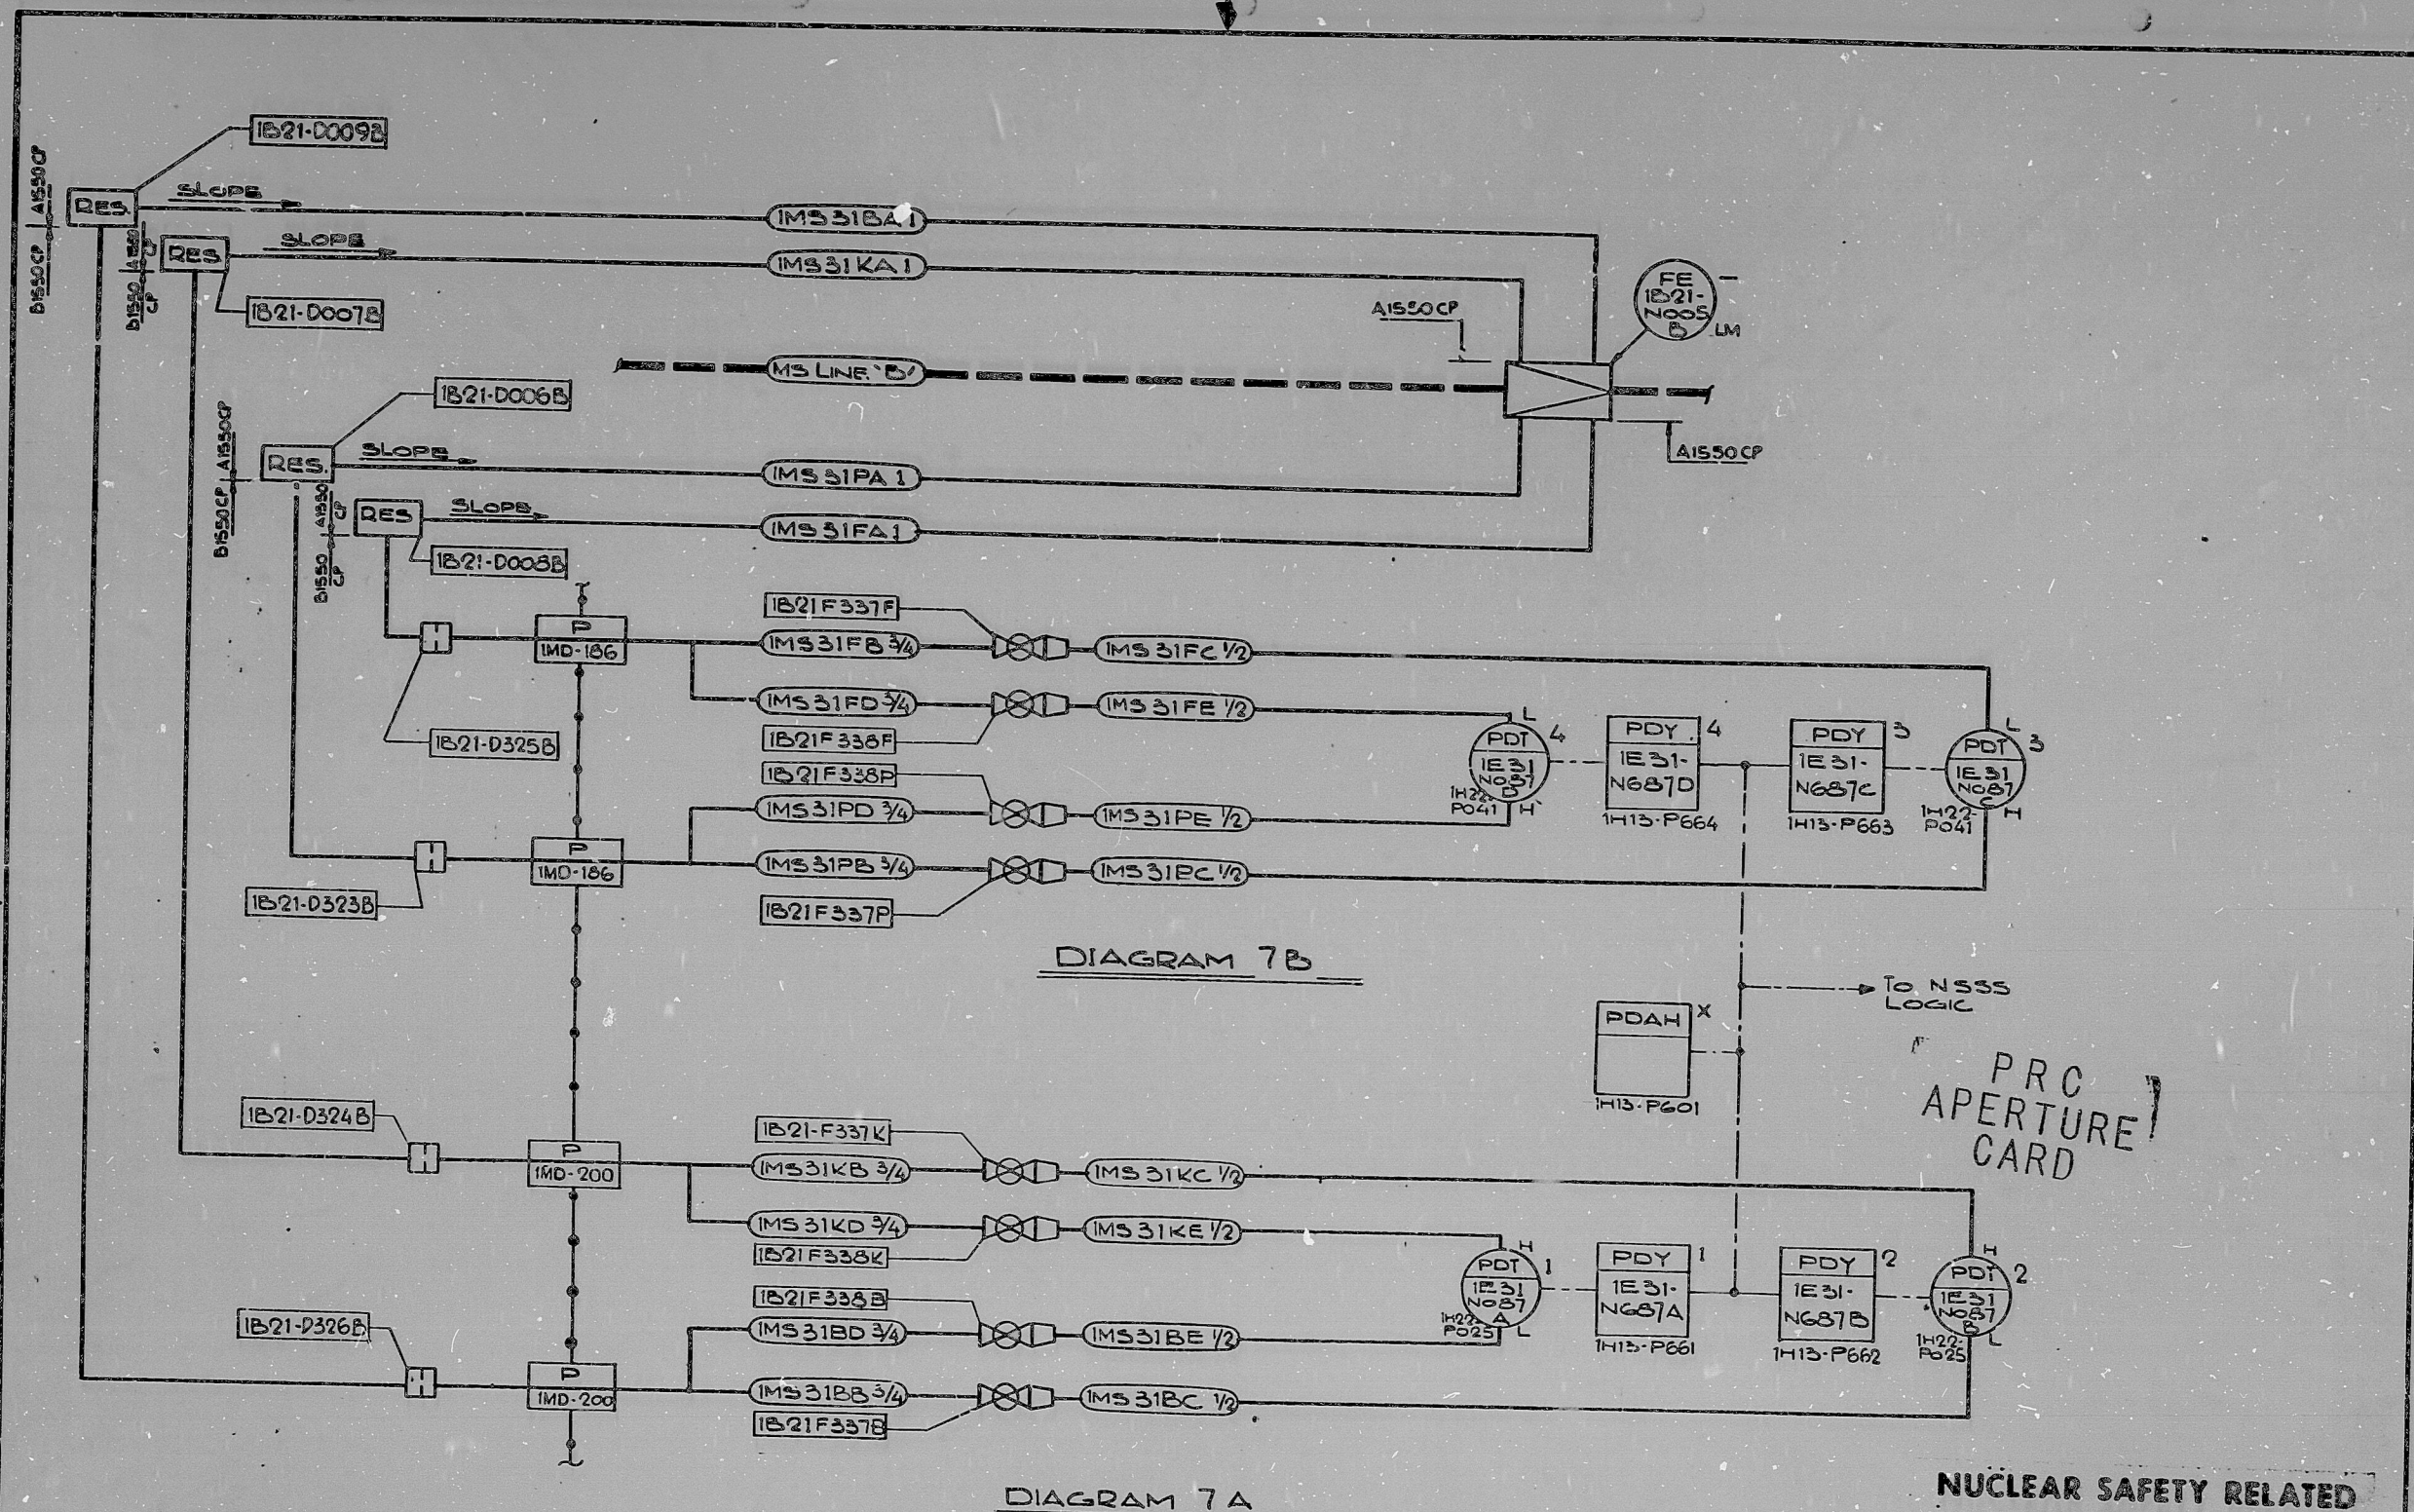

(FINAL NUMERIC. REV. WAS 5, DAT. 7-24-70)

DRAWING RELEASE RECORD

| REV. | SPEC. NO. | DATE     | FIELD | PREPARED       | REVIEWED    | APPROVED    | PURPOSE                        | FILM |
|------|-----------|----------|-------|----------------|-------------|-------------|--------------------------------|------|
| A    |           | 11-12-79 |       | W. J. D. M. M. | R. J. M. M. | R. J. M. M. | FOR CONSTRUCTION, SPEC. K-2882 |      |
|      |           |          |       |                |             |             |                                |      |
|      |           |          |       |                |             |             |                                |      |
2-CC4

DO NOT USE I, O, G, OR X FOR REVISION

SEAL



SCALE  
NONE  
PROJECT  
NUMBER  
4536

P&ID/C&I DIAGRAM  
MAIN STEAM  
SYSTEM (MS)  
CLINTON POWER STATION  
UNIT 1  
ILLINOIS POWER COMPANY  
CLINTON, ILLINOIS

NUCLEAR SAFETY RELATED

(REF. DWG. M05 1002 SHT. 1)

SARGENT & LUNDY  
CHICAGO

DRAWING NO.  
M10-1002  
REV.  
A

SHEET 7 OF 24



RIDS

6204200512

