


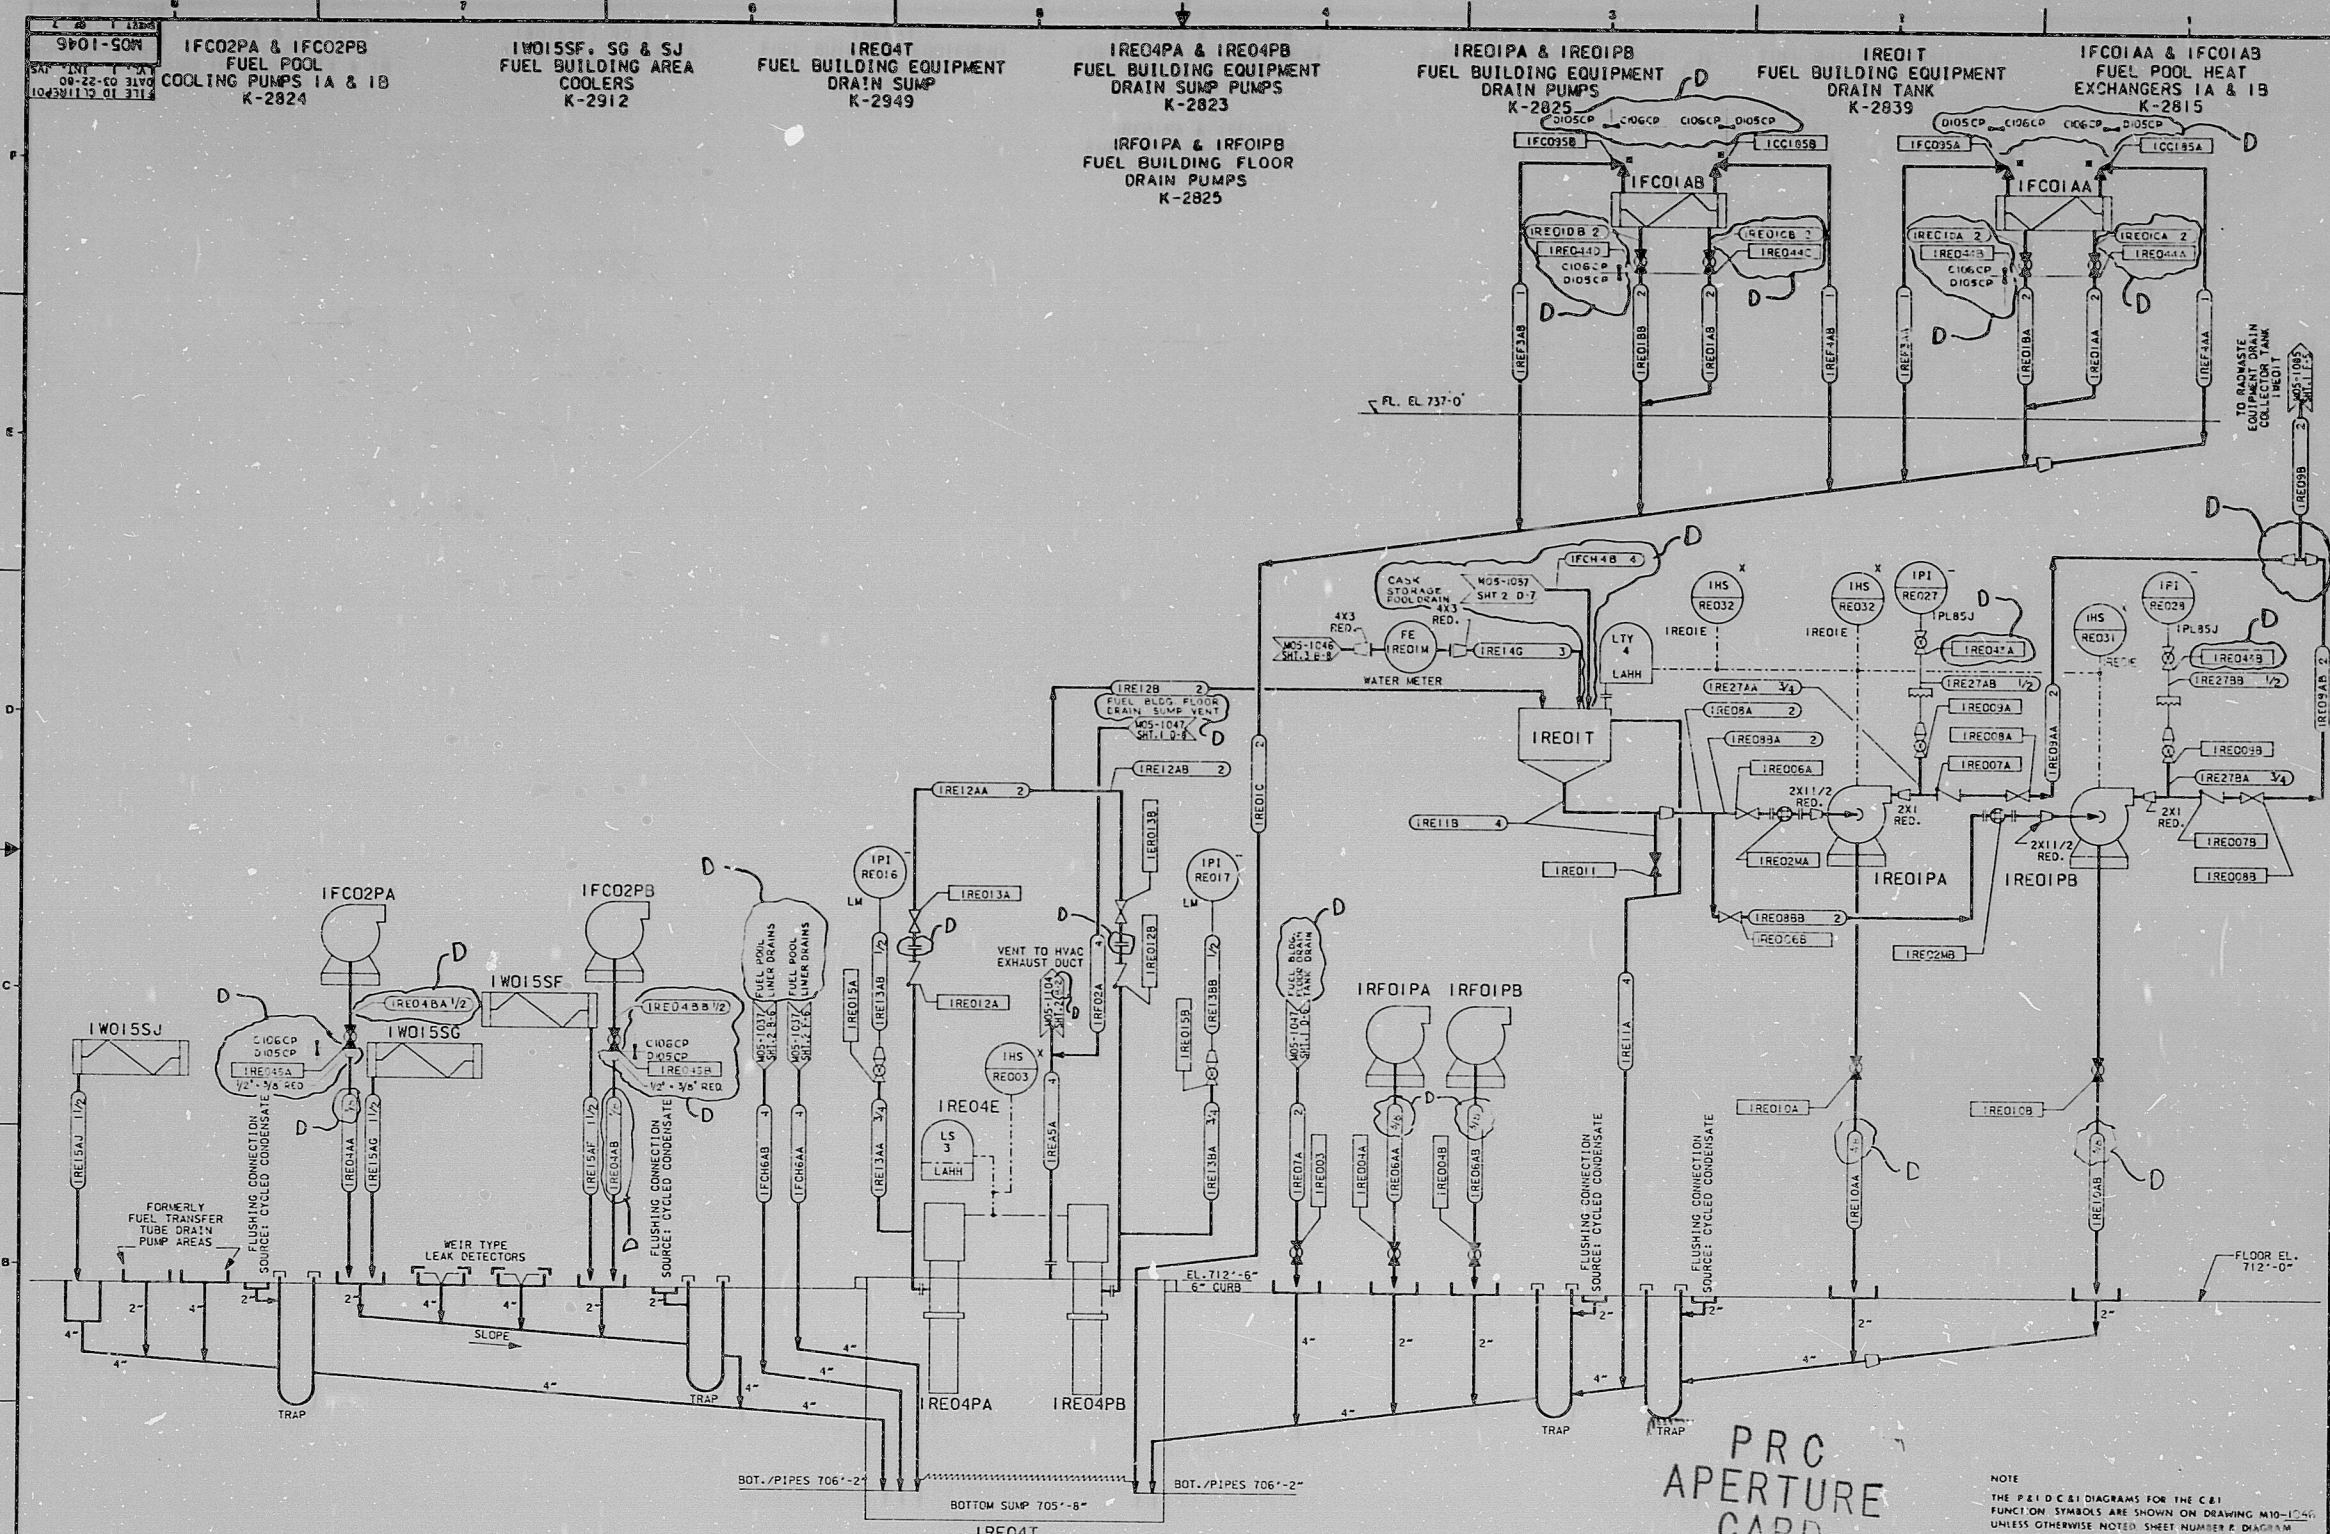

DRAWING RELEASE RECORD					DRAWING RELEASE RECORD				
REV.	DATE	BY	APPROVED	PURPOSE	REV.	DATE	BY	APPROVED	PURPOSE
1	5-15-80	W. J. ...	...	FOR CONSTRUCTION SPEC. K-2882 - REDRAWN PLANT SINKING, GROUND LEAK-UP DRAINS DELETED & REVISED TO SUIT PIPE ROUTING.	1	5-15-80	W. J. ...	...	FOR CONSTRUCTION SPEC. K-2882 - REDRAWN PLANT SINKING, GROUND LEAK-UP DRAINS DELETED & REVISED TO SUIT PIPE ROUTING.
2	7-20-81	W. J. ...	...	ADDED AND REVISED, ADDED CLASS CHANGES & CHANGED VALVE AND FLANGES, ADDED.	2	7-20-81	W. J. ...	...	ADDED AND REVISED, ADDED CLASS CHANGES & CHANGED VALVE AND FLANGES, ADDED.

PRC
APERTURE
CARD

NOTE:
THE P&ID C&I DIAGRAMS FOR THE C&I
FUNCTION SYMBOLS ARE SHOWN ON DRAWING M05-1046.
UNLESS OTHERWISE NOTED, SHEET NUMBER P&I DIAGRAM
REFERENCE ARE SHOWN IN THE FUNCTION SYMBOL.

P & ID FUEL BUILDING
EQUIPMENT DRAINS
(RE)
CLINTON POWER STATION
UNIT 1
ILLINOIS POWER COMPANY
CLINTON, ILLINOIS

SCALE
NOTE
PROJECT
NUMBER
4536-00

SARGENT & LUNDY
ENGINEERS
CHICAGO

DRAWING NO.
M05-1046
REV.
D
SHEET 1 OF 7

RID3

804210264

