

34"

26"

22"

20"

18"

16"

14"

12"

10"

8"


6"

4"

2"

0"


34"

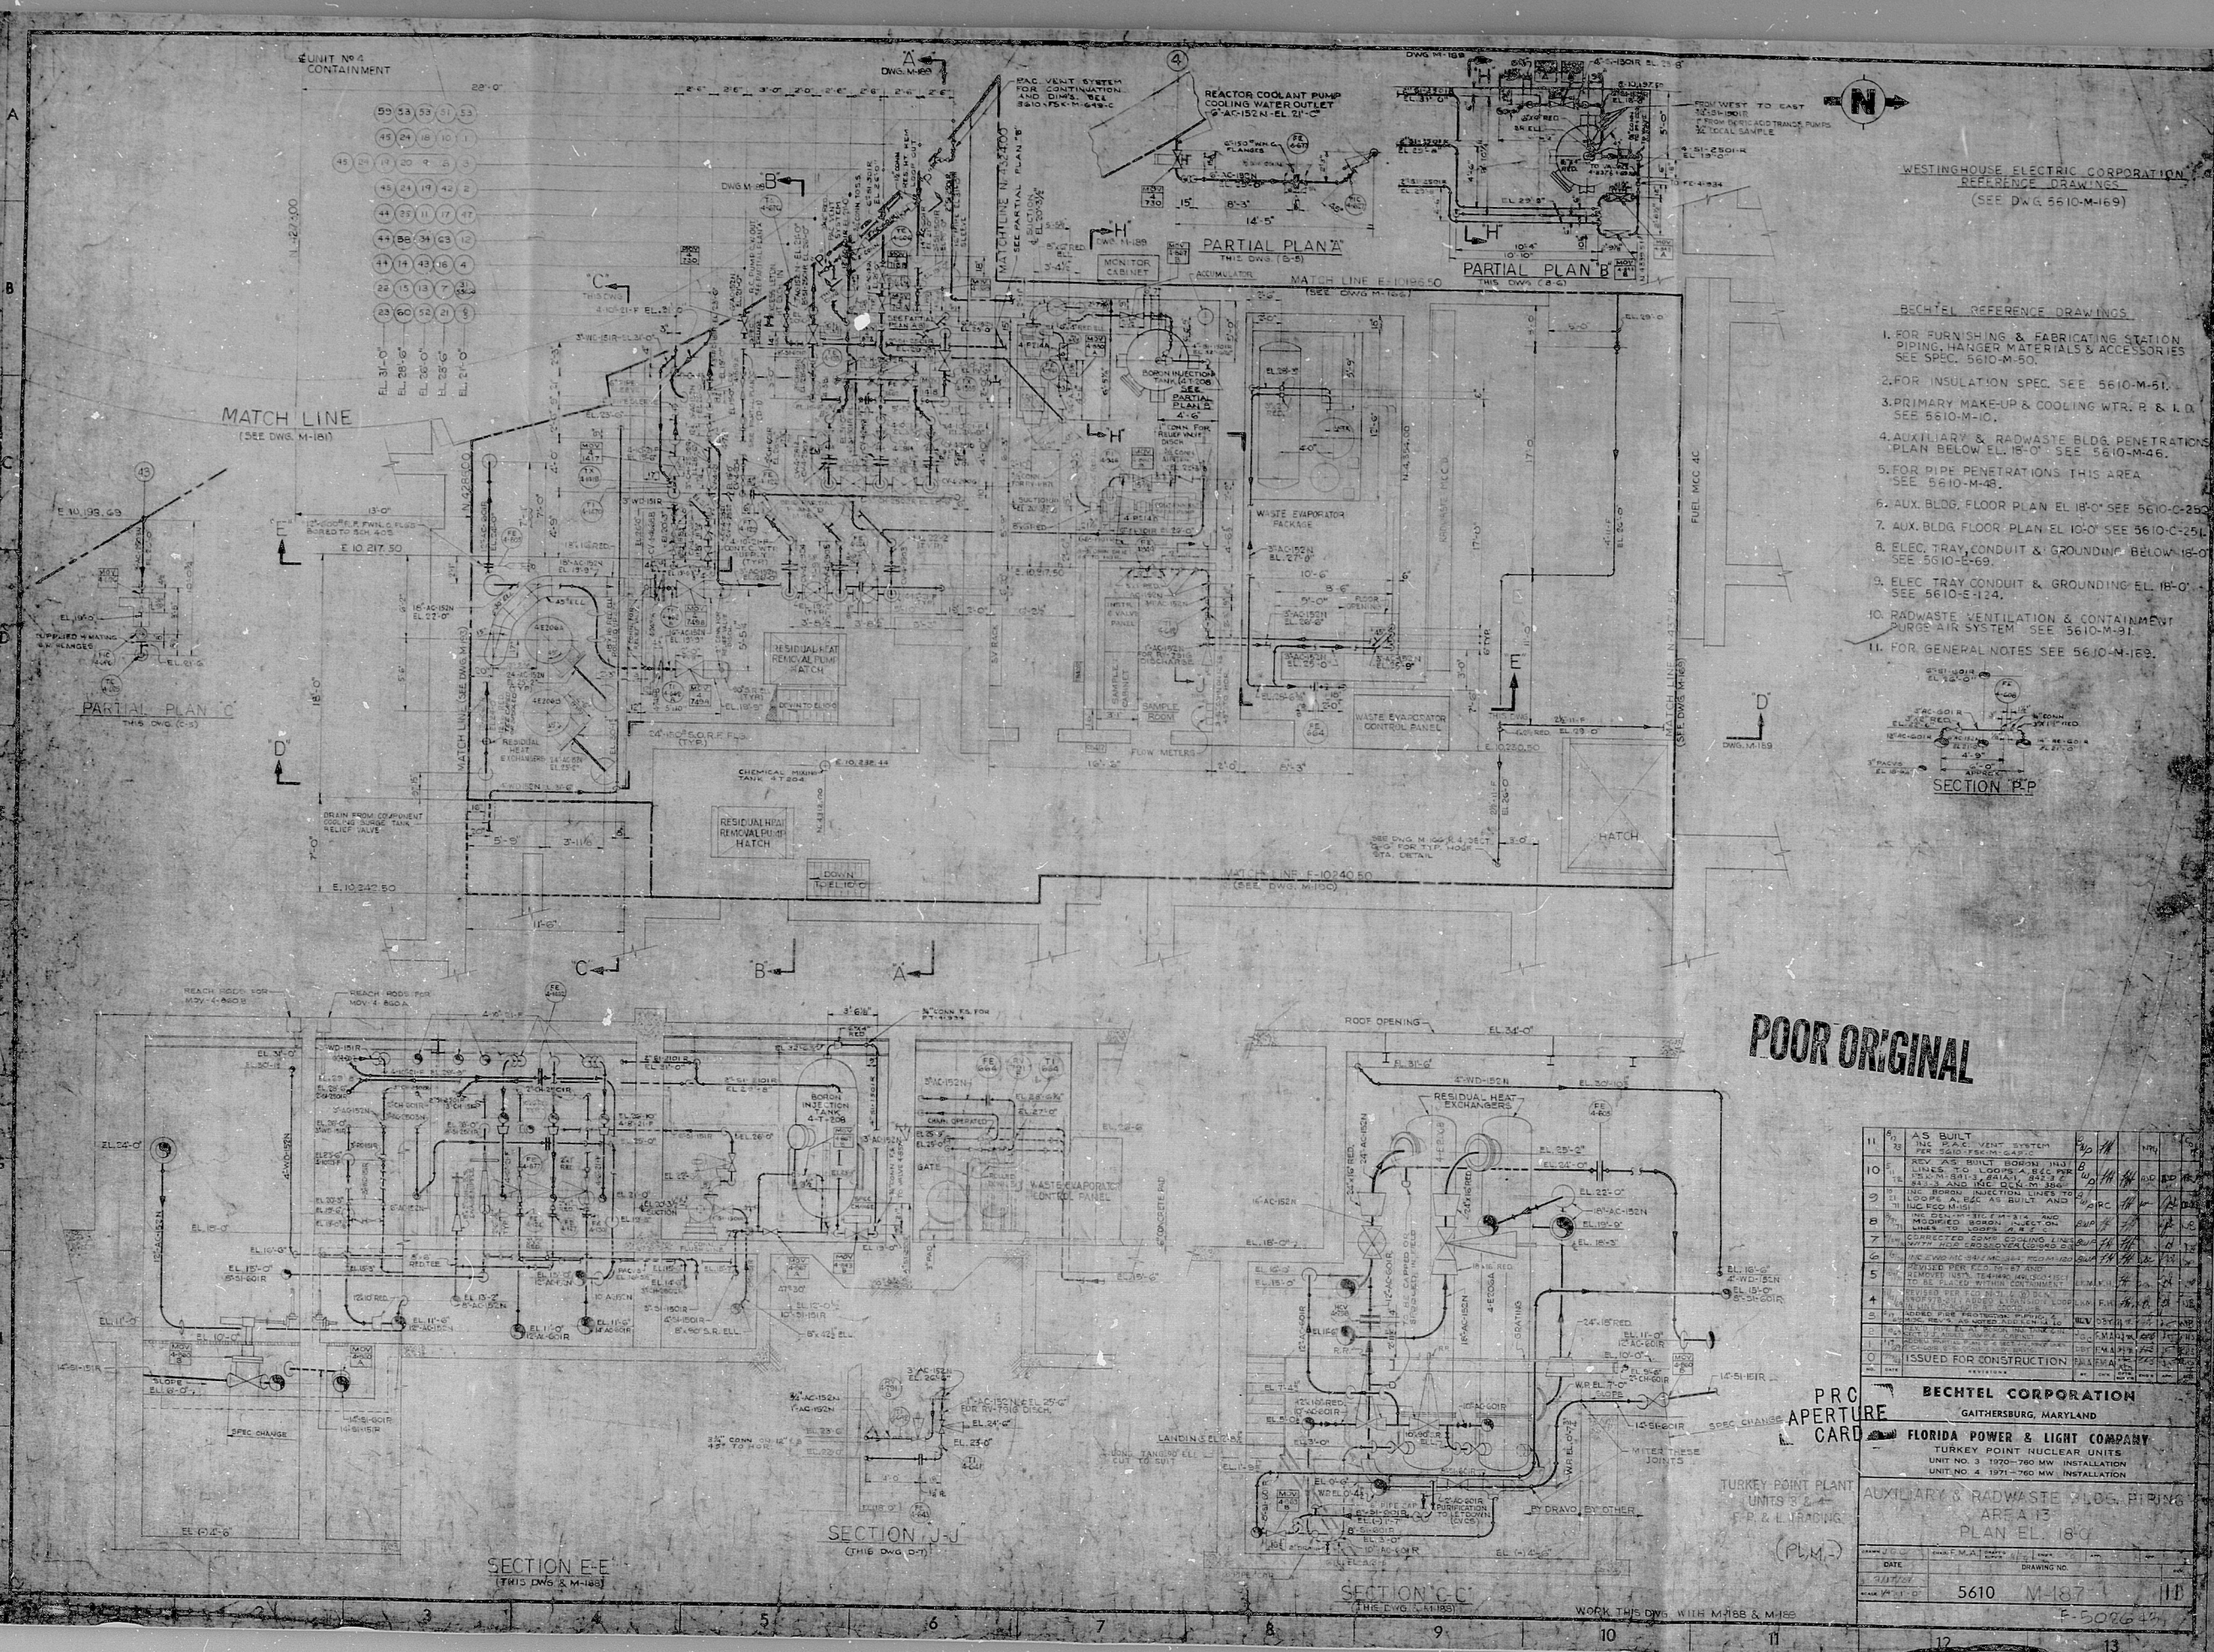

WESTINGHOUSE ELECTRIC CORPORATION
REFERENCE DRAWINGS
(SEE DWG. 5610-M-169)

BECHTEL REFERENCE DRAWINGS

1. FOR FURNISHING & FABRICATING STATION PIPING, HANGER MATERIALS & ACCESSORIES SEE SPEC. 5610-M-50.
2. FOR INSULATION SPEC. SEE 5610-M-51.
3. PRIMARY MAKE-UP & COOLING WATER R & L.D. SEE 5610-M-10.
4. AUXILIARY & RADWASTE BLDG. PENETRATIONS FOR PIPE PENETRATIONS THIS AREA SEE 5610-M-48.
5. AUX. BLDG. FLOOR PLAN EL. 18'-0" SEE 5610-C-250.
6. AUX. BLDG. FLOOR PLAN EL. 10'-0" SEE 5610-C-251.
7. ELEC. TRAY, CONDUIT & GROUNDING BELOW EL. 18'-0" SEE 5610-E-69.
8. ELEC. TRAY, CONDUIT & GROUNDING EL. 18'-0" SEE 5610-E-124.
9. RADWASTE VENTILATION & CONTAINMENT PURGE AIR SYSTEM SEE 5610-M-91.
10. FOR GENERAL NOTES SEE 5610-M-163.

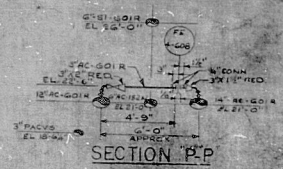

POOR ORIGINAL

11	AS BUILT	INC. PAC-VENT SYSTEM	6/10/71	NY	1/20
10	REV. AS BUILT	BORON INJECTION LINE TO BORON INJECTION LINE	6/10/71	NY	1/20
9	REV. AS BUILT	BORON INJECTION LINE TO BORON INJECTION LINE	6/10/71	NY	1/20
8	REV. AS BUILT	BORON INJECTION LINE TO BORON INJECTION LINE	6/10/71	NY	1/20
7	REV. AS BUILT	BORON INJECTION LINE TO BORON INJECTION LINE	6/10/71	NY	1/20
6	REV. AS BUILT	BORON INJECTION LINE TO BORON INJECTION LINE	6/10/71	NY	1/20
5	REV. AS BUILT	BORON INJECTION LINE TO BORON INJECTION LINE	6/10/71	NY	1/20
4	REV. AS BUILT	BORON INJECTION LINE TO BORON INJECTION LINE	6/10/71	NY	1/20
3	REV. AS BUILT	BORON INJECTION LINE TO BORON INJECTION LINE	6/10/71	NY	1/20
2	REV. AS BUILT	BORON INJECTION LINE TO BORON INJECTION LINE	6/10/71	NY	1/20
1	REV. AS BUILT	BORON INJECTION LINE TO BORON INJECTION LINE	6/10/71	NY	1/20

PRO APERTURE CARD
BECHTEL CORPORATION
GAITHERSBURG, MARYLAND
FLORIDA POWER & LIGHT COMPANY
TURKEY POINT NUCLEAR UNIT
UNIT NO. 3 1700-760 MW INSTALLATION
UNIT NO. 4 1701-760 MW INSTALLATION

DATE	5610	M-187	10
DRAWING NO.	F-50864		

34"

26"

22"

20"

18"

16"

14"

12"

10"

8"

6"

4"

2"

0"

34"

34"

RIPS

8704280228

