


1X3D651C 30X

THIS DRAWING IS THE PROPERTY OF THE GEORGIA POWER COMPANY. IT IS TO BE USED ONLY FOR THE PURPOSES FOR WHICH IT WAS PREPARED. IT IS NOT TO BE REPRODUCED OR TRANSMITTED IN ANY FORM OR BY ANY MEANS, ELECTRONIC OR MECHANICAL, INCLUDING PHOTOCOPYING, RECORDING, OR BY ANY INFORMATION STORAGE AND RETRIEVAL SYSTEM, WITHOUT THE WRITTEN PERMISSION OF THE GEORGIA POWER COMPANY.

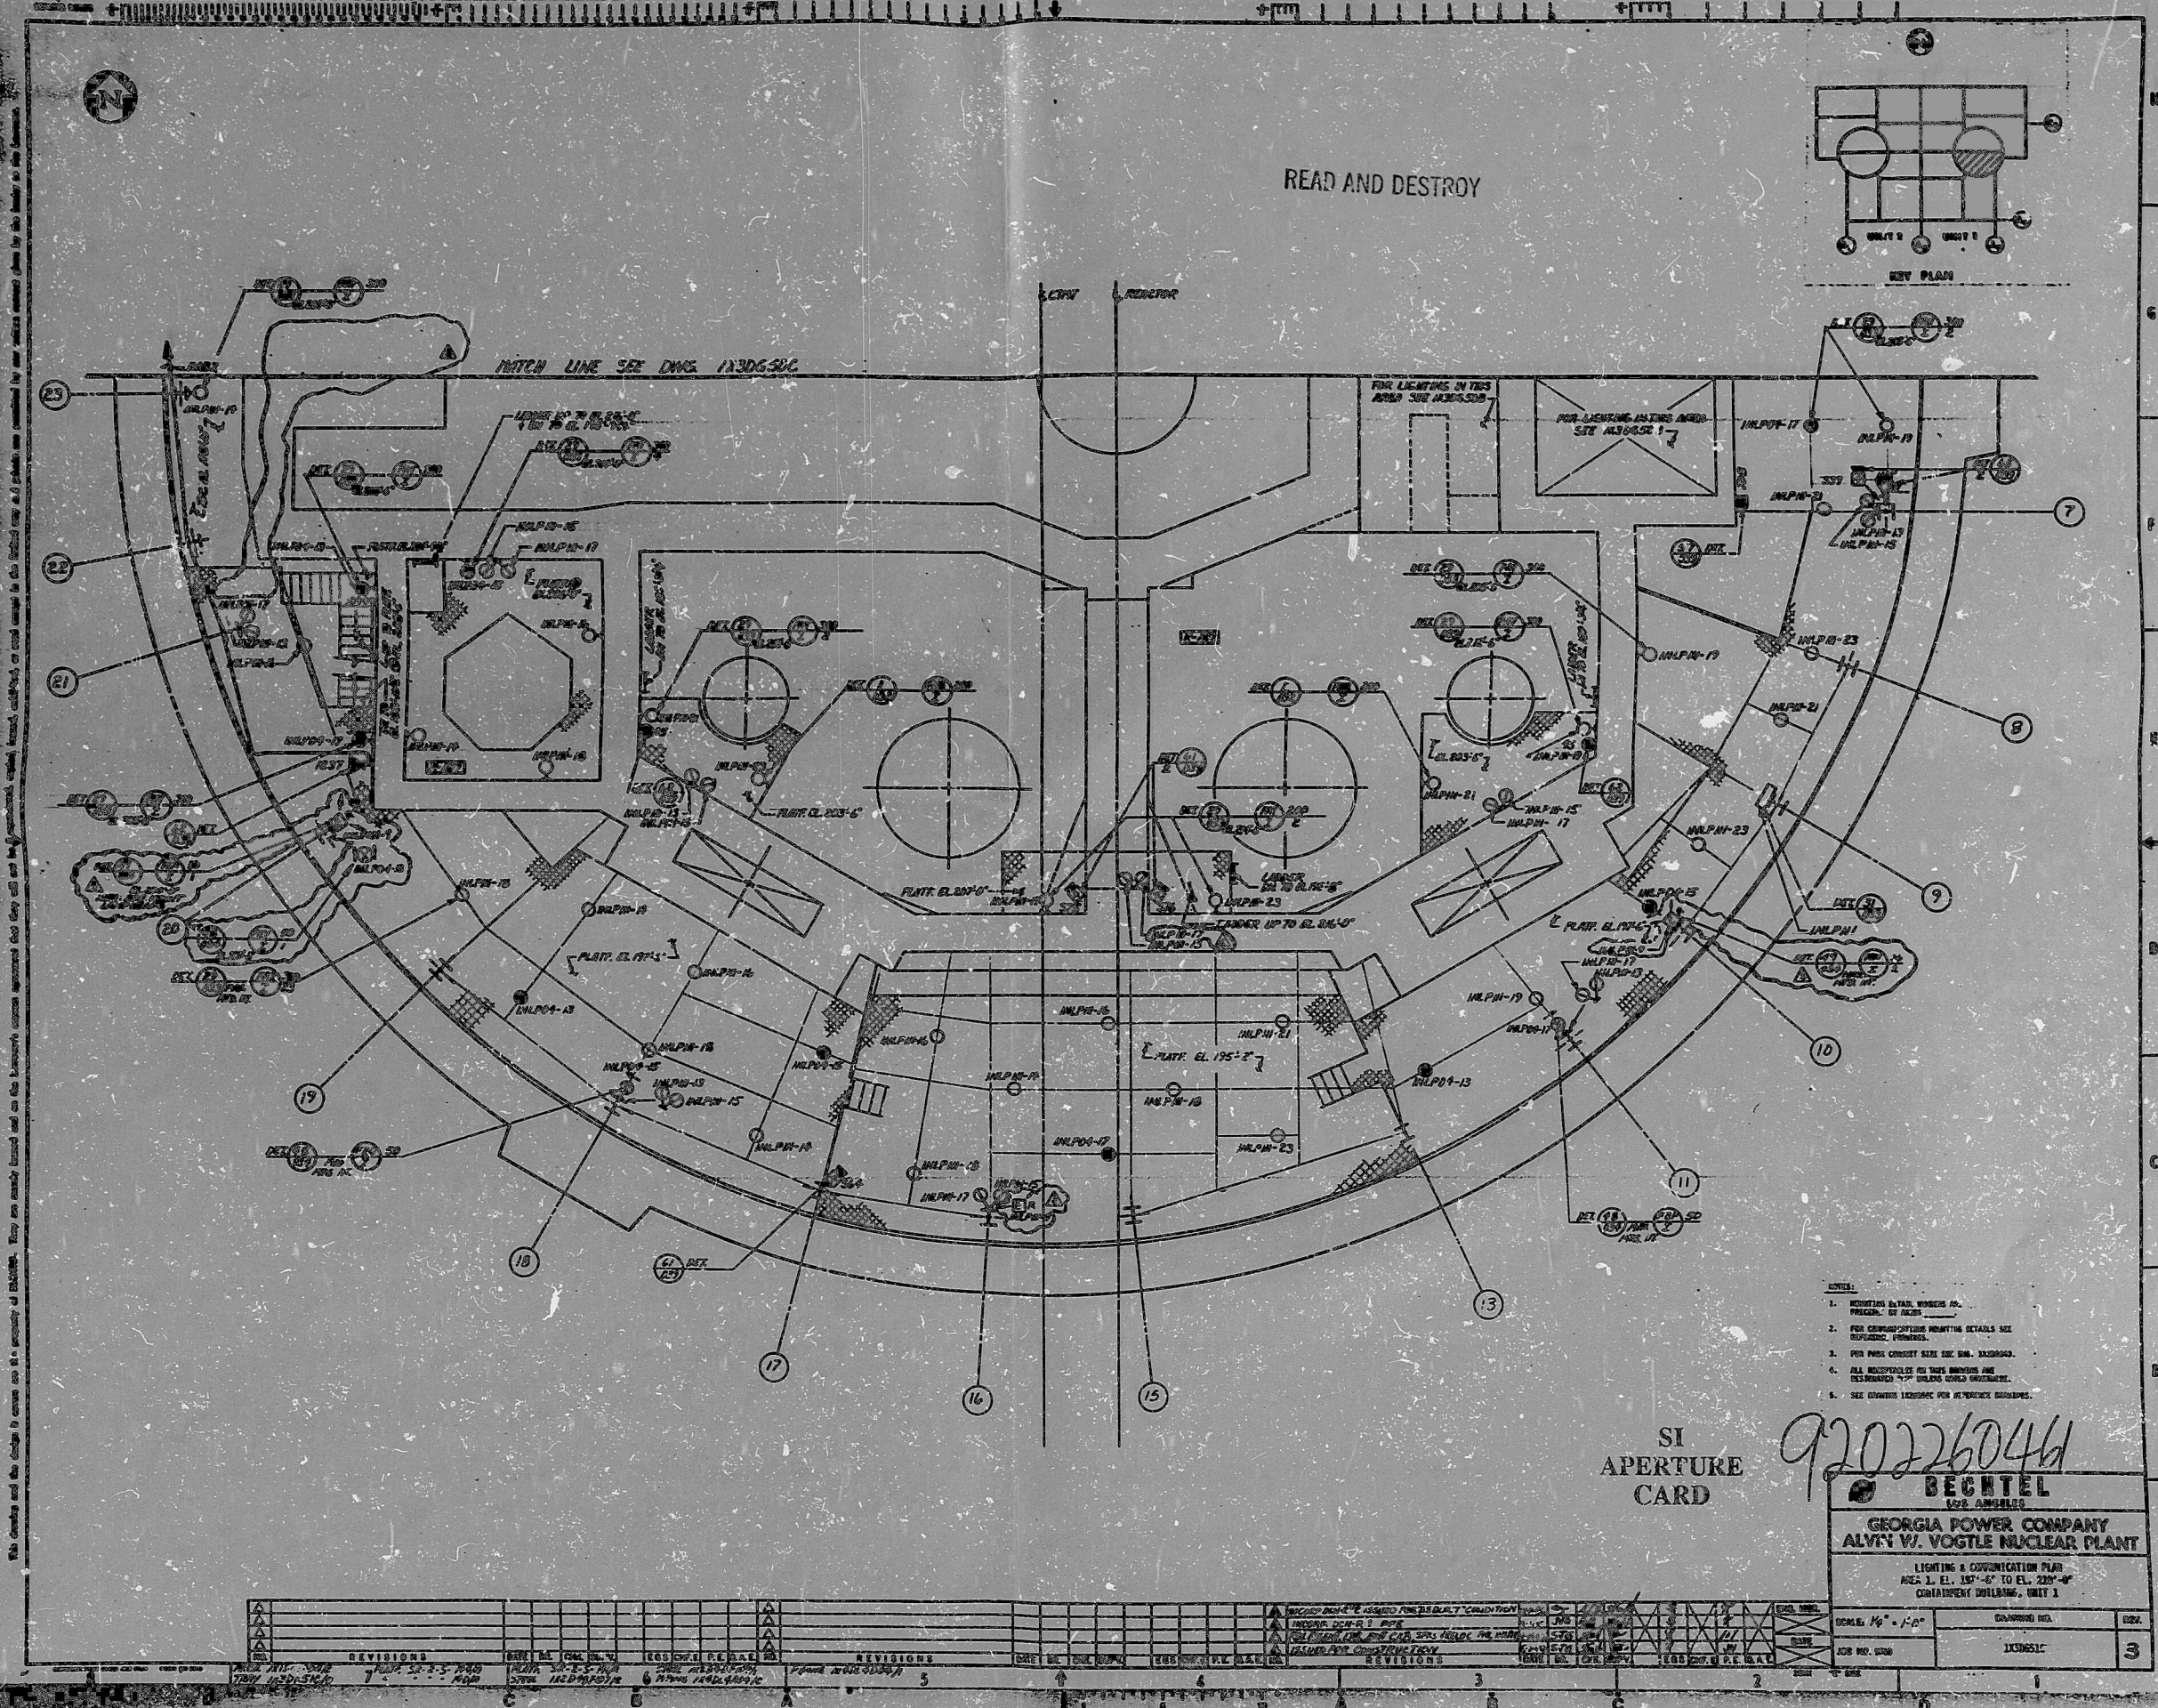

- NOTES:
1. INDICATING ALARM, WARNING, AND PROTECTIVE SIGNALS.
 2. FOR CHANGING POSITIONING DETAILS SEE REVISIONS, REVISIONS.
 3. FOR PUMP CONDUIT SIZE SEE DWG. 1X3D651C.
 4. ALL DIMENSIONS ARE IN FEET AND INCHES.
 5. SEE DRAWING 1X3D651C FOR REVISIONS.

SI
APERTURE
CARD

9202260461

BECHTEL	
GEORGIA POWER COMPANY	
ALVIN W. VOGTLE NUCLEAR PLANT	
LIGHTING & COMMUNICATION PLAN	
AREA 1, EL. 15'-6" TO EL. 220'-0"	
CONTAINMENT BUILDING, UNIT 1	
SCALE: 1/4" = 1'-0"	CONVISED NO.
JOB NO. 1000	1X3D651C
3	

REVISIONS	DATE	BY	CHKD BY	DESCRIPTION
1	10/1/77	J. H. HARRIS	J. H. HARRIS	ISSUED FOR CONSTRUCTION
2	10/1/77	J. H. HARRIS	J. H. HARRIS	ISSUED FOR CONSTRUCTION
3	10/1/77	J. H. HARRIS	J. H. HARRIS	ISSUED FOR CONSTRUCTION
4	10/1/77	J. H. HARRIS	J. H. HARRIS	ISSUED FOR CONSTRUCTION
5	10/1/77	J. H. HARRIS	J. H. HARRIS	ISSUED FOR CONSTRUCTION
6	10/1/77	J. H. HARRIS	J. H. HARRIS	ISSUED FOR CONSTRUCTION
7	10/1/77	J. H. HARRIS	J. H. HARRIS	ISSUED FOR CONSTRUCTION
8	10/1/77	J. H. HARRIS	J. H. HARRIS	ISSUED FOR CONSTRUCTION
9	10/1/77	J. H. HARRIS	J. H. HARRIS	ISSUED FOR CONSTRUCTION
10	10/1/77	J. H. HARRIS	J. H. HARRIS	ISSUED FOR CONSTRUCTION

PDR

9202260461

