


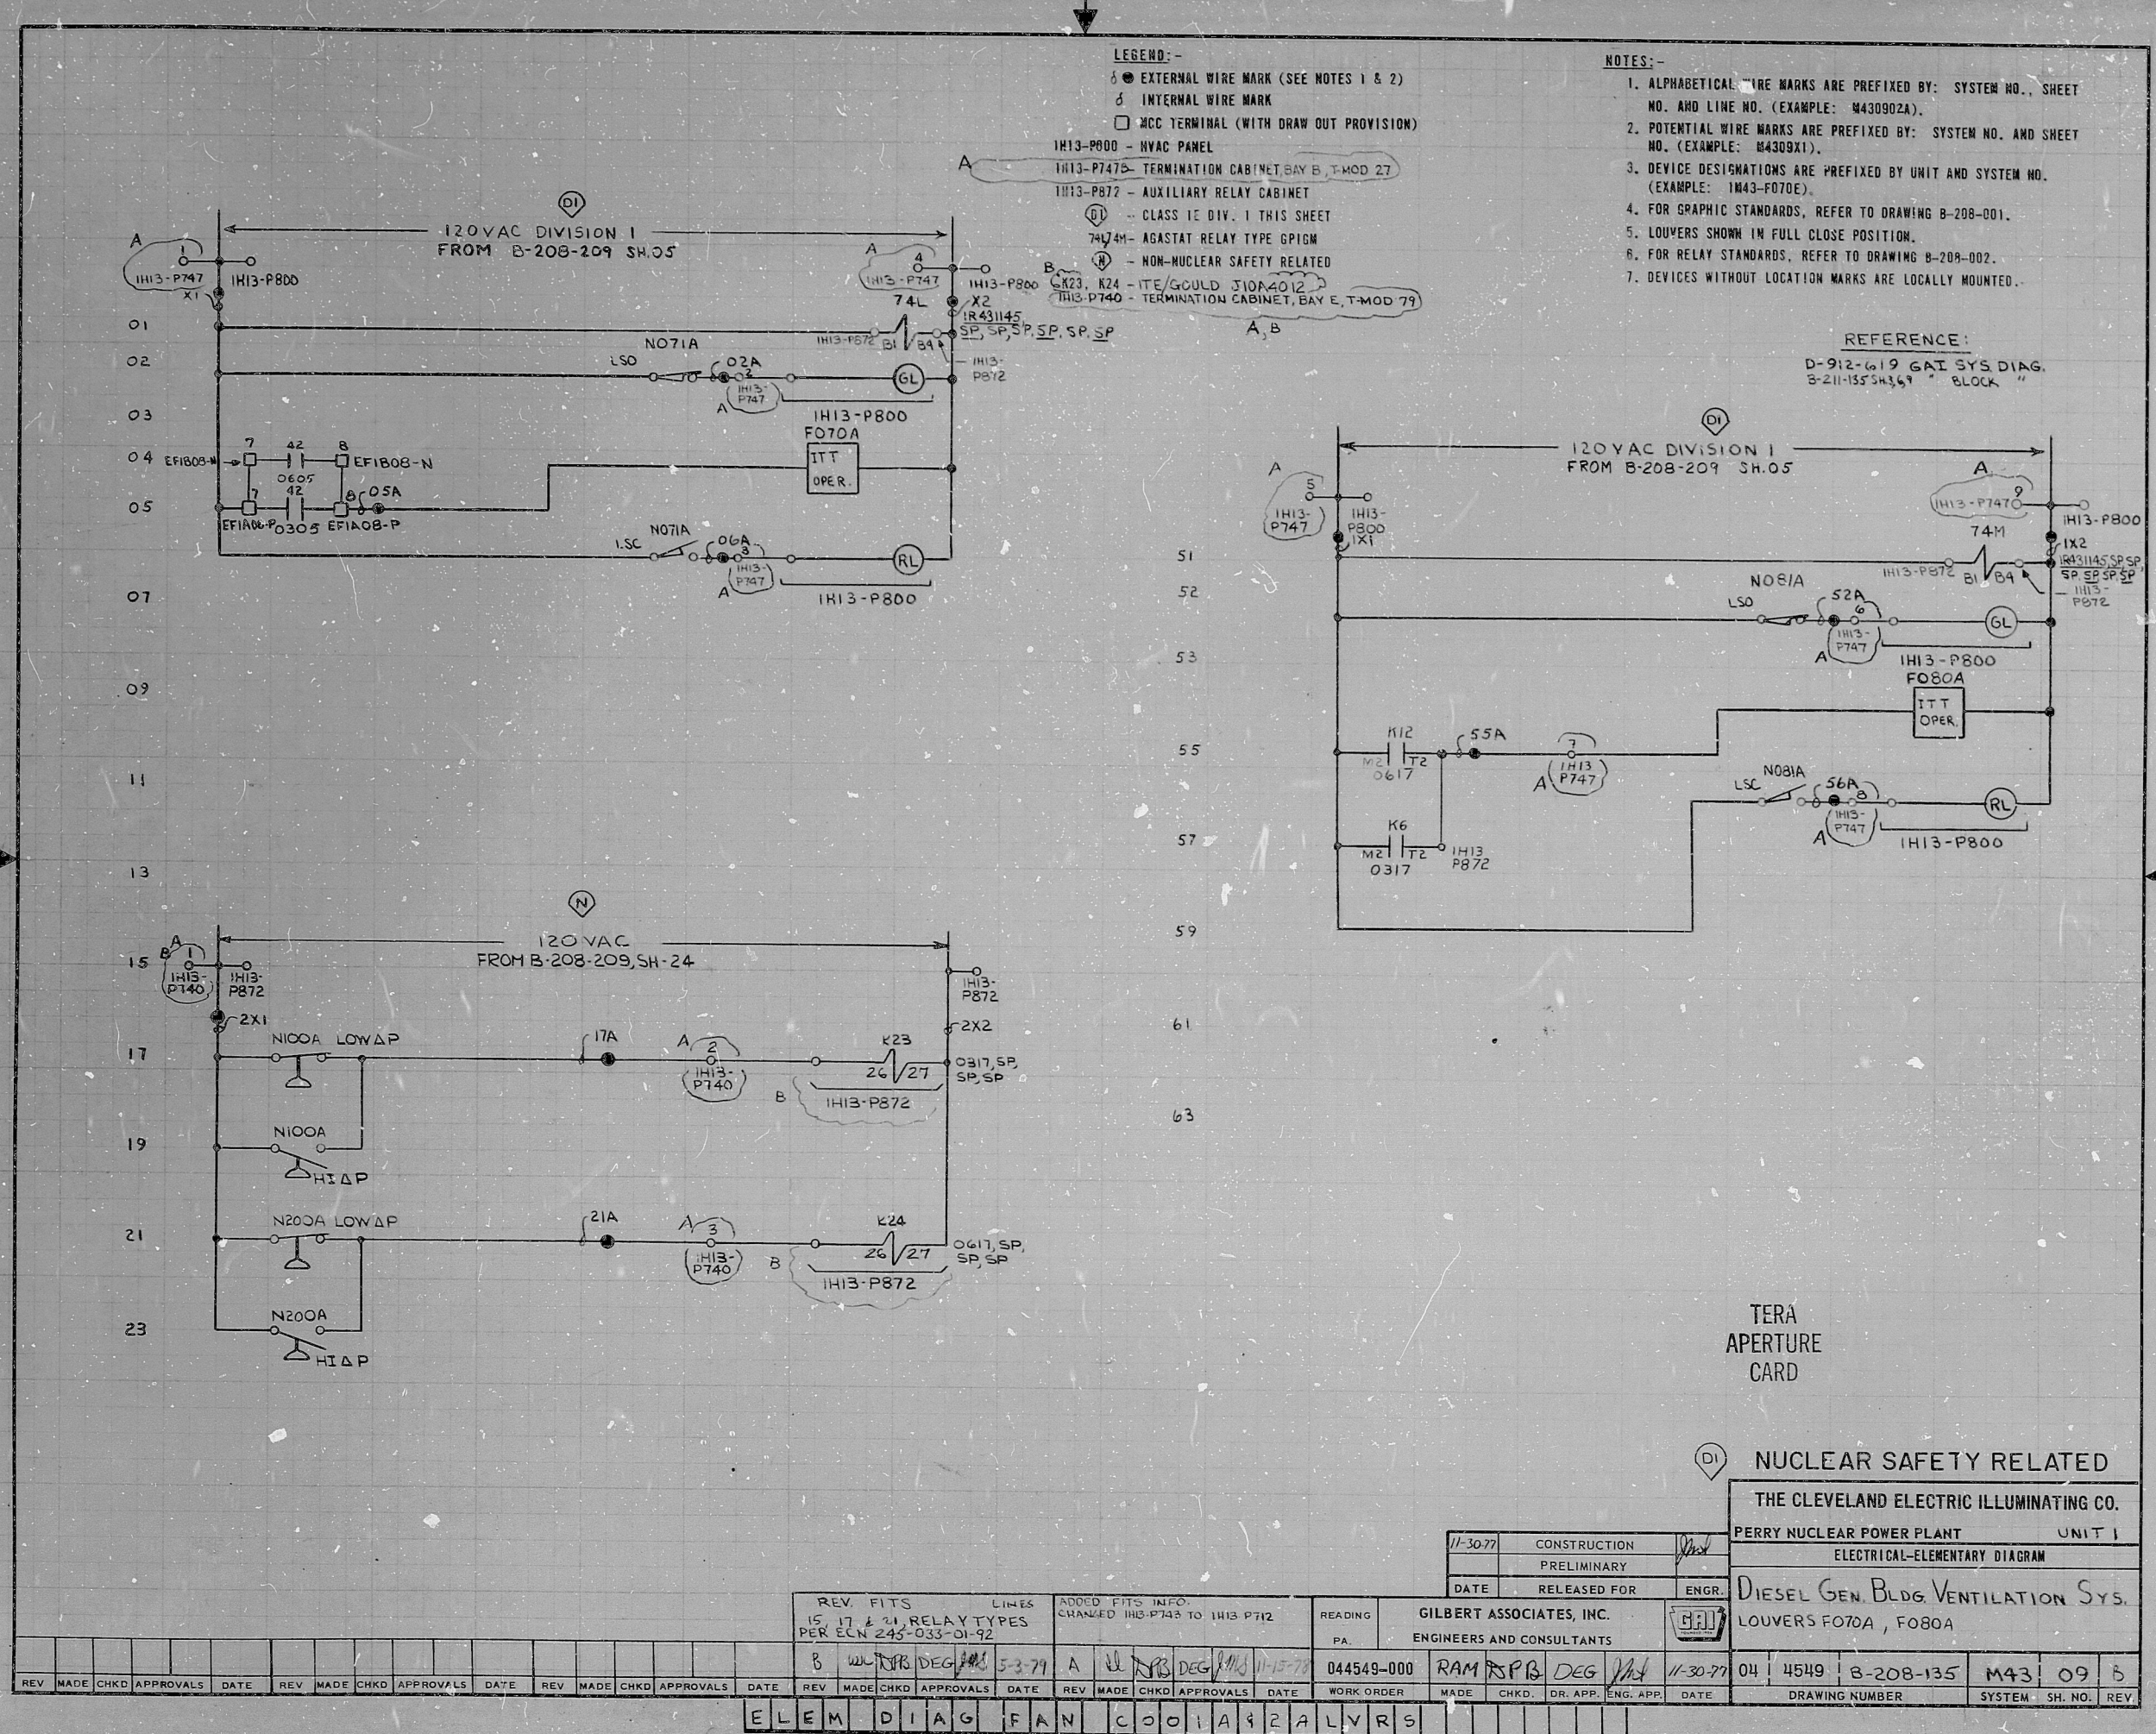

TERA
APERTURE
CARD

NUCLEAR SAFETY RELATED			
THE CLEVELAND ELECTRIC ILLUMINATING CO.			
PERRY NUCLEAR POWER PLANT		UNIT 1	
ELECTRICAL-ELEMENTARY DIAGRAM			
DIESEL GEN. BLDG. VENTILATION SYS.			
LOUVERS F070A, F080A			
11-30-77	CONSTRUCTION	11-30-77	04 4549 B-208-135 M43 09 5
	PRELIMINARY		
	RELEASED FOR	ENGR.	
GILBERT ASSOCIATES, INC.			
ENGINEERS AND CONSULTANTS			
044549-000	RAM	SPB	DEG
11-30-77	04	4549	B-208-135 M43 09 5
DRAWING NUMBER		SYSTEM SH. NO. REV.	

ELEM DIAG FAN COOLING RELAYS

R10S-PDR

8103230499

