


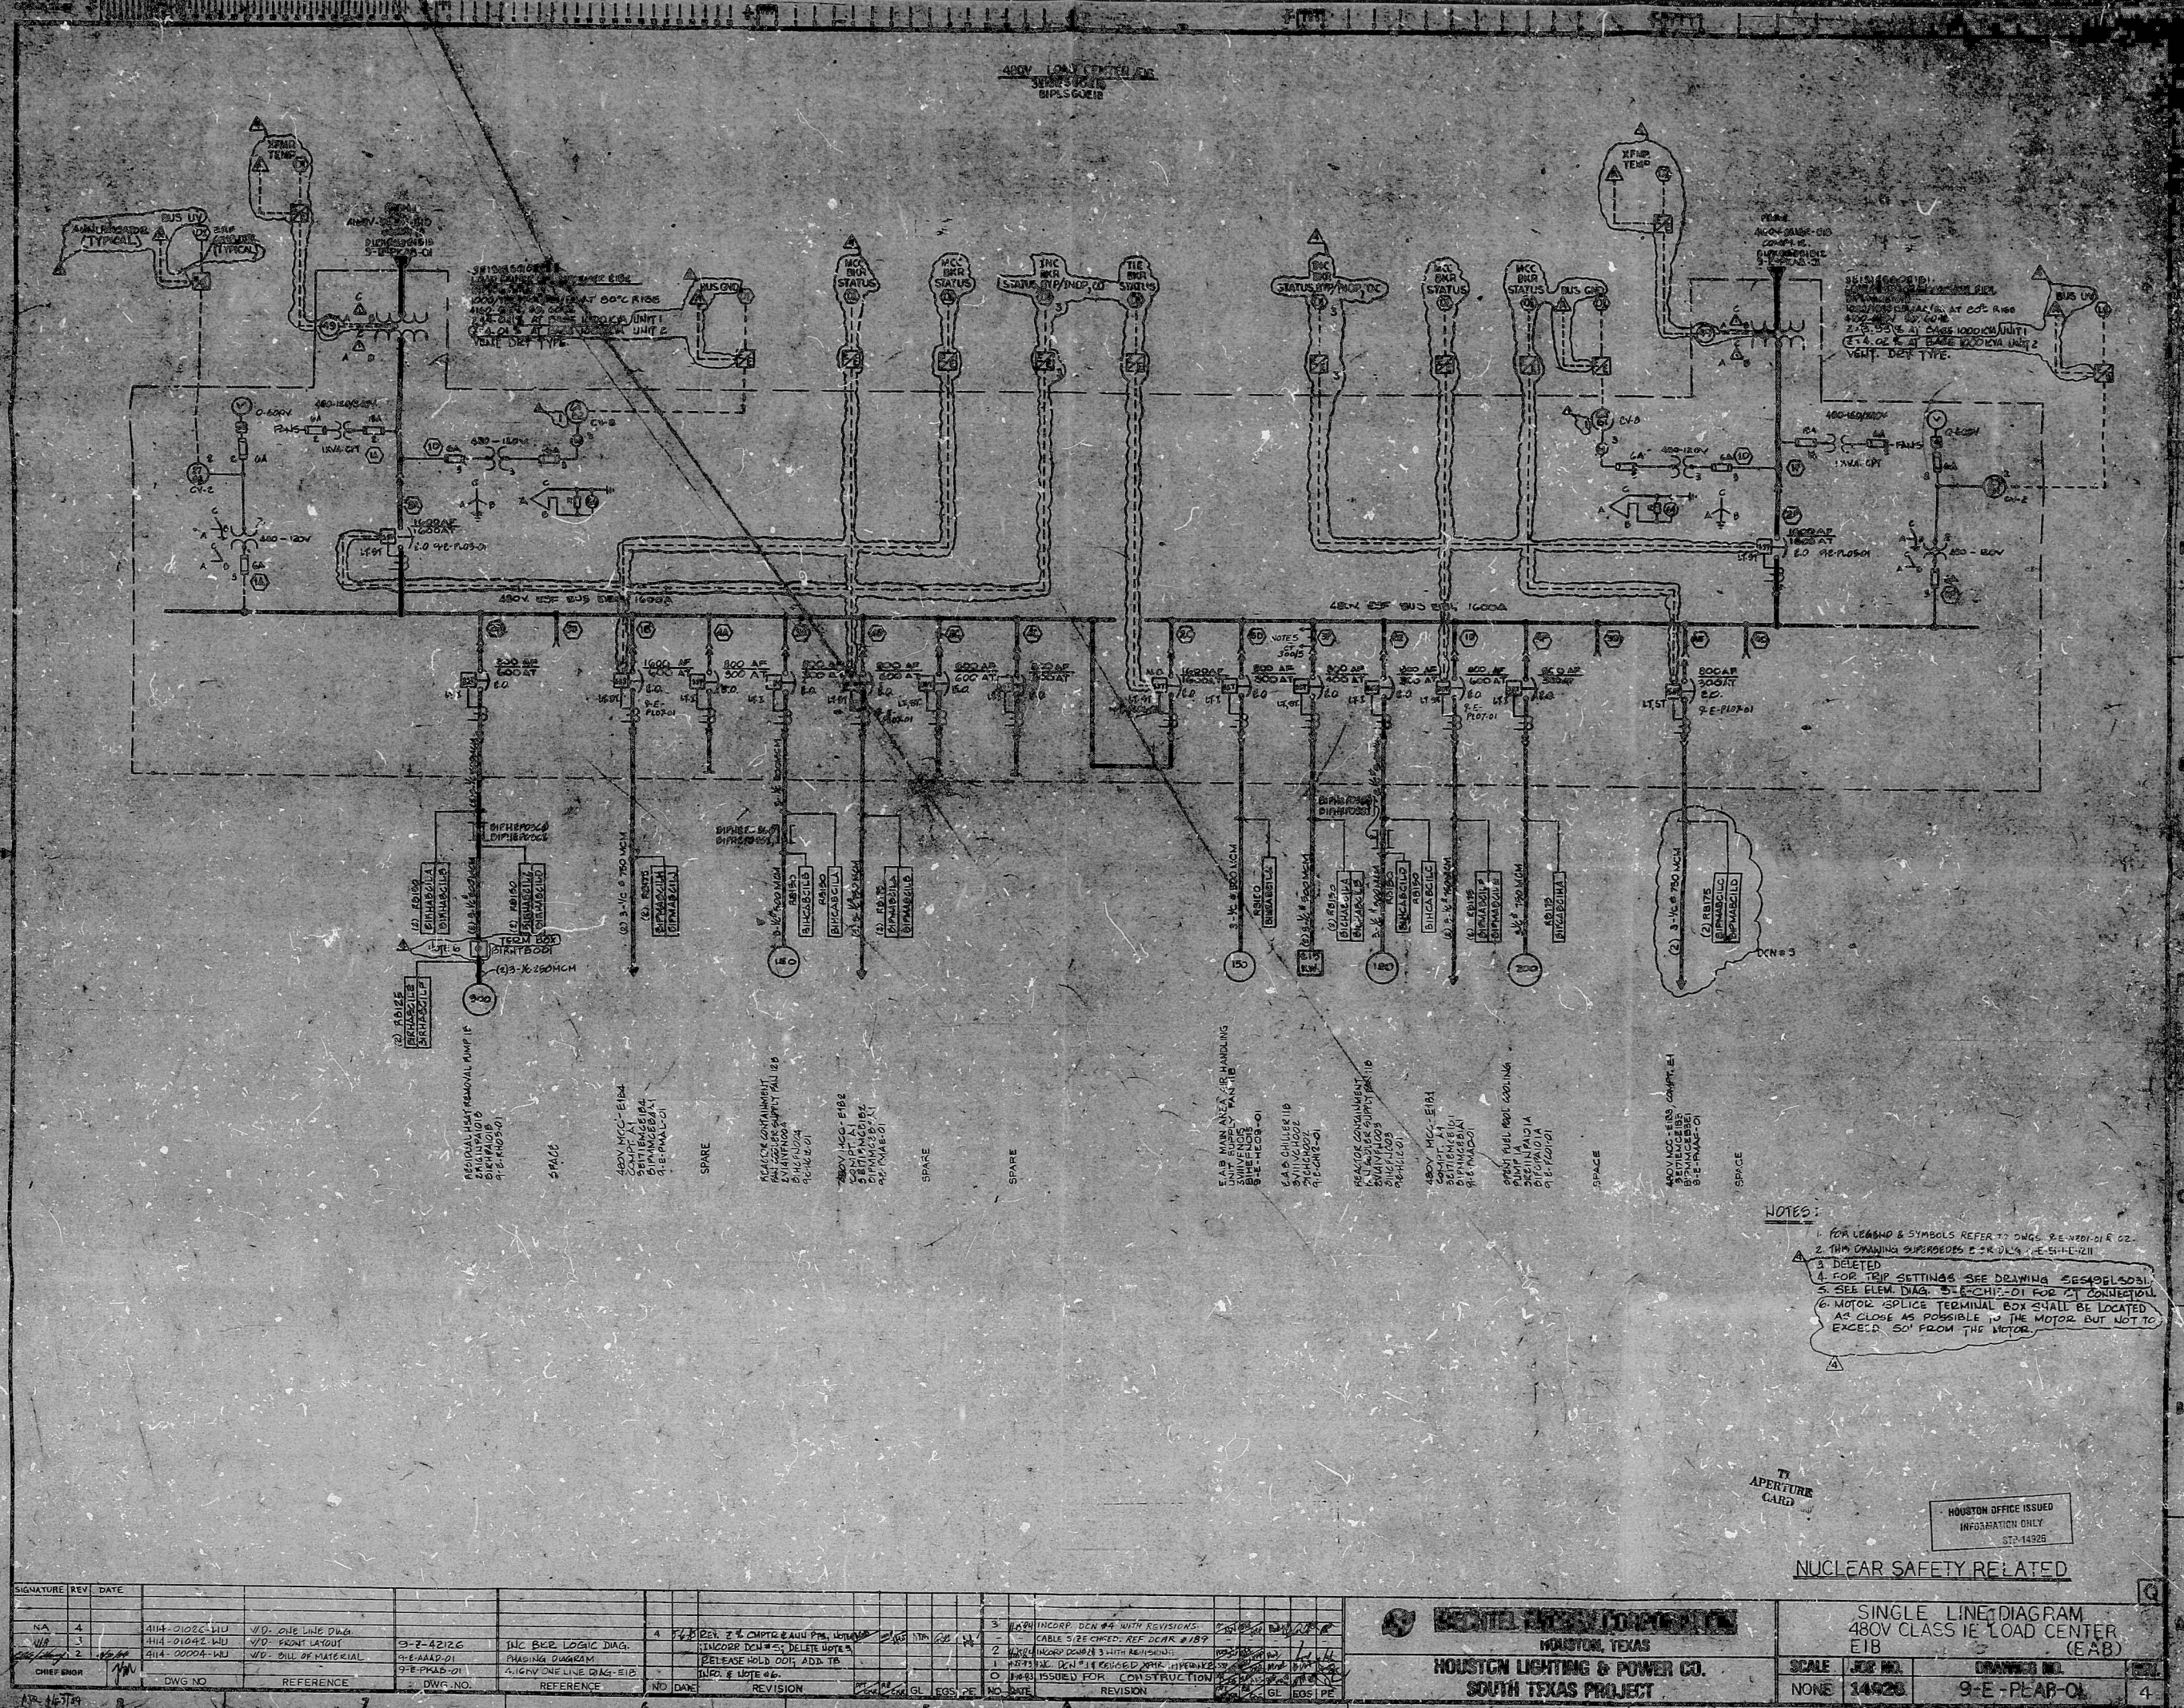

TI  
APERTURE  
CARD

HOUSTON OFFICE ISSUED  
INFORMATION ONLY  
STB 14926

NUCLEAR SAFETY RELATED

**HOUSTON LIGHTING & POWER CO.**  
**SOUTH TEXAS PROJECT**

SINGLE LINE DIAGRAM  
480V CLASS IE LOAD CENTER  
EIB (EAB)

|       |         |             |
|-------|---------|-------------|
| SCALE | JOB NO. | DRAWING NO. |
| NONE  | 14928   | 9-E-PEAR-OI |

PDR RIDS

8506040523

