



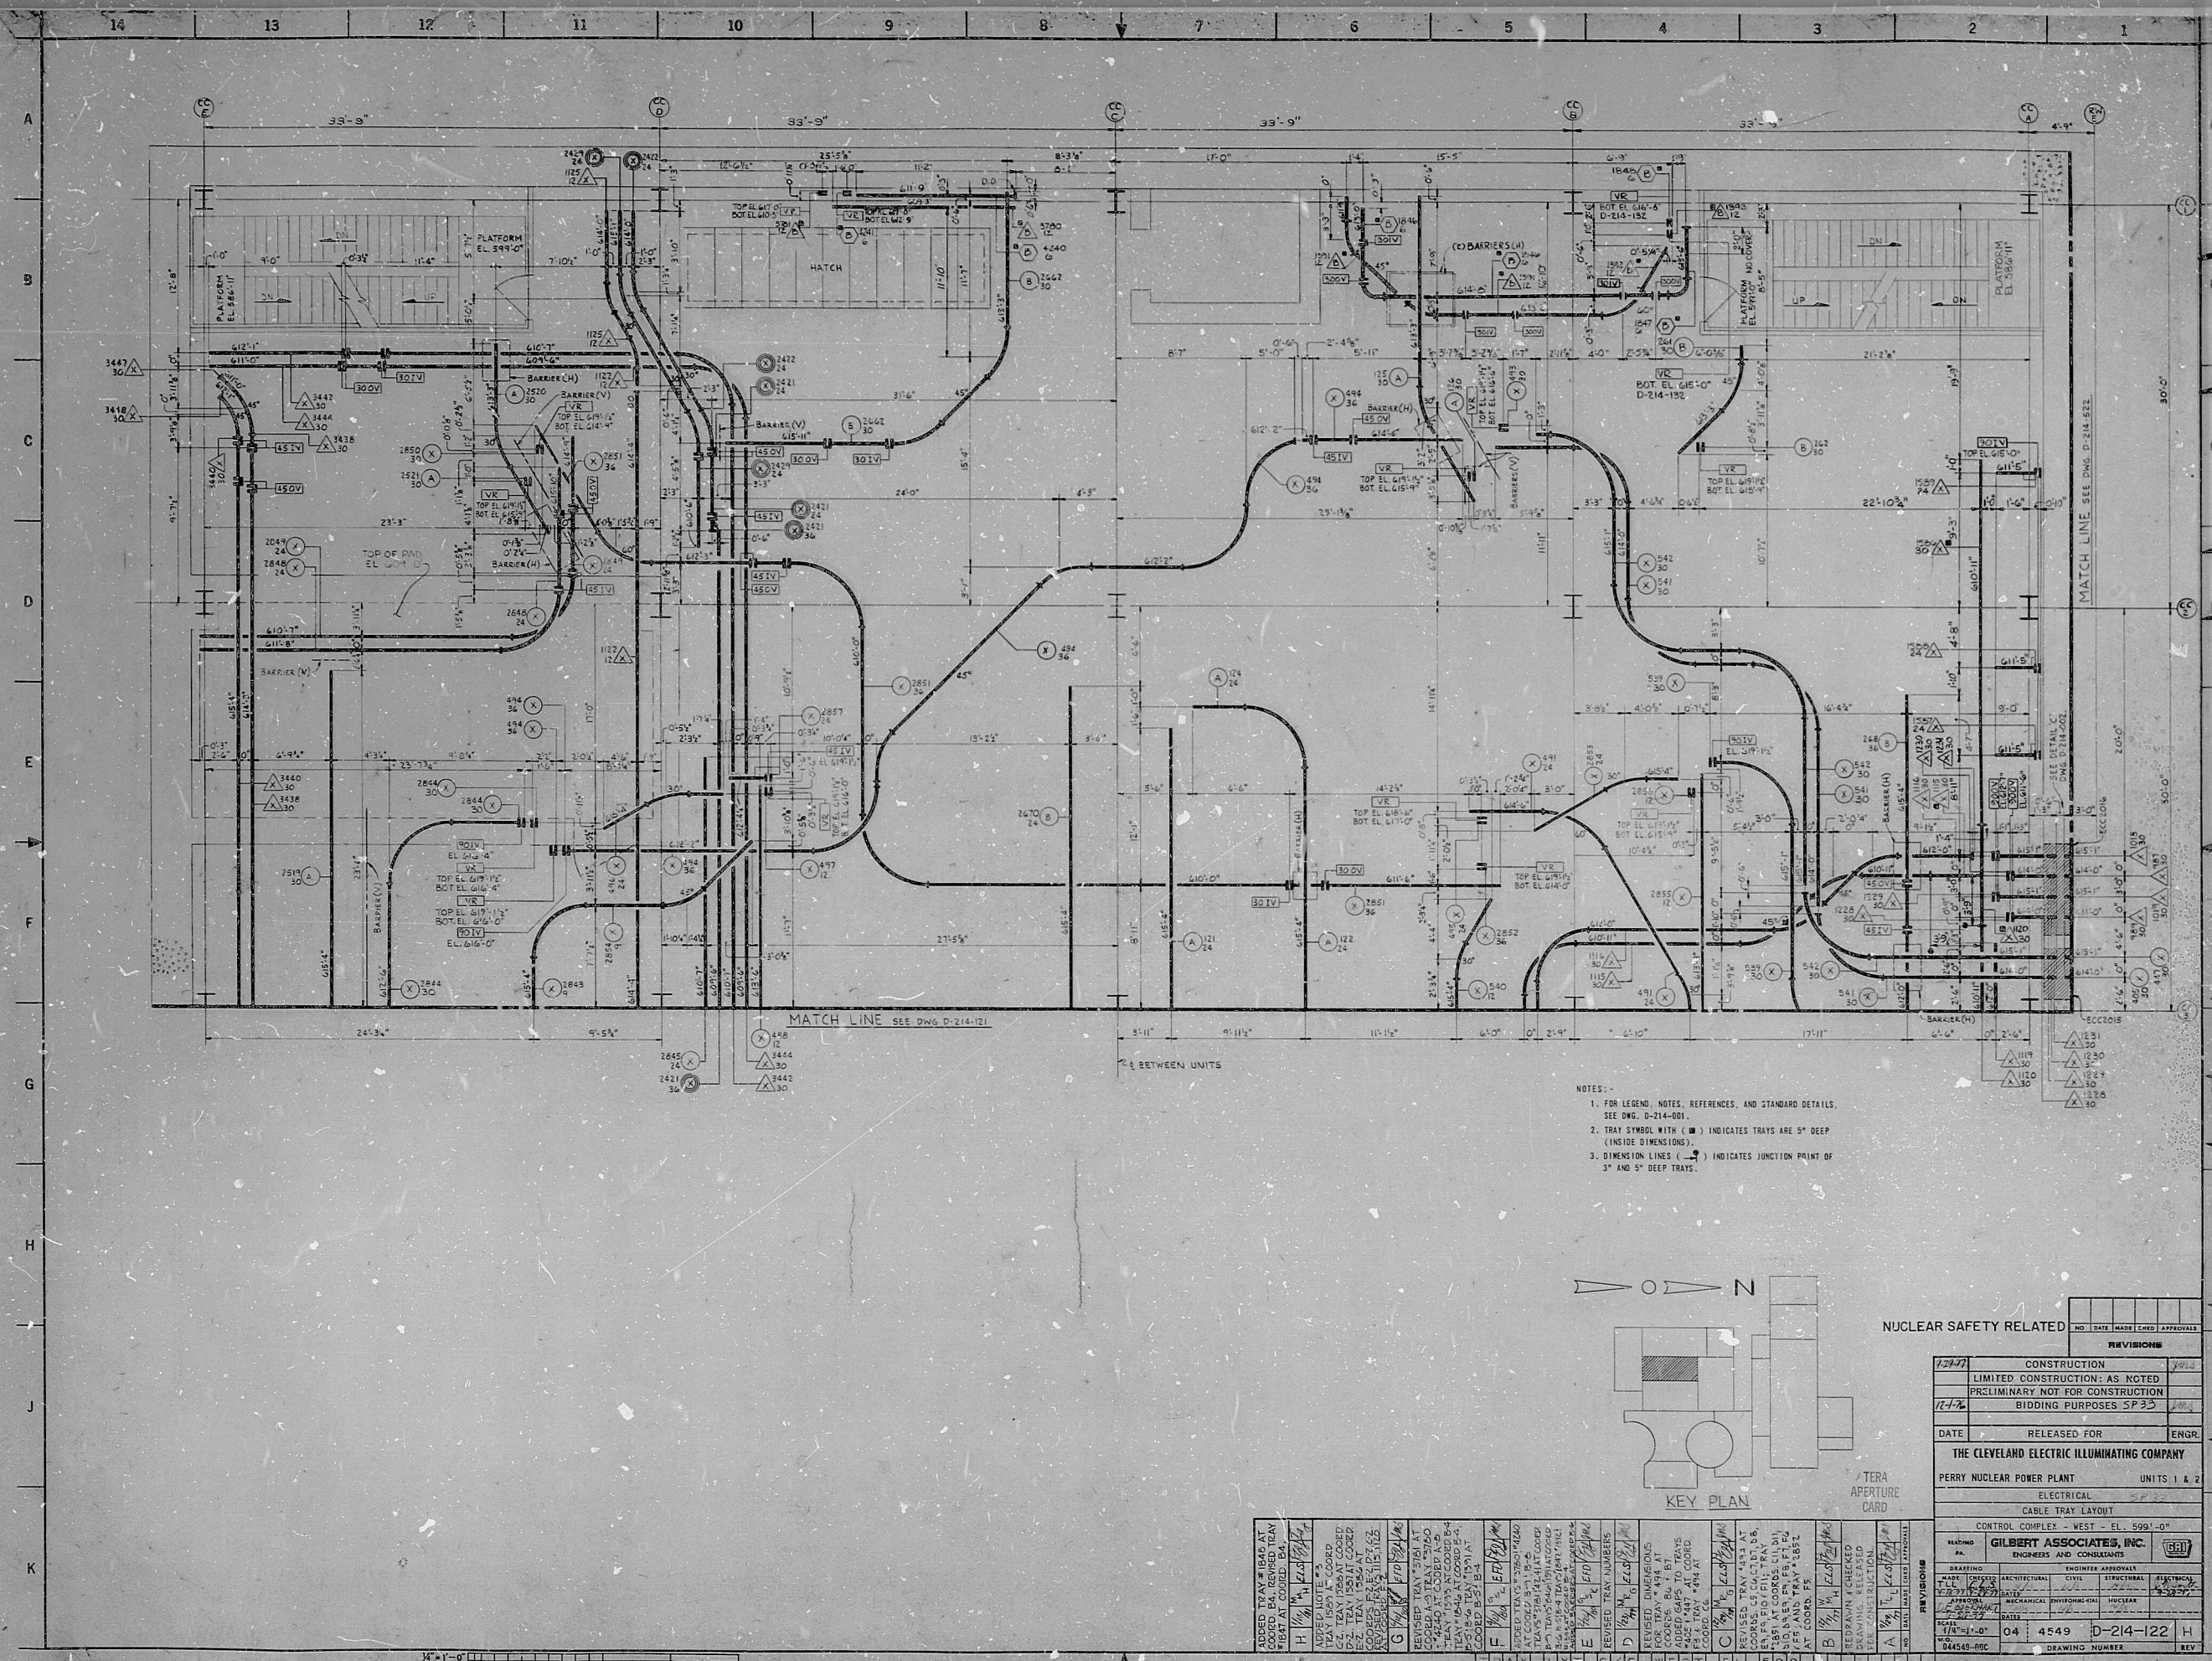

- NOTES:
1. FOR LEGEND, NOTES, REFERENCES, AND STANDARD DETAILS, SEE DWG. D-214-001.
 2. TRAY SYMBOL WITH (M) INDICATES TRAYS ARE 5" DEEP (UNLESS DIMENSIONS).
 3. DIMENSION LINES WITH (M) INDICATES JUNCTION POINT OF 3" AND 5" DEEP TRAYS.

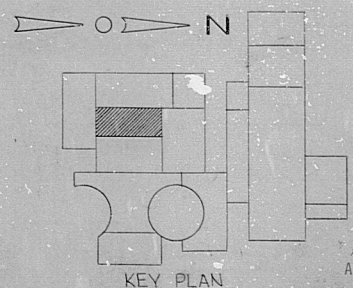

REVISIONS	
1	CONSTRUCTION
2	LIMITED CONSTRUCTION: AS NOTED
3	PRELIMINARY NOT FOR CONSTRUCTION
4	BIDDING PURPOSES SP35
DATE	RELEASED FOR
ENGR	
THE CLEVELAND ELECTRIC ILLUMINATING COMPANY	
PERRY NUCLEAR POWER PLANT	
UNITS 1 & 2	
ELECTRICAL	
CABLE TRAY LAYOUT	
CONTROL COMPLEX - WEST - EL. 599'-0"	
GILBERT ASSOCIATES, INC.	
ENGINEERS AND CONSULTANTS	
DATE	04/25/77
BY	04
CHKD	4549
APP'D	D-214-122
REV	H
DRAWING NUMBER	

NUCLEAR SAFETY RELATED	
NO	DATE
DATE	MADE
CARD	APPROVALS
REVISIONS	
1	CONSTRUCTION
2	LIMITED CONSTRUCTION: AS NOTED
3	PRELIMINARY NOT FOR CONSTRUCTION
4	BIDDING PURPOSES SP35
DATE	RELEASED FOR
ENGR	
THE CLEVELAND ELECTRIC ILLUMINATING COMPANY	
PERRY NUCLEAR POWER PLANT	
UNITS 1 & 2	
ELECTRICAL	
CABLE TRAY LAYOUT	
CONTROL COMPLEX - WEST - EL. 599'-0"	
GILBERT ASSOCIATES, INC.	
ENGINEERS AND CONSULTANTS	
DATE	04/25/77
BY	04
CHKD	4549
APP'D	D-214-122
REV	H
DRAWING NUMBER	

RIDS-2DR

8104010141

