


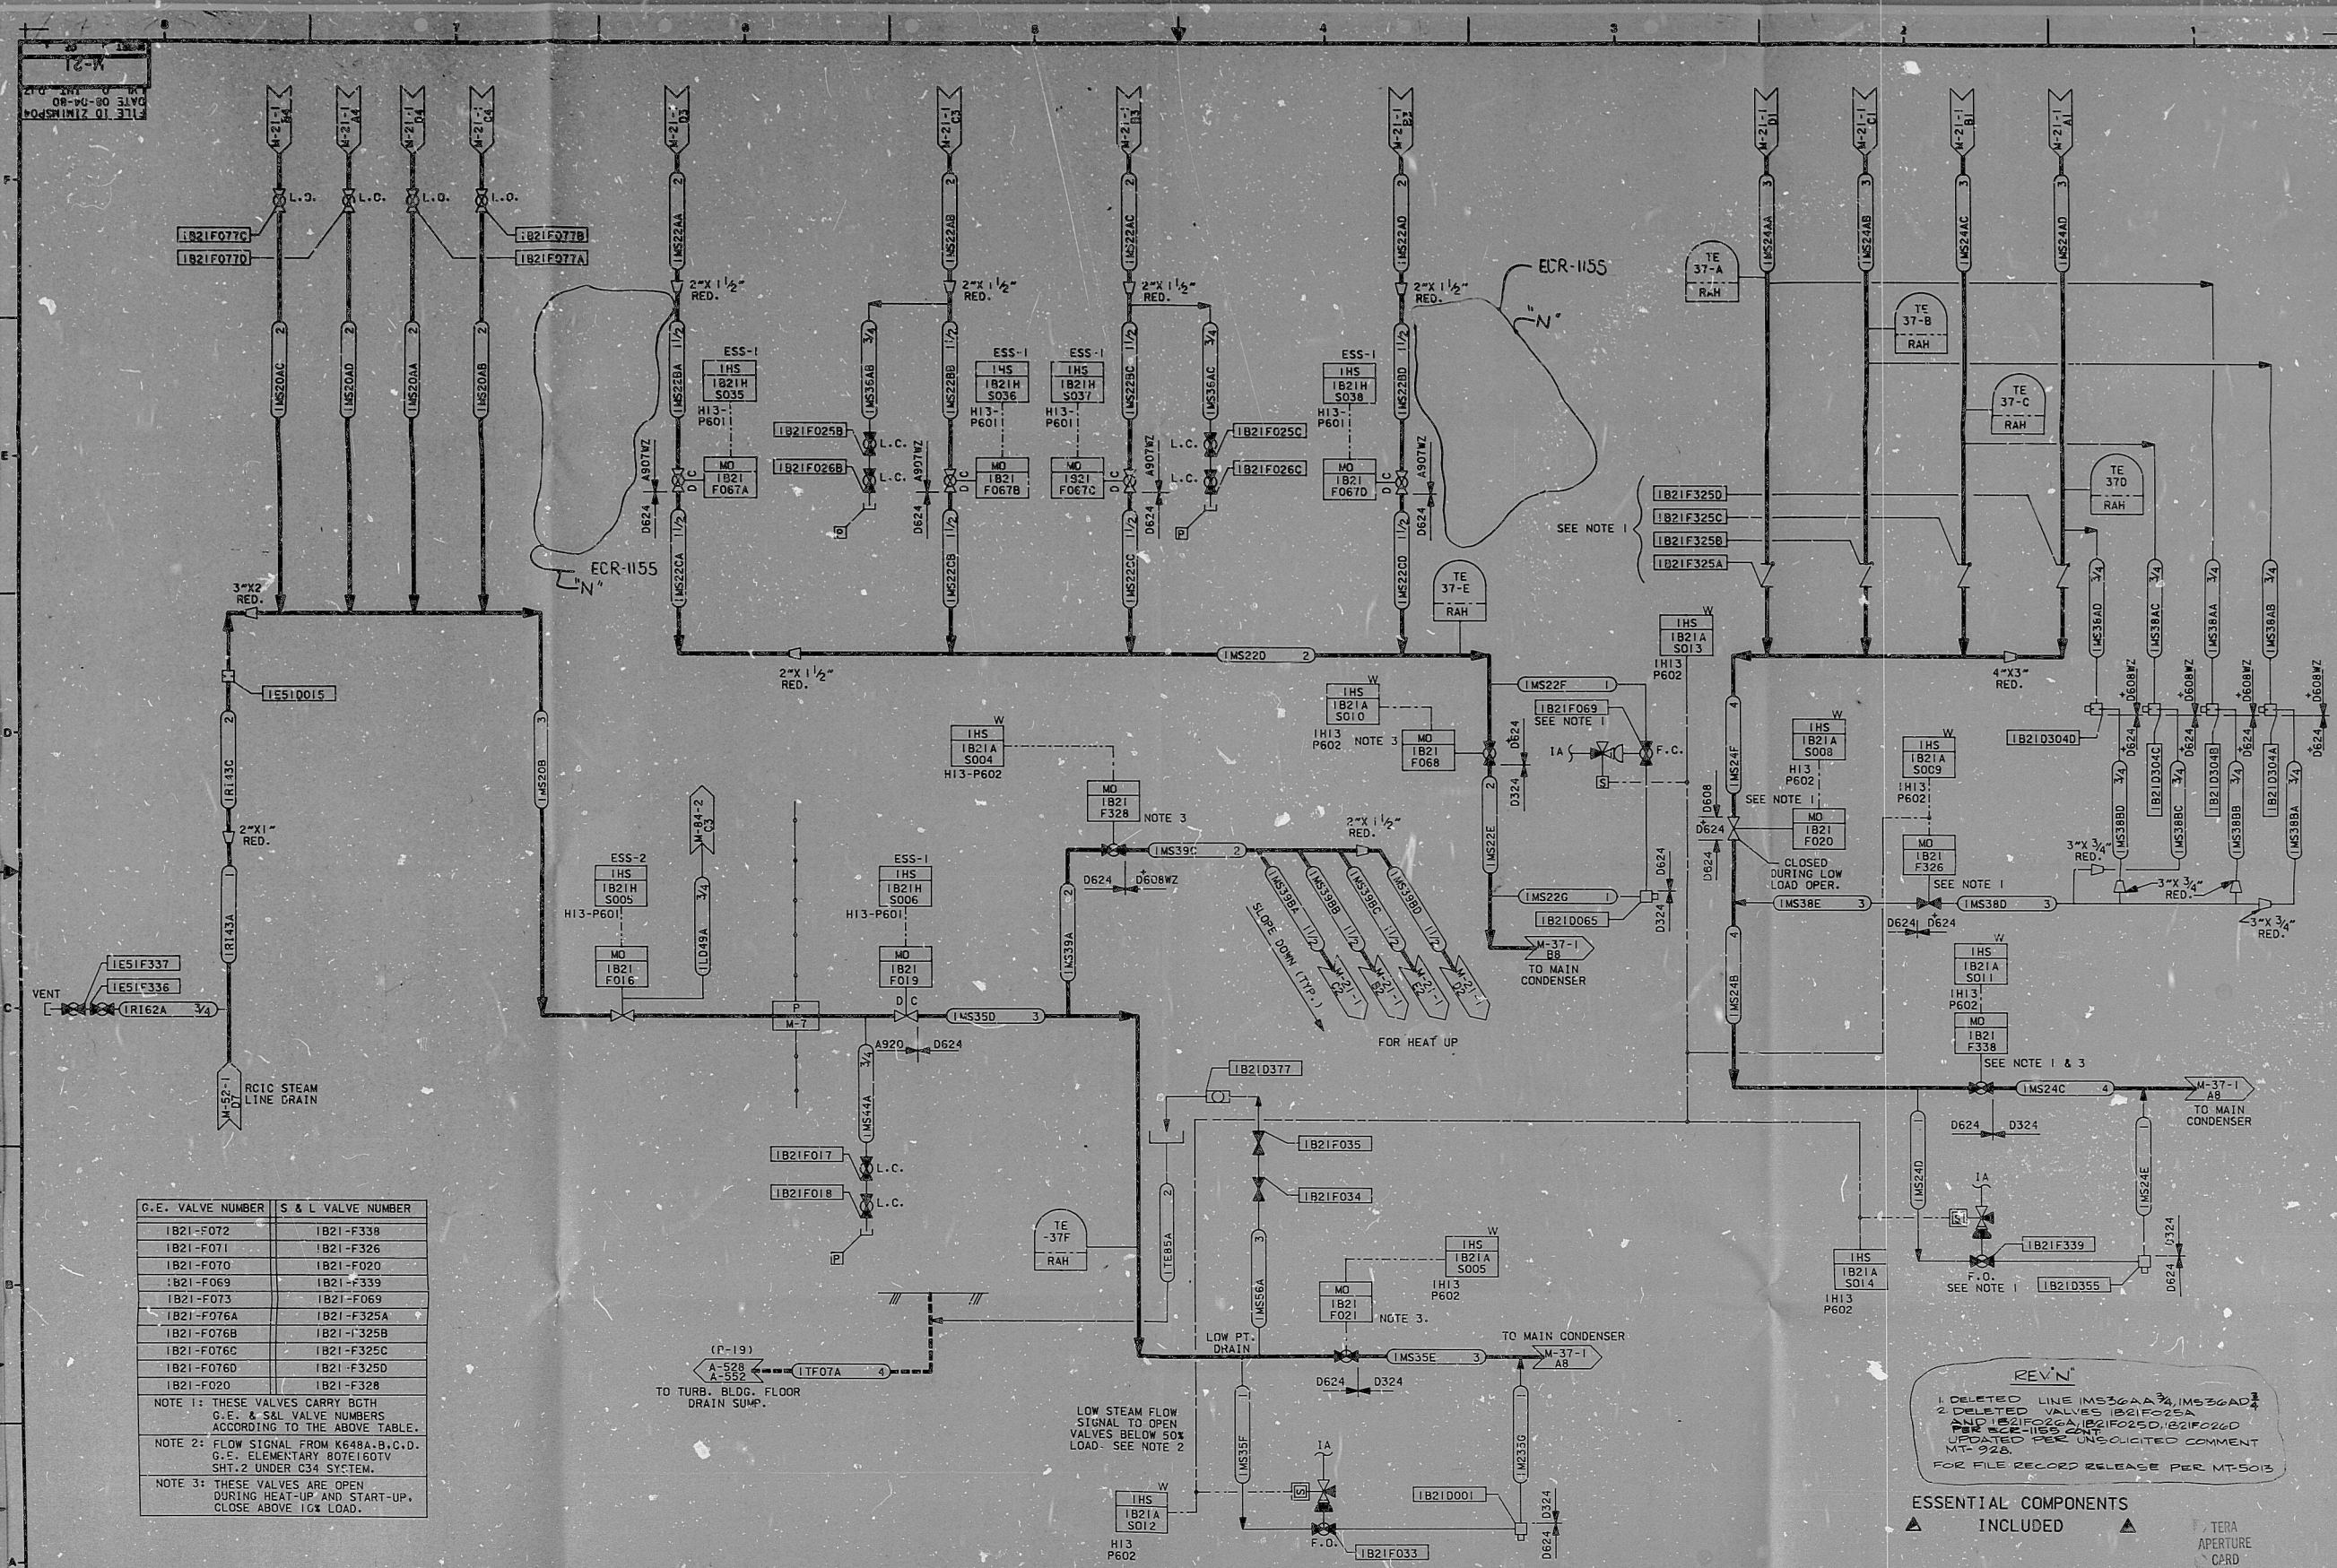

G.E. VALVE NUMBER	S & L VALVE NUMBER
IB21-F072	IB21-F338
IB21-F071	IB21-F326
IB21-F070	IB21-F020
IB21-F069	IB21-F339
IB21-F073	IB21-F069
IB21-F076A	IB21-F325A
IB21-F076B	IB21-F325B
IB21-F076C	IB21-F325C
IB21-F076D	IB21-F325D
IB21-F070	IB21-F328

NOTE 1: THESE VALVES CARRY BOTH G.E. & S&L VALVE NUMBERS ACCORDING TO THE ABOVE TABLE.

NOTE 2: FLOW SIGNAL FROM KE48A,B,C,D, G.E. ELEMENTARY ROTARY THT, 2 UNDER C34 SYSTEM.

NOTE 3: THESE VALVES ARE OPEN DURING HEAT-UP AND START-UP, CLOSE ABOVE 10% LOAD.

REV N

1. DELETED LINE MS36AA, MS36AD, MS36AE, MS36AF, MS36AG, MS36AH, MS36AI, MS36AJ, MS36AK, MS36AL, MS36AM, MS36AN, MS36AO, MS36AP, MS36AQ, MS36AR, MS36AS, MS36AT, MS36AU, MS36AV, MS36AW, MS36AX, MS36AY, MS36AZ, MS36BA, MS36BB, MS36BC, MS36BD, MS36BE, MS36BF, MS36BG, MS36BH, MS36BI, MS36BJ, MS36BK, MS36BL, MS36BM, MS36BN, MS36BO, MS36BP, MS36BQ, MS36BR, MS36BS, MS36BT, MS36BU, MS36BV, MS36BW, MS36BX, MS36BY, MS36BZ, MS36CA, MS36CB, MS36CC, MS36CD, MS36CE, MS36CF, MS36CG, MS36CH, MS36CI, MS36CJ, MS36CK, MS36CL, MS36CM, MS36CN, MS36CO, MS36CP, MS36CQ, MS36CR, MS36CS, MS36CT, MS36CU, MS36CV, MS36CW, MS36CX, MS36CY, MS36CZ, MS36DA, MS36DB, MS36DC, MS36DD, MS36DE, MS36DF, MS36DG, MS36DH, MS36DI, MS36DJ, MS36DK, MS36DL, MS36DM, MS36DN, MS36DO, MS36DP, MS36DQ, MS36DR, MS36DS, MS36DT, MS36DU, MS36DV, MS36DW, MS36DX, MS36DY, MS36DZ, MS36EA, MS36EB, MS36EC, MS36ED, MS36EE, MS36EF, MS36EG, MS36EH, MS36EI, MS36EJ, MS36EK, MS36EL, MS36EM, MS36EN, MS36EO, MS36EP, MS36EQ, MS36ER, MS36ES, MS36ET, MS36EU, MS36EV, MS36EW, MS36EX, MS36EY, MS36EZ, MS36FA, MS36FB, MS36FC, MS36FD, MS36FE, MS36FF, MS36FG, MS36FH, MS36FI, MS36FJ, MS36FK, MS36FL, MS36FM, MS36FN, MS36FO, MS36FP, MS36FQ, MS36FR, MS36FS, MS36FT, MS36FU, MS36FV, MS36FW, MS36FX, MS36FY, MS36FZ, MS36GA, MS36GB, MS36GC, MS36GD, MS36GE, MS36GF, MS36GG, MS36GH, MS36GI, MS36GJ, MS36GK, MS36GL, MS36GM, MS36GN, MS36GO, MS36GP, MS36GQ, MS36GR, MS36GS, MS36GT, MS36GU, MS36GV, MS36GW, MS36GX, MS36GY, MS36GZ, MS36HA, MS36HB, MS36HC, MS36HD, MS36HE, MS36HF, MS36HG, MS36HH, MS36HI, MS36HJ, MS36HK, MS36HL, MS36HM, MS36HN, MS36HO, MS36HP, MS36HQ, MS36HR, MS36HS, MS36HT, MS36HU, MS36HV, MS36HW, MS36HX, MS36HY, MS36HZ, MS36IA, MS36IB, MS36IC, MS36ID, MS36IE, MS36IF, MS36IG, MS36IH, MS36II, MS36IJ, MS36IK, MS36IL, MS36IM, MS36IN, MS36IO, MS36IP, MS36IQ, MS36IR, MS36IS, MS36IT, MS36IU, MS36IV, MS36IW, MS36IX, MS36IY, MS36IZ, MS36JA, MS36JB, MS36JC, MS36JD, MS36JE, MS36JF, MS36JG, MS36JH, MS36JI, MS36JJ, MS36JK, MS36JL, MS36JM, MS36JN, MS36JO, MS36JP, MS36JQ, MS36JR, MS36JS, MS36JT, MS36JU, MS36JV, MS36JW, MS36JX, MS36JY, MS36JZ, MS36KA, MS36KB, MS36KC, MS36KD, MS36KE, MS36KF, MS36KG, MS36KH, MS36KI, MS36KJ, MS36KL, MS36KM, MS36KN, MS36KO, MS36KP, MS36KQ, MS36KR, MS36KS, MS36KT, MS36KU, MS36KV, MS36KW, MS36KX, MS36KY, MS36KZ, MS36LA, MS36LB, MS36LC, MS36LD, MS36LE, MS36LF, MS36LG, MS36LH, MS36LI, MS36LJ, MS36LK, MS36LL, MS36LM, MS36LN, MS36LO, MS36LP, MS36LQ, MS36LR, MS36LS, MS36LT, MS36LU, MS36LV, MS36LW, MS36LX, MS36LY, MS36LZ, MS36MA, MS36MB, MS36MC, MS36MD, MS36ME, MS36MF, MS36MG, MS36MH, MS36MI, MS36MJ, MS36MK, MS36ML, MS36MN, MS36MO, MS36MP, MS36MQ, MS36MR, MS36MS, MS36MT, MS36MU, MS36MV, MS36MW, MS36MX, MS36MY, MS36MZ, MS36NA, MS36NB, MS36NC, MS36ND, MS36NE, MS36NF, MS36NG, MS36NH, MS36NI, MS36NJ, MS36NK, MS36NL, MS36NM, MS36NN, MS36NO, MS36NP, MS36NQ, MS36NR, MS36NS, MS36NT, MS36NU, MS36NV, MS36NW, MS36NX, MS36NY, MS36NZ, MS36OA, MS36OB, MS36OC, MS36OD, MS36OE, MS36OF, MS36OG, MS36OH, MS36OI, MS36OJ, MS36OK, MS36OL, MS36OM, MS36ON, MS36OO, MS36OP, MS36OQ, MS36OR, MS36OS, MS36OT, MS36OU, MS36OV, MS36OW, MS36OX, MS36OY, MS36OZ, MS36PA, MS36PB, MS36PC, MS36PD, MS36PE, MS36PF, MS36PG, MS36PH, MS36PI, MS36PJ, MS36PK, MS36PL, MS36PM, MS36PN, MS36PO, MS36PP, MS36PQ, MS36PR, MS36PS, MS36PT, MS36PU, MS36PV, MS36PW, MS36PX, MS36PY, MS36PZ, MS36QA, MS36QB, MS36QC, MS36QD, MS36QE, MS36QF, MS36QG, MS36QH, MS36QI, MS36QJ, MS36QK, MS36QL, MS36QM, MS36QN, MS36QO, MS36QP, MS36QQ, MS36QR, MS36QS, MS36QT, MS36QU, MS36QV, MS36QW, MS36QX, MS36QY, MS36QZ, MS36RA, MS36RB, MS36RC, MS36RD, MS36RE, MS36RF, MS36RG, MS36RH, MS36RI, MS36RJ, MS36RK, MS36RL, MS36RM, MS36RN, MS36RO, MS36RP, MS36RQ, MS36RR, MS36RS, MS36RT, MS36RU, MS36RV, MS36RW, MS36RX, MS36RY, MS36RZ, MS36SA, MS36SB, MS36SC, MS36SD, MS36SE, MS36SF, MS36SG, MS36SH, MS36SI, MS36SJ, MS36SK, MS36SL, MS36SM, MS36SN, MS36SO, MS36SP, MS36SQ, MS36SR, MS36SS, MS36ST, MS36SU, MS36SV, MS36SW, MS36SX, MS36SY, MS36SZ, MS36TA, MS36TB, MS36TC, MS36TD, MS36TE, MS36TF, MS36TG, MS36TH, MS36TI, MS36TJ, MS36TK, MS36TL, MS36TM, MS36TN, MS36TO, MS36TP, MS36TQ, MS36TR, MS36TS, MS36TT, MS36TU, MS36TV, MS36TW, MS36TX, MS36TY, MS36TZ, MS36UA, MS36UB, MS36UC, MS36UD, MS36UE, MS36UF, MS36UG, MS36UH, MS36UI, MS36UJ, MS36UK, MS36UL, MS36UM, MS36UN, MS36UO, MS36UP, MS36UQ, MS36UR, MS36US, MS36UT, MS36UU, MS36UV, MS36UW, MS36UX, MS36UY, MS36UZ, MS36VA, MS36VB, MS36VC, MS36VD, MS36VE, MS36VF, MS36VG, MS36VH, MS36VI, MS36VJ, MS36VK, MS36VL, MS36VM, MS36VN, MS36VO, MS36VP, MS36VQ, MS36VR, MS36VS, MS36VT, MS36VU, MS36VV, MS36VW, MS36VX, MS36VY, MS36VZ, MS36WA, MS36WB, MS36WC, MS36WD, MS36WE, MS36WF, MS36WG, MS36WH, MS36WI, MS36WJ, MS36WK, MS36WL, MS36WM, MS36WN, MS36WO, MS36WP, MS36WQ, MS36WR, MS36WS, MS36WT, MS36WU, MS36WV, MS36WW, MS36WX, MS36WY, MS36WZ, MS36XA, MS36XB, MS36XC, MS36XD, MS36XE, MS36XF, MS36XG, MS36XH, MS36XI, MS36XJ, MS36XK, MS36XL, MS36XM, MS36XN, MS36XO, MS36XP, MS36XQ, MS36XR, MS36XS, MS36XT, MS36XU, MS36XV, MS36XW, MS36XX, MS36XY, MS36XZ, MS36YA, MS36YB, MS36YC, MS36YD, MS36YE, MS36YF, MS36YG, MS36YH, MS36YI, MS36YJ, MS36YK, MS36YL, MS36YM, MS36YN, MS36YO, MS36YP, MS36YQ, MS36YR, MS36YS, MS36YT, MS36YU, MS36YV, MS36YW, MS36YX, MS36YY, MS36YZ, MS36ZA, MS36ZB, MS36ZC, MS36ZD, MS36ZE, MS36ZF, MS36ZG, MS36ZH, MS36ZI, MS36ZJ, MS36ZK, MS36ZL, MS36ZM, MS36ZN, MS36ZO, MS36ZP, MS36ZQ, MS36ZR, MS36ZS, MS36ZT, MS36ZU, MS36ZV, MS36ZW, MS36ZX, MS36ZY, MS36ZZ.

ESSENTIAL COMPONENTS INCLUDED

TERA APERTURE CARD

REV.	DATE	FIELD	PREPARED	REVIEWED	APPROVED	DRAWING RELEASE RECORD	PURPOSE	FILM	REV.	DATE	FIELD	PREPARED	REVIEWED	APPROVED	DRAWING RELEASE RECORD	PURPOSE	FILM
N	10-30-80		A. P. ...				REDRAWN, SEE NOTE										

SCALE: NONE

PROJECT NUMBER: 4130-00

P & ID MAIN STEAM (MS)

WM. H. ZIMMER NUCLEAR POWER STATION UNIT 1

THE CINCINNATI GAS & ELECTRIC CO.

COLUMBUS & SOUTHERN OHIO ELECTRIC CO.

THE DAYTON POWER & LIGHT CO.

DRAWING NO. M-21

REV. N

SHEET 4 OF 4

RIDS-RDR

8104010289

