


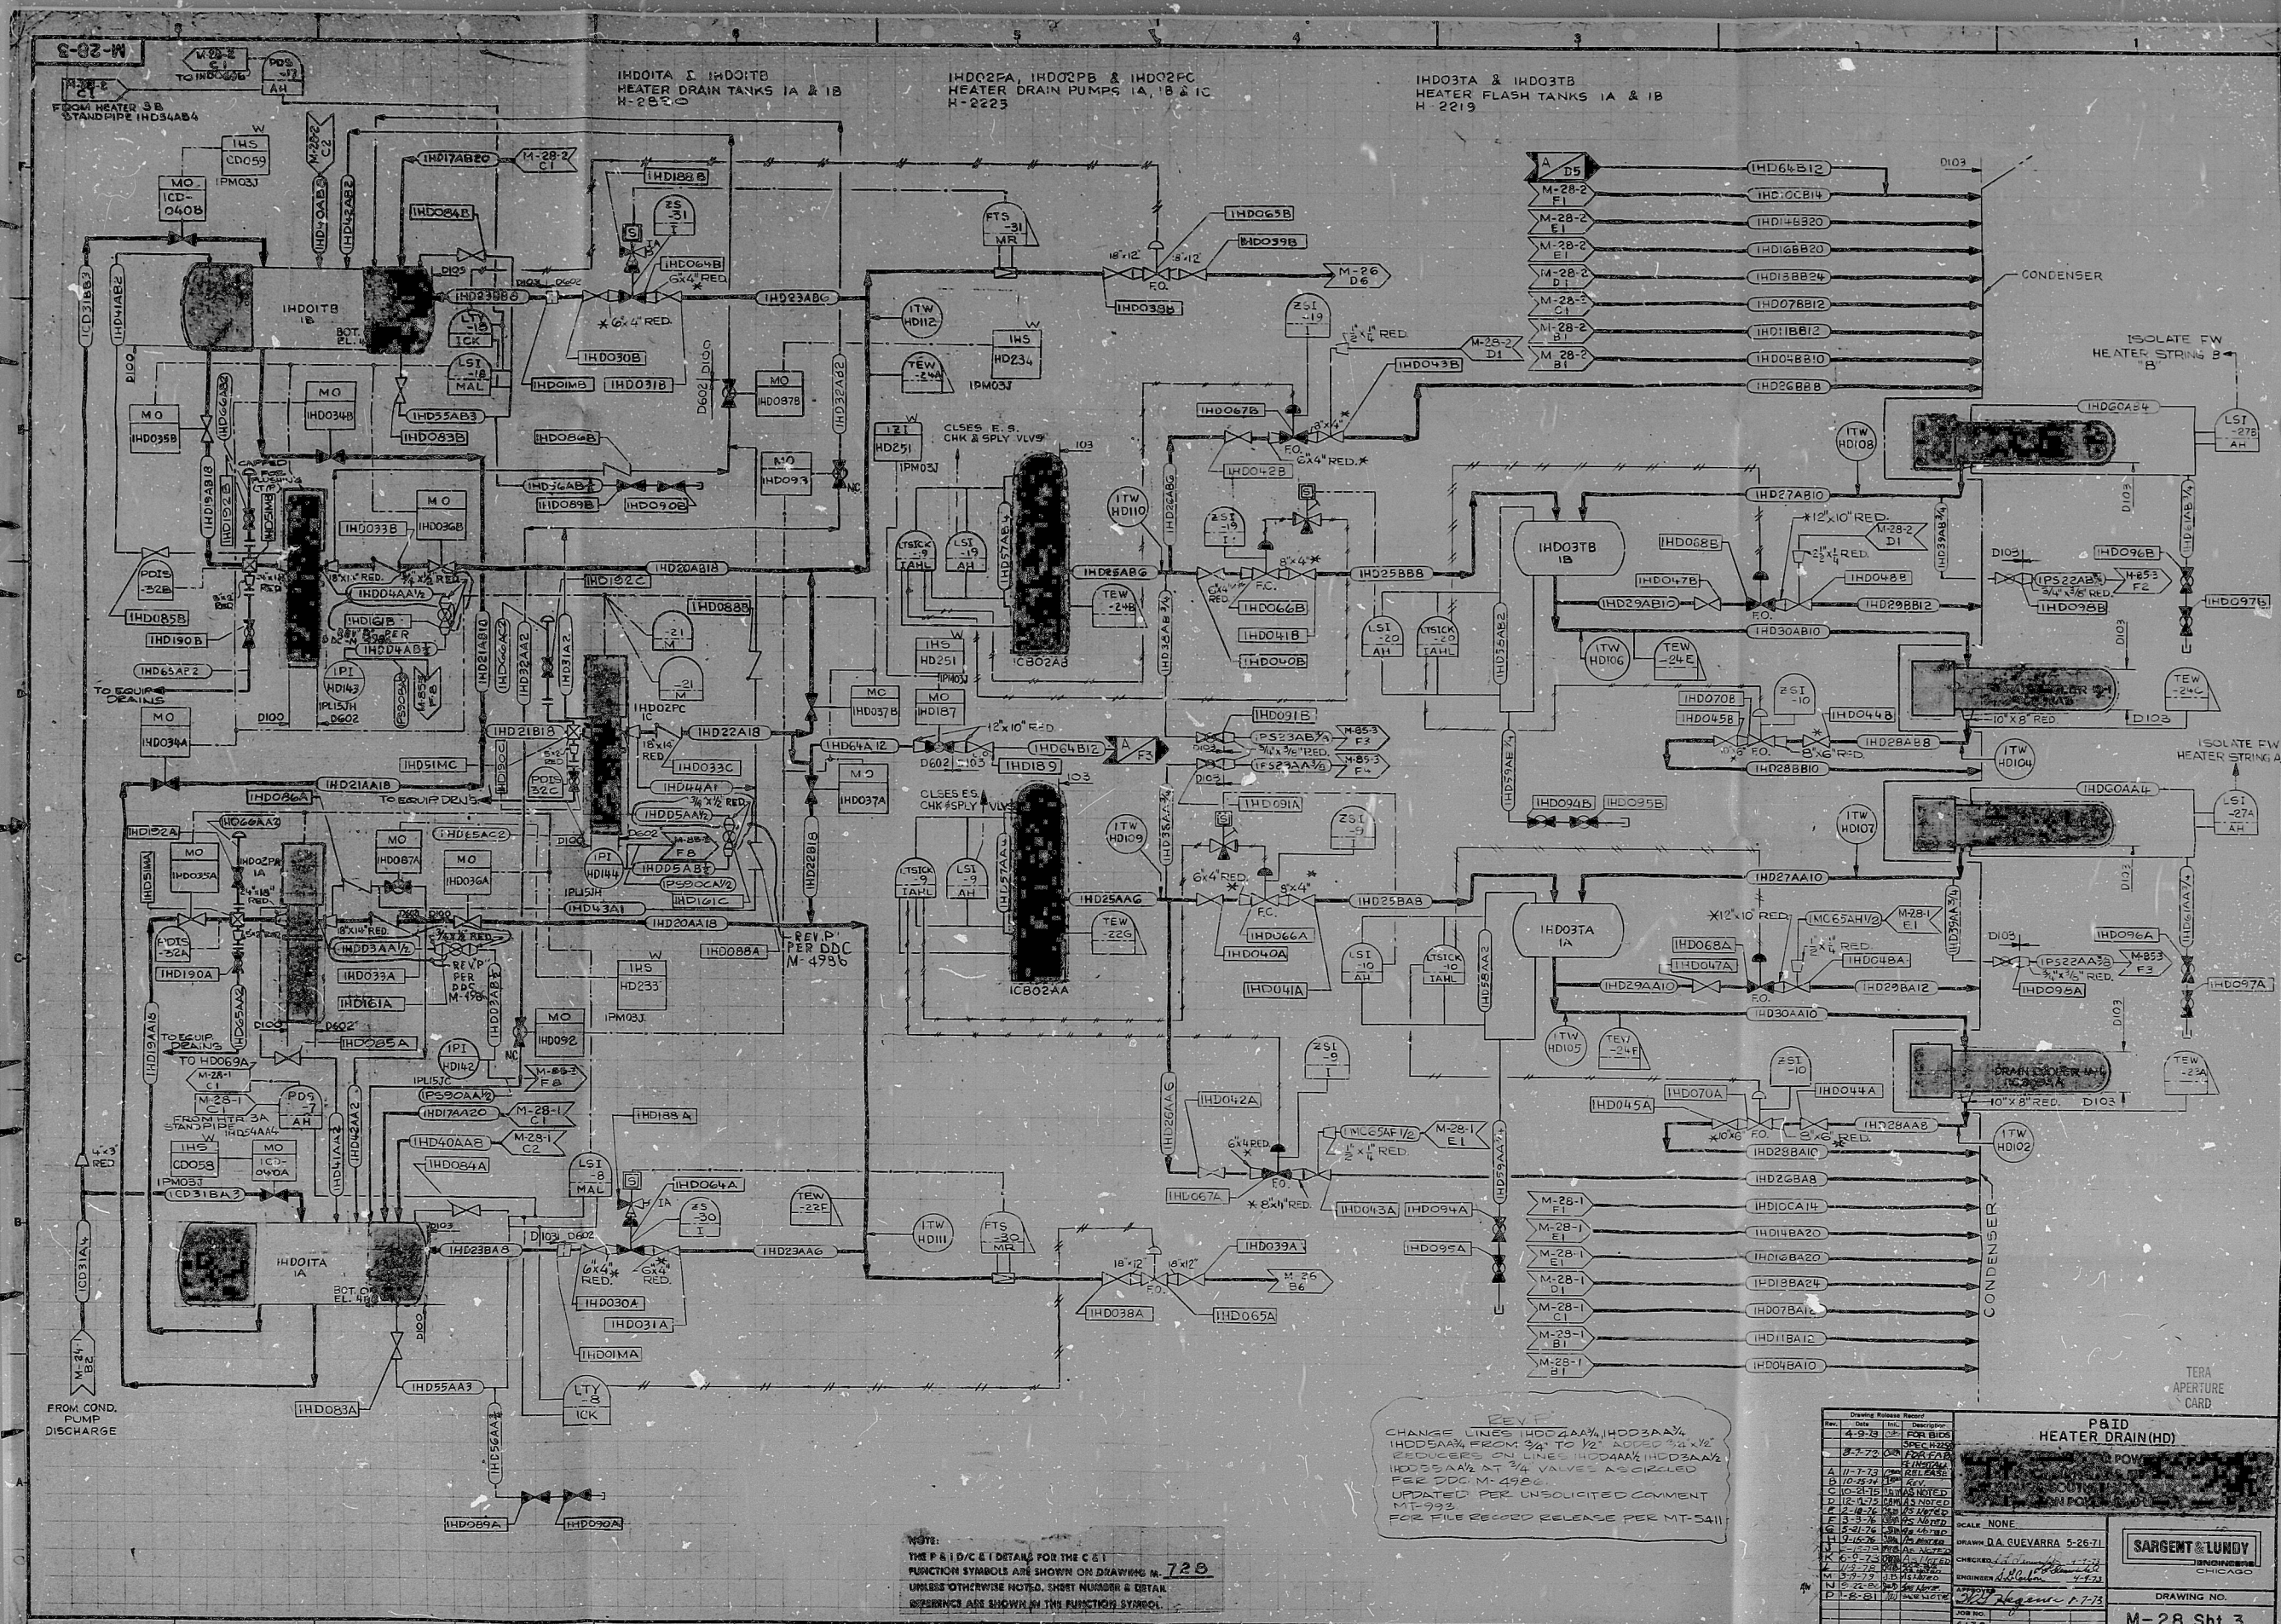

NOTE:
THE P&ID/C&I DETAILS FOR THE C&I
FUNCTION SYMBOLS ARE SHOWN ON DRAWING M-22-3
UNLESS OTHERWISE NOTED, SHORT NUMBER & DETAIL
REFERENCE ARE SHOWN IN THE FUNCTION SYMBOL.

CHANGE LINES IHD02AA, IHD03AA, IHD05AA, FROM 3/4" TO 1/2" ADEQ 3/4" X 1/2"
FLOWERS ON LINE IHD02AA, IHD03AA, IHD05AA
AT 3/4" VALVE ASSIGNED
PER PDC M-498
UPDATED PER UNLOCATED COMMENT
FOR FILE RECORD RELEASE PER MT-5411

Drawing Release Record	
Rev.	Date
1	4-9-73
2	8-7-73
3	11-7-73
4	10-5-74
5	10-2-75
6	12-2-75
7	2-18-76
8	3-3-76
9	5-21-76
10	10-2-76
11	10-2-76
12	10-2-76
13	10-2-76
14	10-2-76
15	10-2-76
16	10-2-76
17	10-2-76
18	10-2-76
19	10-2-76
20	10-2-76

PAID
HEATER DRAIN (HD)
SARGENT & LUNDY
DRAWING NO.
M-28 Sht. 3
M-28-3

RIDS-PDR

6104010295

