


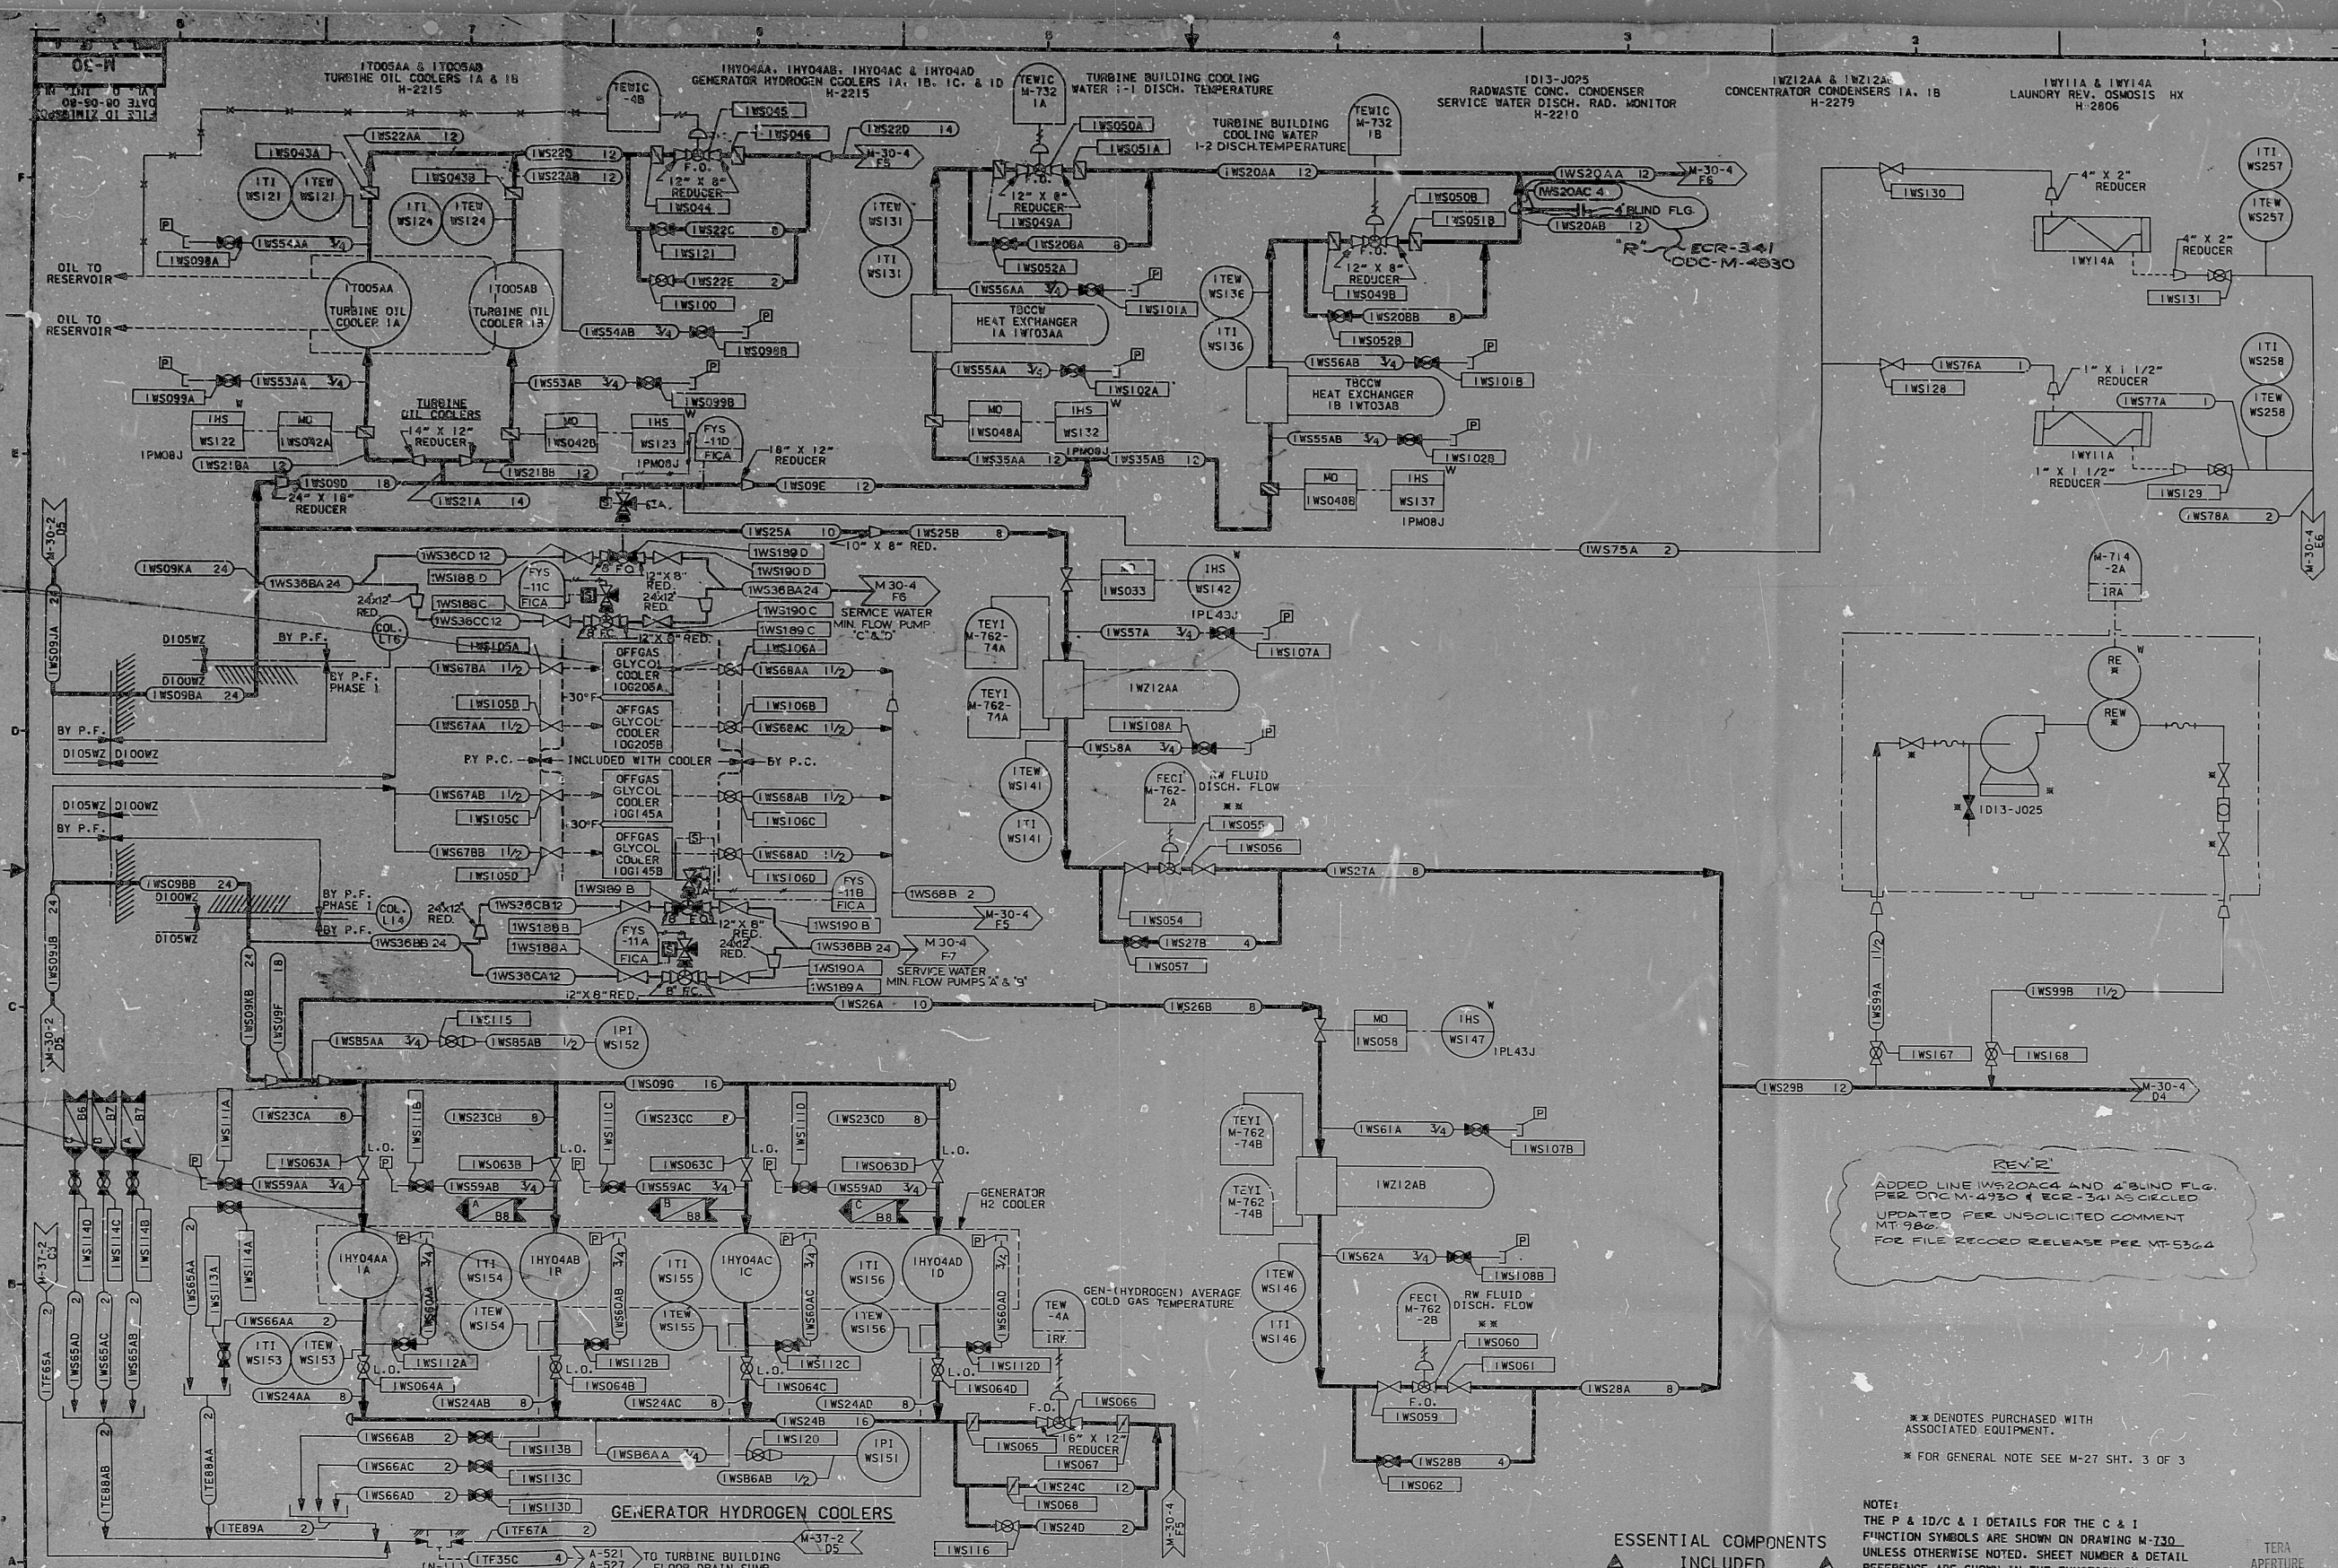

REV. 2
ADDED LINE IWS20AC4 AND 4" BLIND FLG. PER DDC-M-4930 & ECR-341 AS CIRCLED
UPDATED PER UNSOLICITED COMMENT MT-5364
FOR FILE RECORD RELEASE PER MT-5364

*** DENOTES PURCHASED WITH ASSOCIATED EQUIPMENT.
** FOR GENERAL NOTE SEE M-27 SHT. 3 OF 3

ESSENTIAL COMPONENTS INCLUDED

DRAWING RELEASE RECORD									
REV.	DATE	FIELD	PREPARED	REVIEWED	APPROVED	PURPOSE	FILM	REV.	DATE
1	12-8-50					REDESIGNED FOR FILE RECORD RELEASE PER MT-5236			
2	12-31-50					SEE NOTE FOR REV.			

DRAWING RELEASE RECORD									
REV.	DATE	FIELD	PREPARED	REVIEWED	APPROVED	PURPOSE	FILM	REV.	DATE

SCALE: NONE
PROJECT NUMBER: 4130-00

P & ID SERVICE WATER (WS)

WM. H. ZIMMER NUCLEAR POWER STATION UNIT 1
THE CINCINNATI GAS & ELECTRIC CO.
COLUMBUS & SOUTHERN OHIO ELECTRIC CO.
THE DAYTON POWER & LIGHT CO.

DRAWING NO. N-30
SHEET 3 OF 4

SARGENT & LUNDY
ENGINEERS
CHICAGO

RDS-PDR

8104010302

