

108

22

17

11

50


0.5"

11"

17"

22"

34"

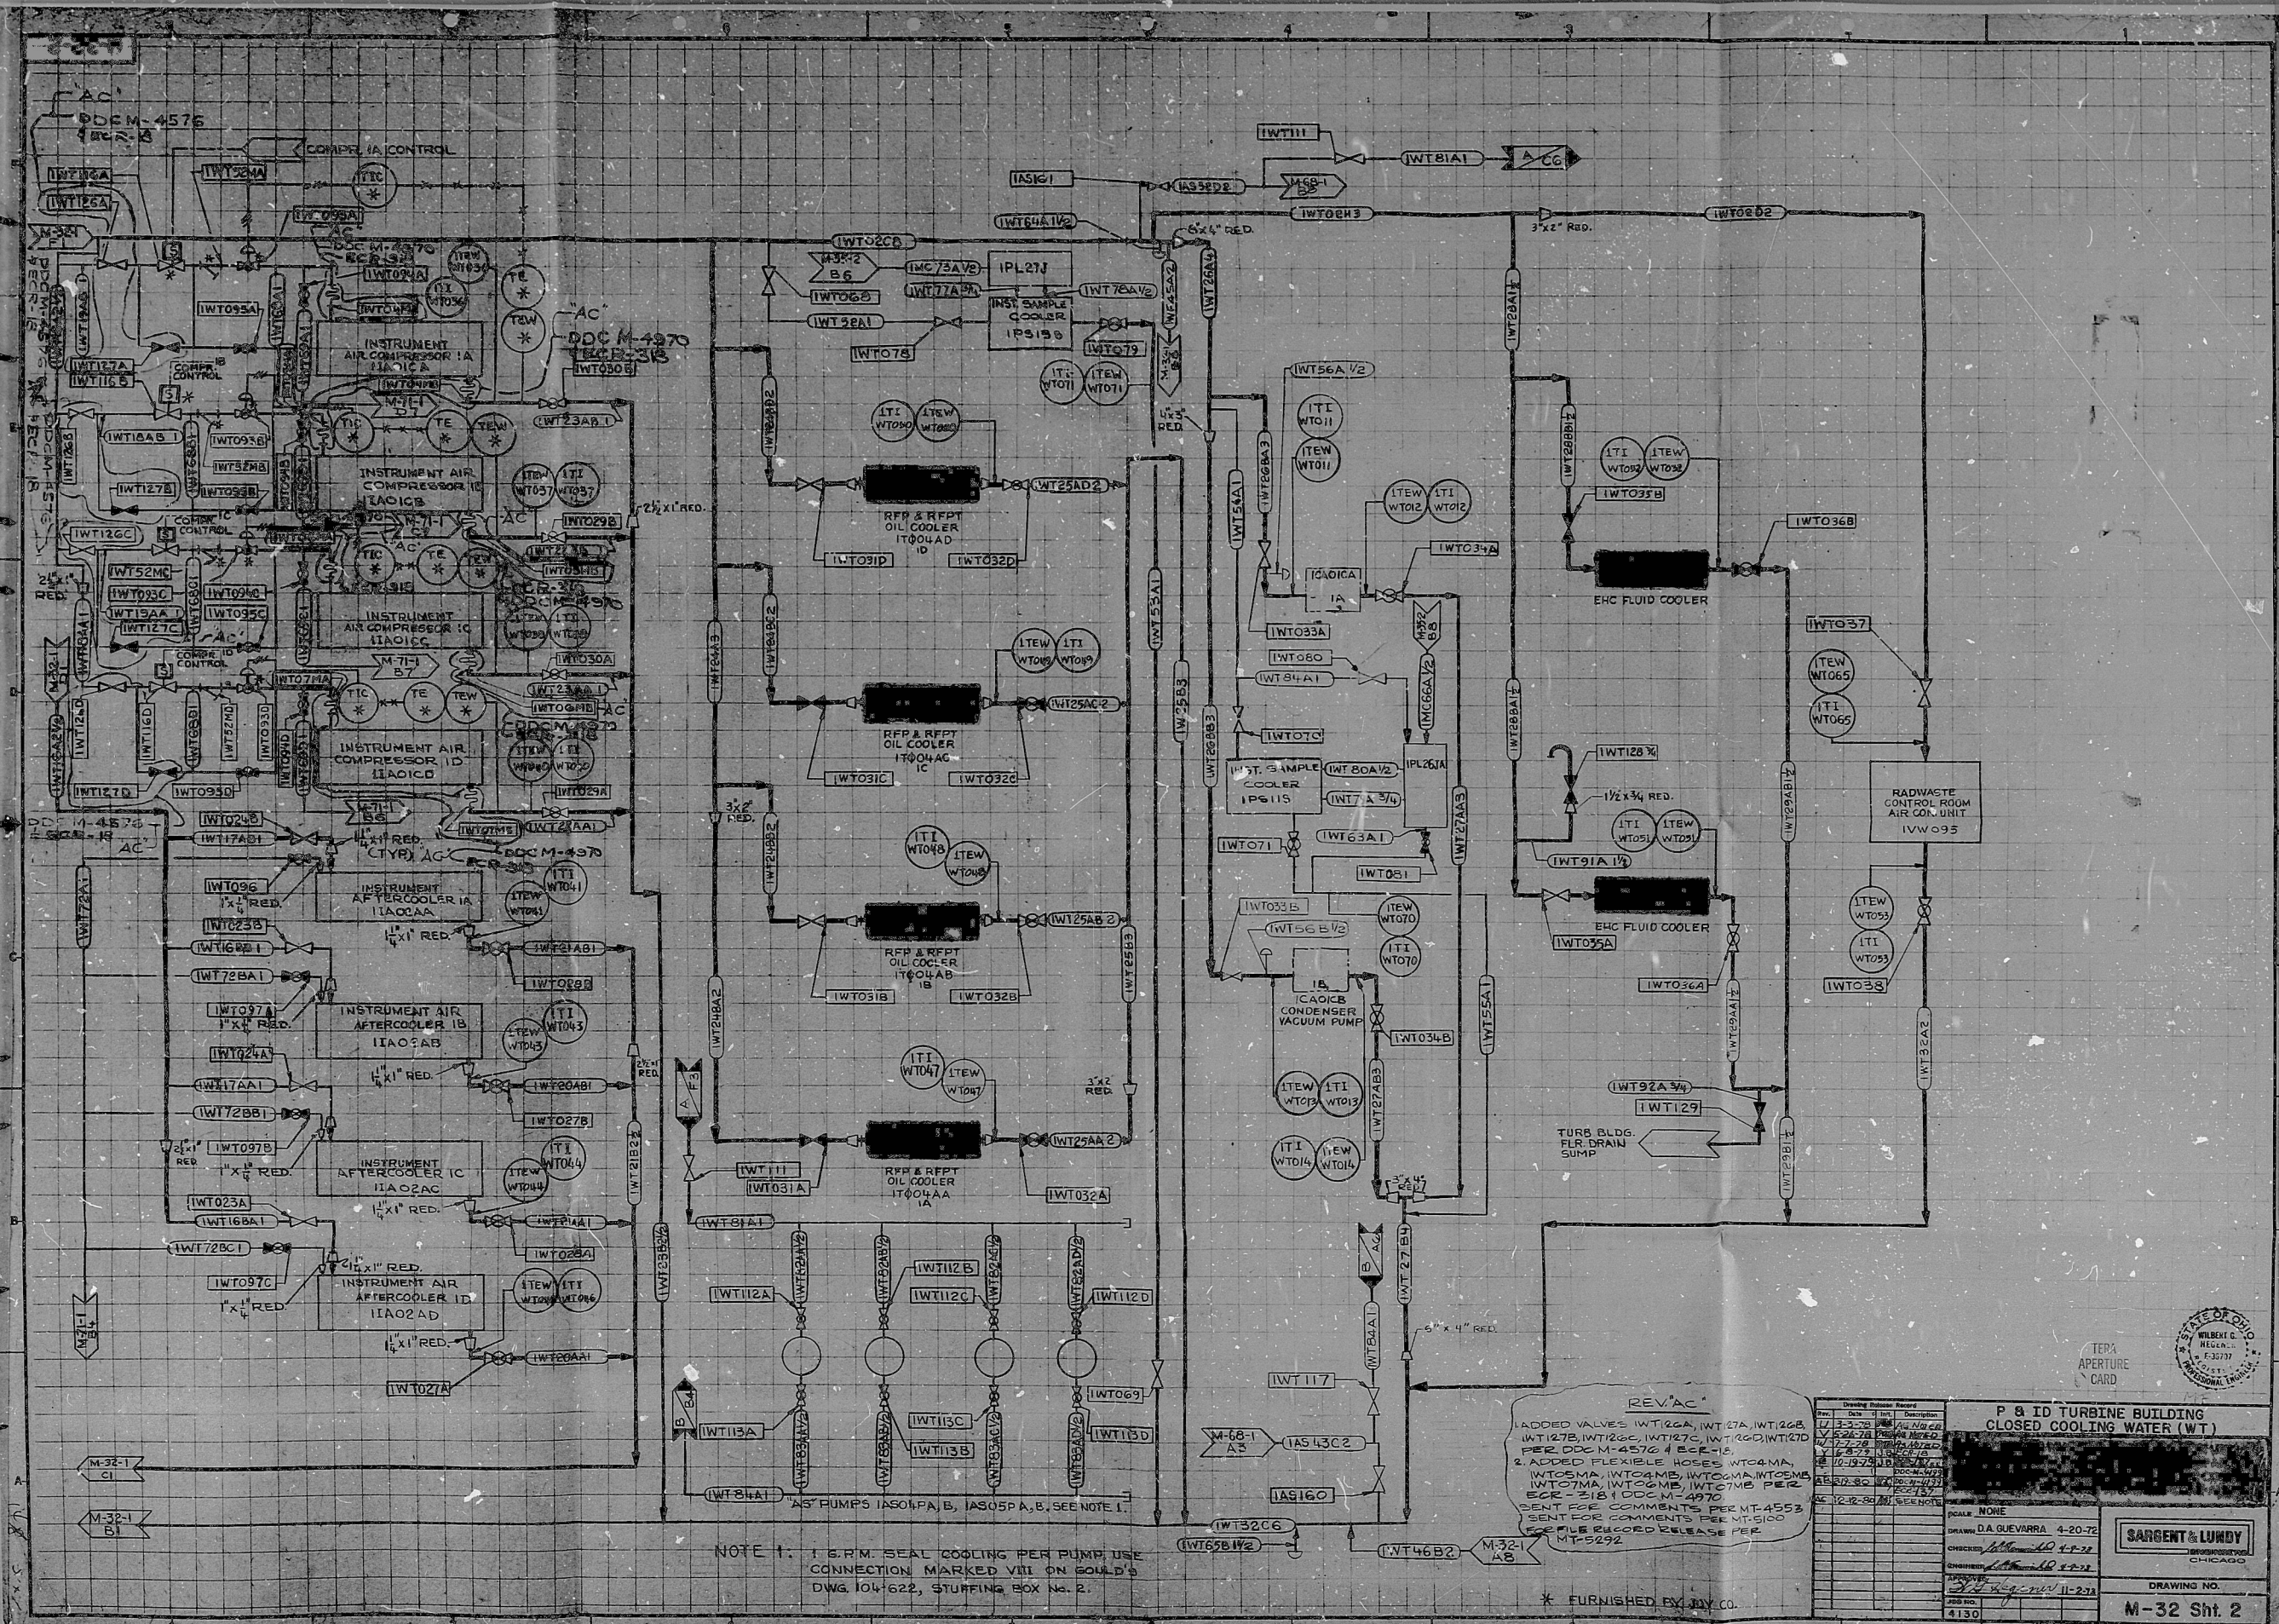

NOTE 1. 1 G.P.M. SEAL COOLING PER PUMP USE CONNECTION MARKED VIII ON SOUL'S DWG 104-622, STUFFING BOX No. 2.

REV. A  
ADDED VALVES WT126A, WT127A, WT126B, WT127B, WT126C, WT127C, WT126D, WT127D PER DDC M-4576 4-BF-15  
2 ADDED FLEXIBLE HOSES WT60A, WT60B, WT60C, WT60D, WT60E, WT60F, WT60G, WT60H, WT60I, WT60J, WT60K, WT60L, WT60M, WT60N, WT60O, WT60P, WT60Q, WT60R, WT60S, WT60T, WT60U, WT60V, WT60W, WT60X, WT60Y, WT60Z  
SENT FOR COMMENTS PER MT-4553  
SENT FOR COMMENTS PER MT-5100  
FOR FILE RECORD RELEASE PER MT-5292

| Drawing Number |             |
|----------------|-------------|
| Rev.           | Description |
| 1              | As Issued   |
| 2              | As Issued   |
| 3              | As Issued   |
| 4              | As Issued   |
| 5              | As Issued   |
| 6              | As Issued   |
| 7              | As Issued   |
| 8              | As Issued   |
| 9              | As Issued   |
| 10             | As Issued   |
| 11             | As Issued   |
| 12             | As Issued   |
| 13             | As Issued   |
| 14             | As Issued   |
| 15             | As Issued   |
| 16             | As Issued   |
| 17             | As Issued   |
| 18             | As Issued   |
| 19             | As Issued   |
| 20             | As Issued   |
| 21             | As Issued   |
| 22             | As Issued   |
| 23             | As Issued   |
| 24             | As Issued   |
| 25             | As Issued   |
| 26             | As Issued   |
| 27             | As Issued   |
| 28             | As Issued   |
| 29             | As Issued   |
| 30             | As Issued   |
| 31             | As Issued   |
| 32             | As Issued   |
| 33             | As Issued   |
| 34             | As Issued   |
| 35             | As Issued   |
| 36             | As Issued   |
| 37             | As Issued   |
| 38             | As Issued   |
| 39             | As Issued   |
| 40             | As Issued   |
| 41             | As Issued   |
| 42             | As Issued   |
| 43             | As Issued   |
| 44             | As Issued   |
| 45             | As Issued   |
| 46             | As Issued   |
| 47             | As Issued   |
| 48             | As Issued   |
| 49             | As Issued   |
| 50             | As Issued   |

Drawn: D.A. GUEVARA 4-20-76  
Checked: [Signature] 4-20-76  
Designed: [Signature] 4-20-76  
Job No. 4130

**SARGENT & LUNDY**  
ENGINEERS  
CHICAGO, ILL.

DRAWING NO.  
**M-32 Sht. 2**

RDS-PDR

8104010305

