


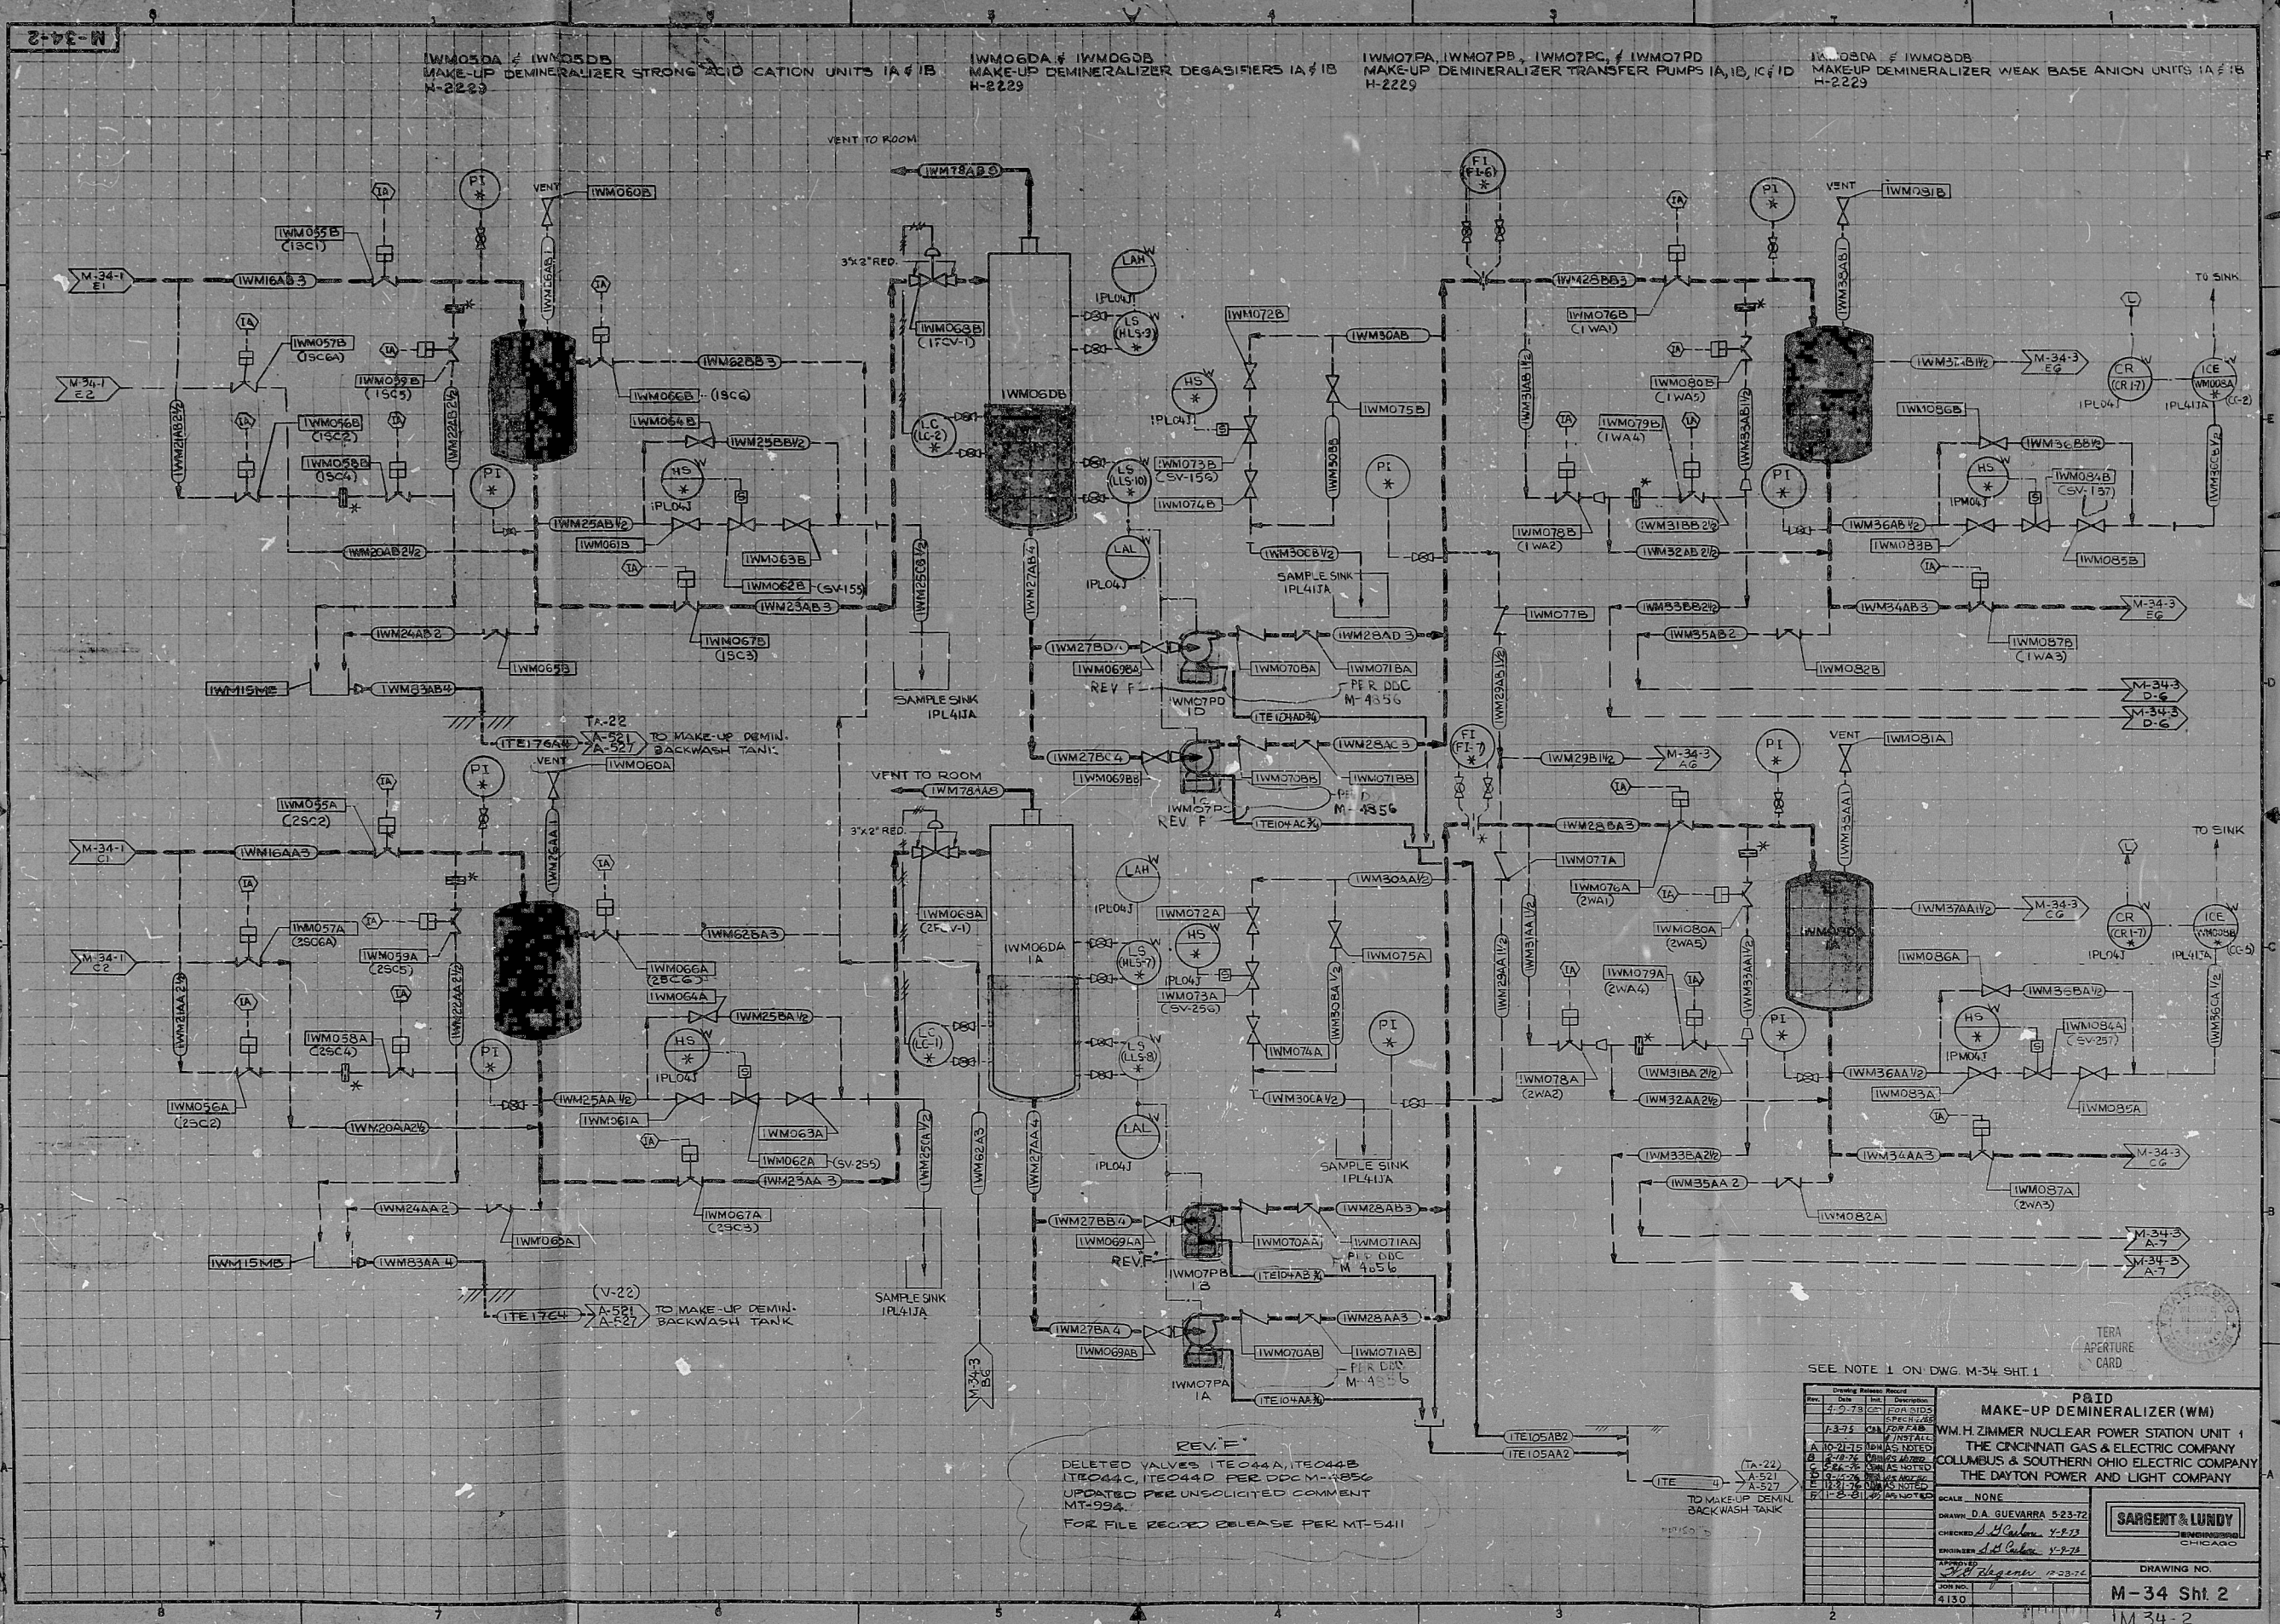

REV F
DELETED VALVES ITC44A, ITC44B
ITC44C, ITC44D PER DDC M-4856
UPDATED PER UNSOLICITED COMMENT
MT-994.
FOR FILE REQ'D RELEASE PER MT-5411

SEE NOTE 1 ON DWG. M-34 SHT. 1

Rev.	Date	By	Description
1	1-2-78	DA	FOR P&ID
2	1-2-78	DA	FOR P&ID
3	1-2-78	DA	FOR P&ID
4	1-2-78	DA	FOR P&ID
5	1-2-78	DA	FOR P&ID
6	1-2-78	DA	FOR P&ID
7	1-2-78	DA	FOR P&ID
8	1-2-78	DA	FOR P&ID
9	1-2-78	DA	FOR P&ID
10	1-2-78	DA	FOR P&ID

P&ID
MAKE-UP DEMINERALIZER (WM)
WM H ZIMMER NUCLEAR POWER STATION UNIT 1
THE CINCINNATI GAS & ELECTRIC COMPANY
COLUMBUS & SOUTHERN OHIO ELECTRIC COMPANY
THE DAYTON POWER AND LIGHT COMPANY

SCALE: NONE
DRAWN: D.A. GUEVARA 523-72
CHECKED: J. L. CULLEN 7-5-73
ENGINEER: J. L. CULLEN 7-5-73
APPROVED: J. L. CULLEN 7-5-73
JOB NO. 4130

DRAWING NO.
M-34 Sht. 2
M-34-2

RIDS - DDB

8104010308

