




DRAWING RELEASE RECORD						DRAWING RELEASE RECORD					
REV.	DATE RELD.	PREPARED	REVIEWED	APPROVED	PURPOSE	REV.	DATE RELD.	PREPARED	REVIEWED	APPROVED	PURPOSE
B	7-31-80	A. R. Rambo	J. Began	M. H. Olson	REDRAWN TO AGREE WITH PHYSICAL ROUTING, PER ECR-226						
C	10-28-80	A. R. Rambo	A. C. Brown		SEE NOTE FOR REV.						
D	12-11-80	A. R. Rambo	W. J. Began	A. C. Brown	SEE REV. NOTE						

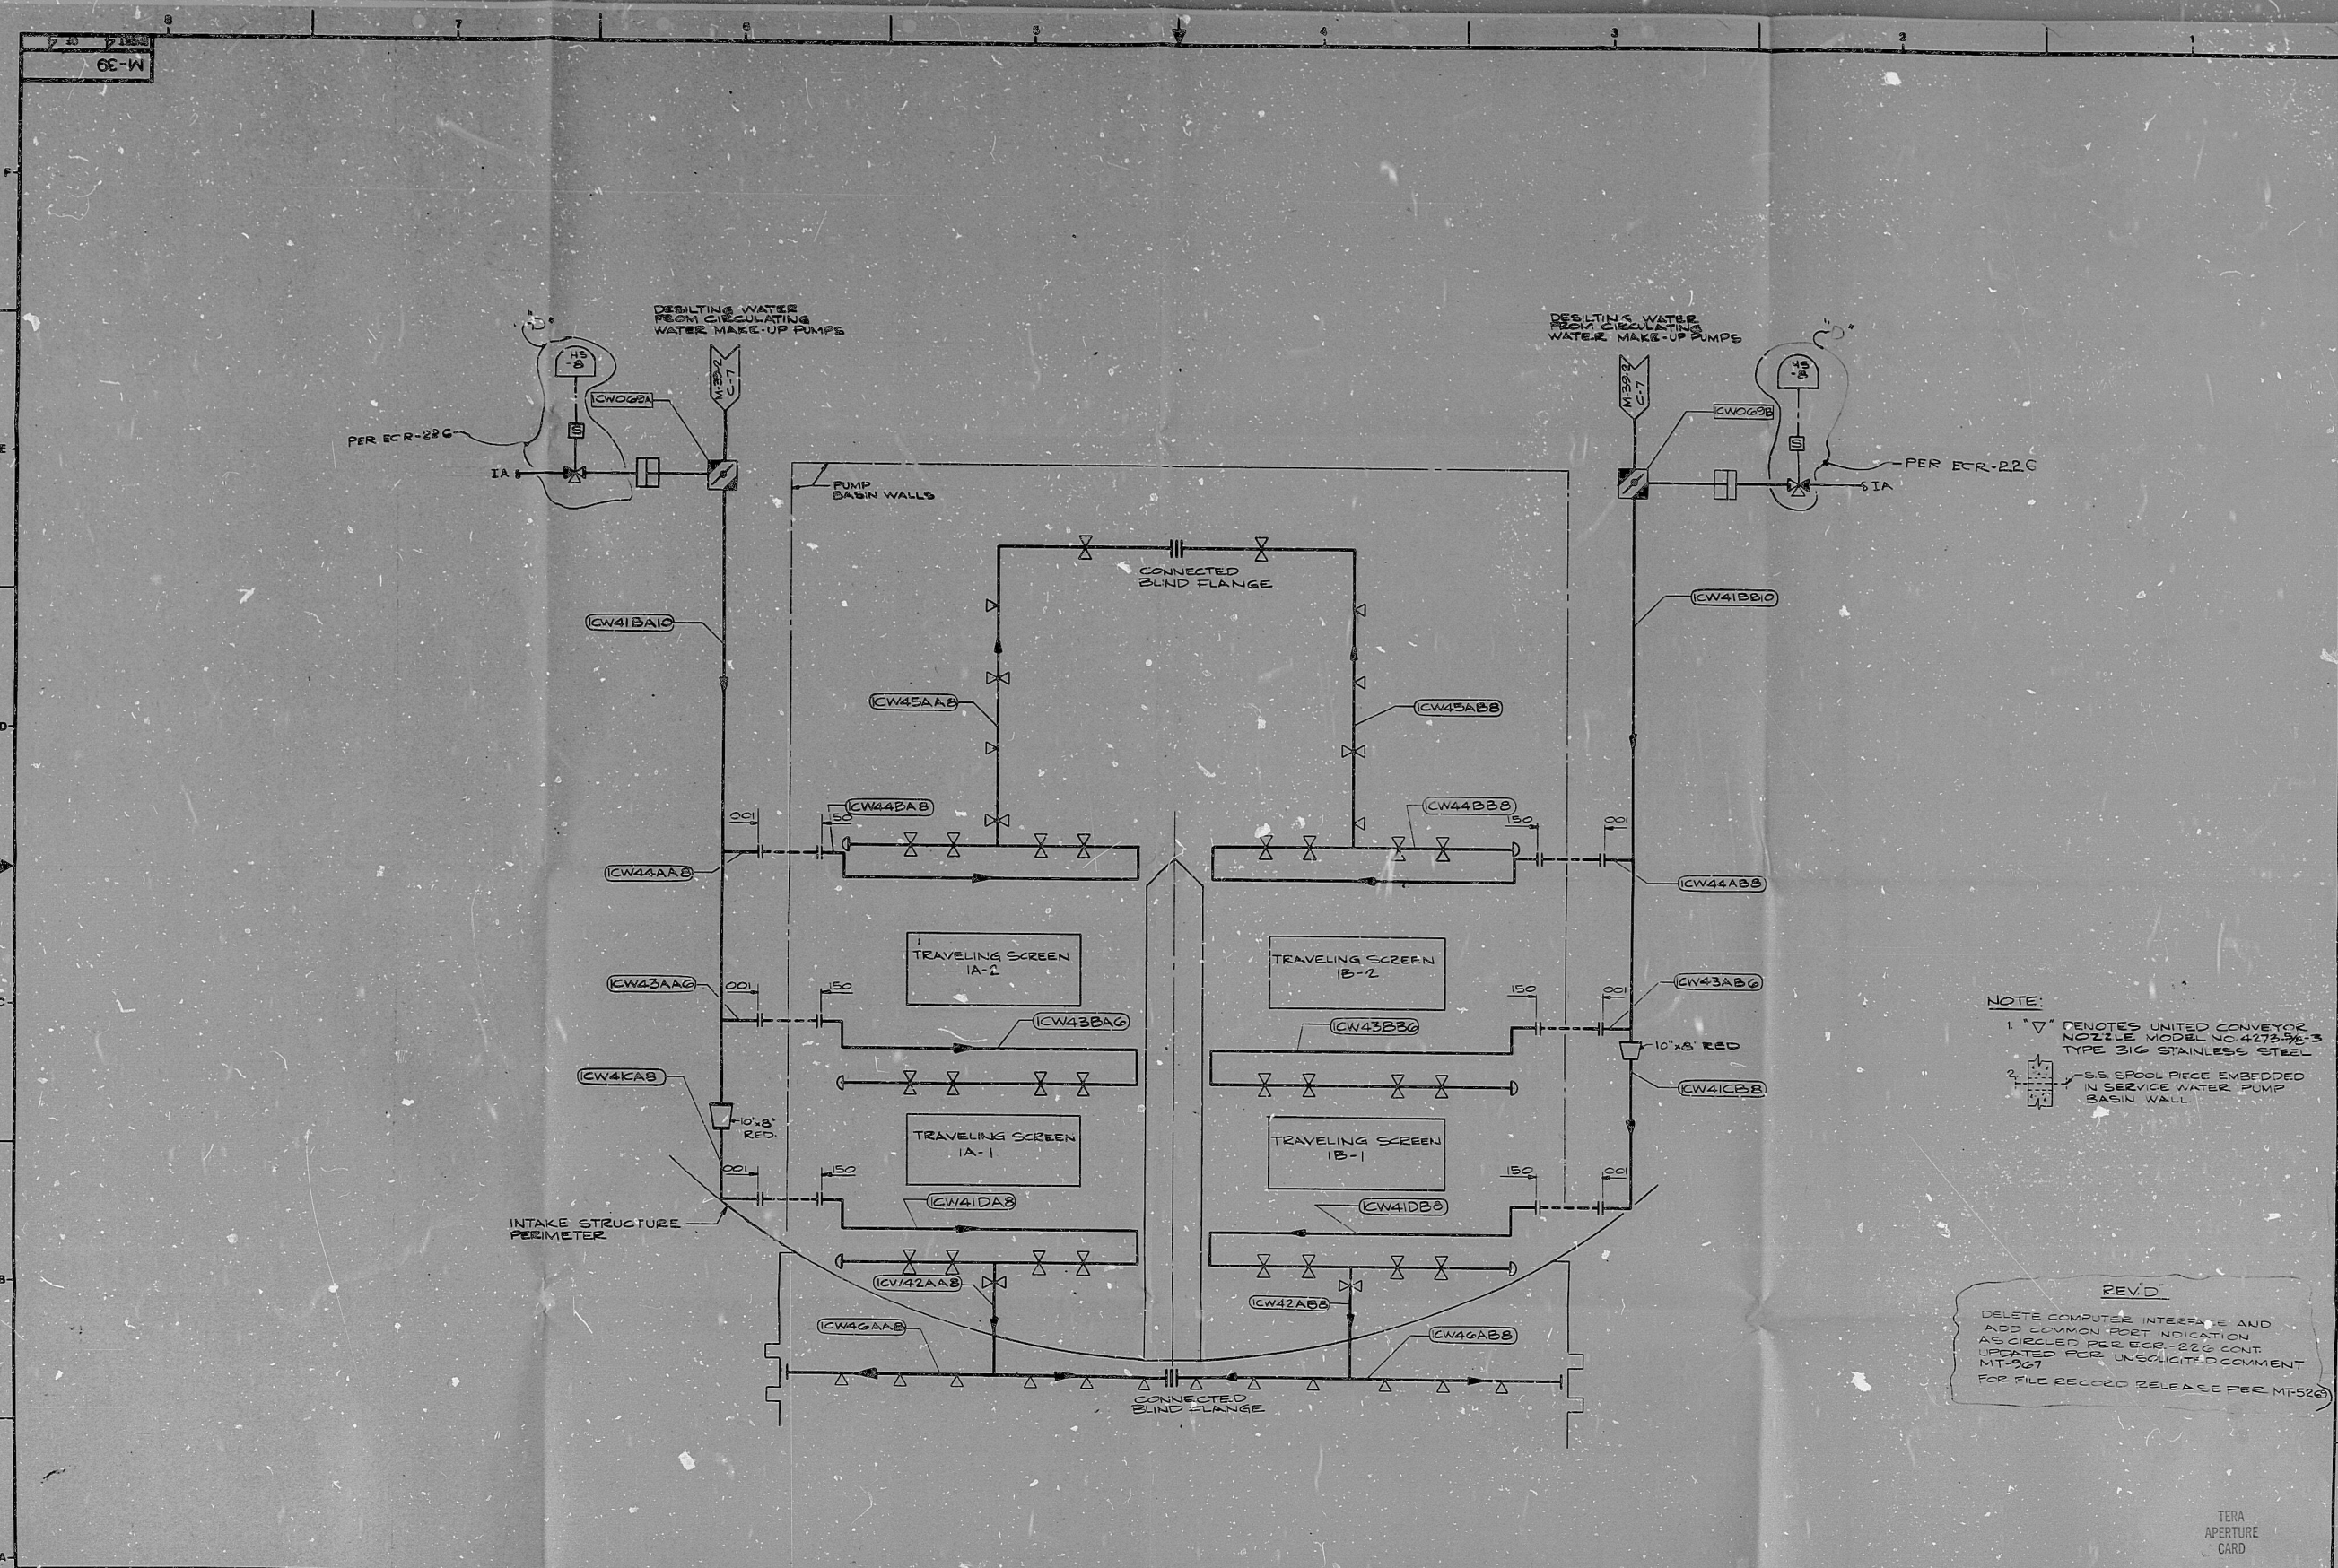

SCALE: NONE
PROJECT NUMBER: 4130-00

P & ID
CIRCULATING WATER
INTAKE STRUCTURE SILT
CONTROL

WMZIMMER NUCLEAR POWER STATION UNIT 1
THE CHICAGO GAS & ELECTRIC COMPANY
COLUMBUS & SOUTHERN OHIO ELECTRIC CO.
THE DAYTON POWER & LIGHT COMPANY

SARGENT & LUNDY
ENGINEERS
CHICAGO

DRAWING NO. M-39
REV. D

SHEET 4 OF 4

RDS-RDR

8104010326

