


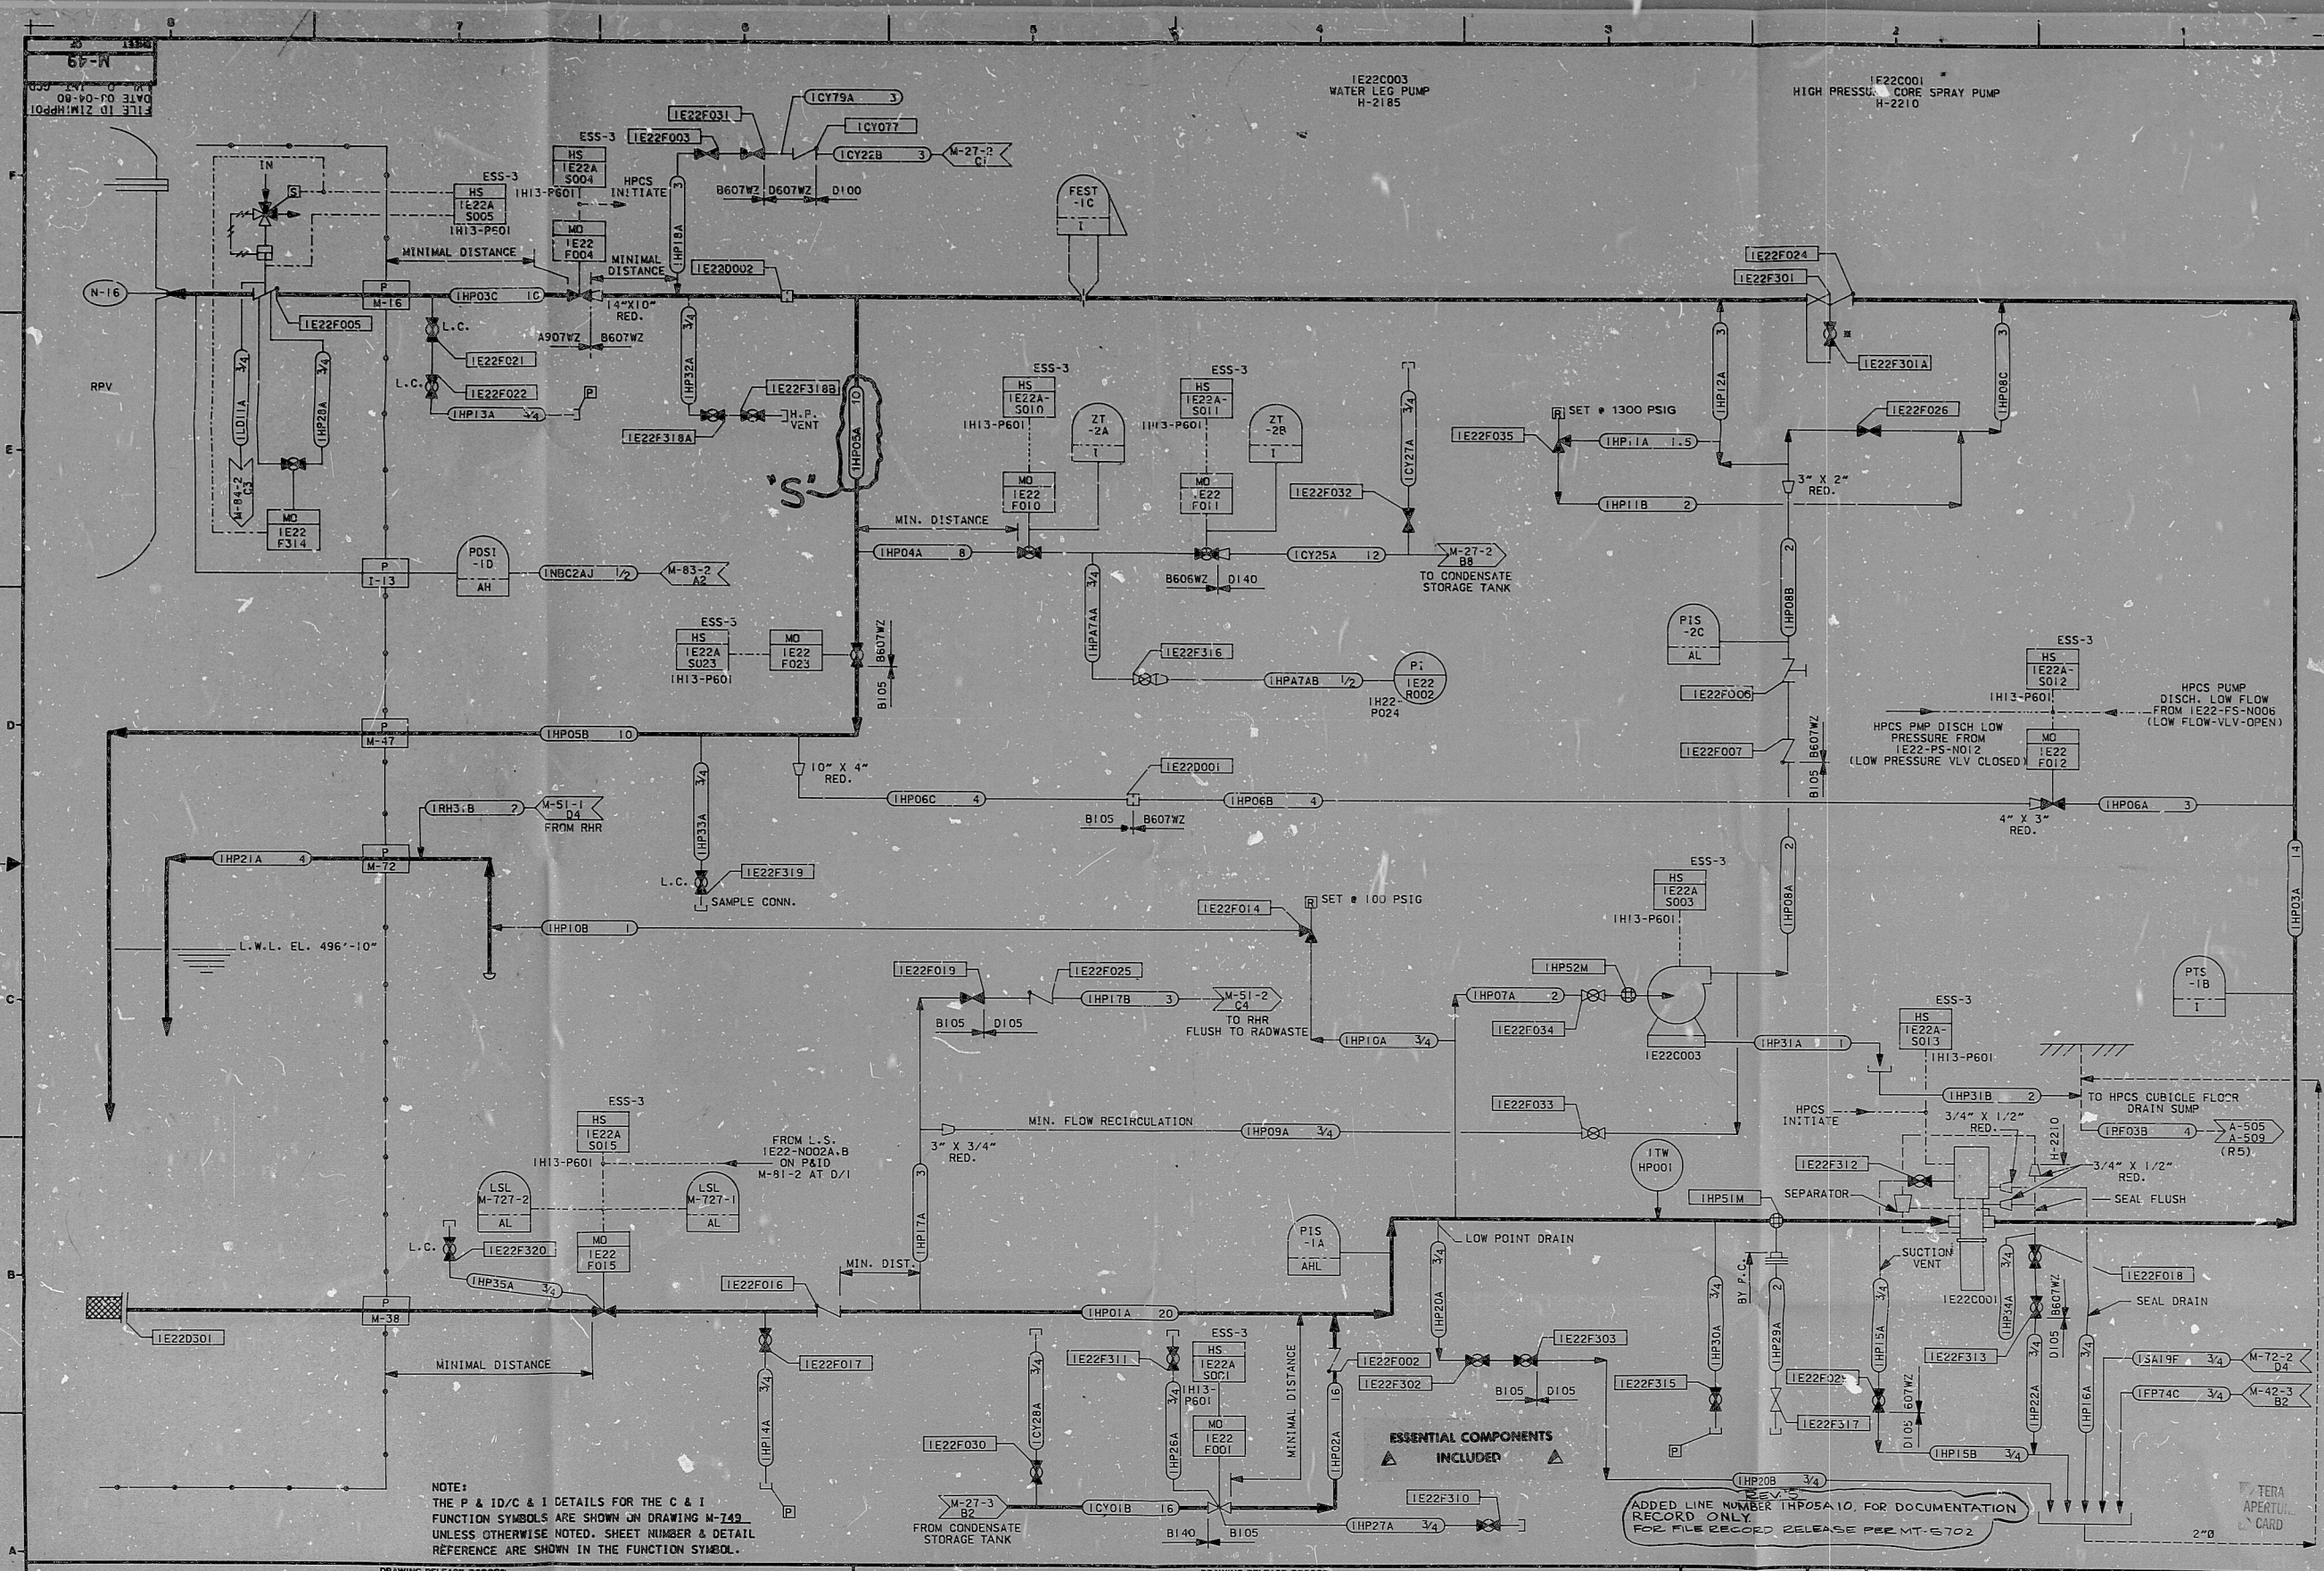

DRAWING RELEASE RECORD						DRAWING RELEASE RECORD					
REV.	DATE	FIELD	PREPARED	REVIEWED	APPROVED	PURPOSE	REV.	DATE	FIELD	PREPARED	REVIEWED
1	12-2-60		A. J. Koster			SEE DRAWING NOTE					
2	12-20-61					SEE REV. NOTE					

DRAWING RELEASE RECORD						DRAWING RELEASE RECORD					
REV.	DATE	FIELD	PREPARED	REVIEWED	APPROVED	PURPOSE	REV.	DATE	FIELD	PREPARED	REVIEWED

SCALE: NONE

PROJECT NUMBER: 4130-00

P & ID
HIGH PRESSURE CORE SPRAY
(HPCS) HP

W. H. ZIMMER NUCLEAR POWER STATION UNIT 1
THE CINCINNATI GAS & ELECTRIC CO.
COLUMBUS & SOUTHERN OHIO ELECTRIC CO.
THE DAYTON POWER & LIGHT CO.

SARGENT & LUNDY
ENGINEERS
CHICAGO

DRAWING NO. M-49
SHEET OF 1

RDS-PDR

810409355

