


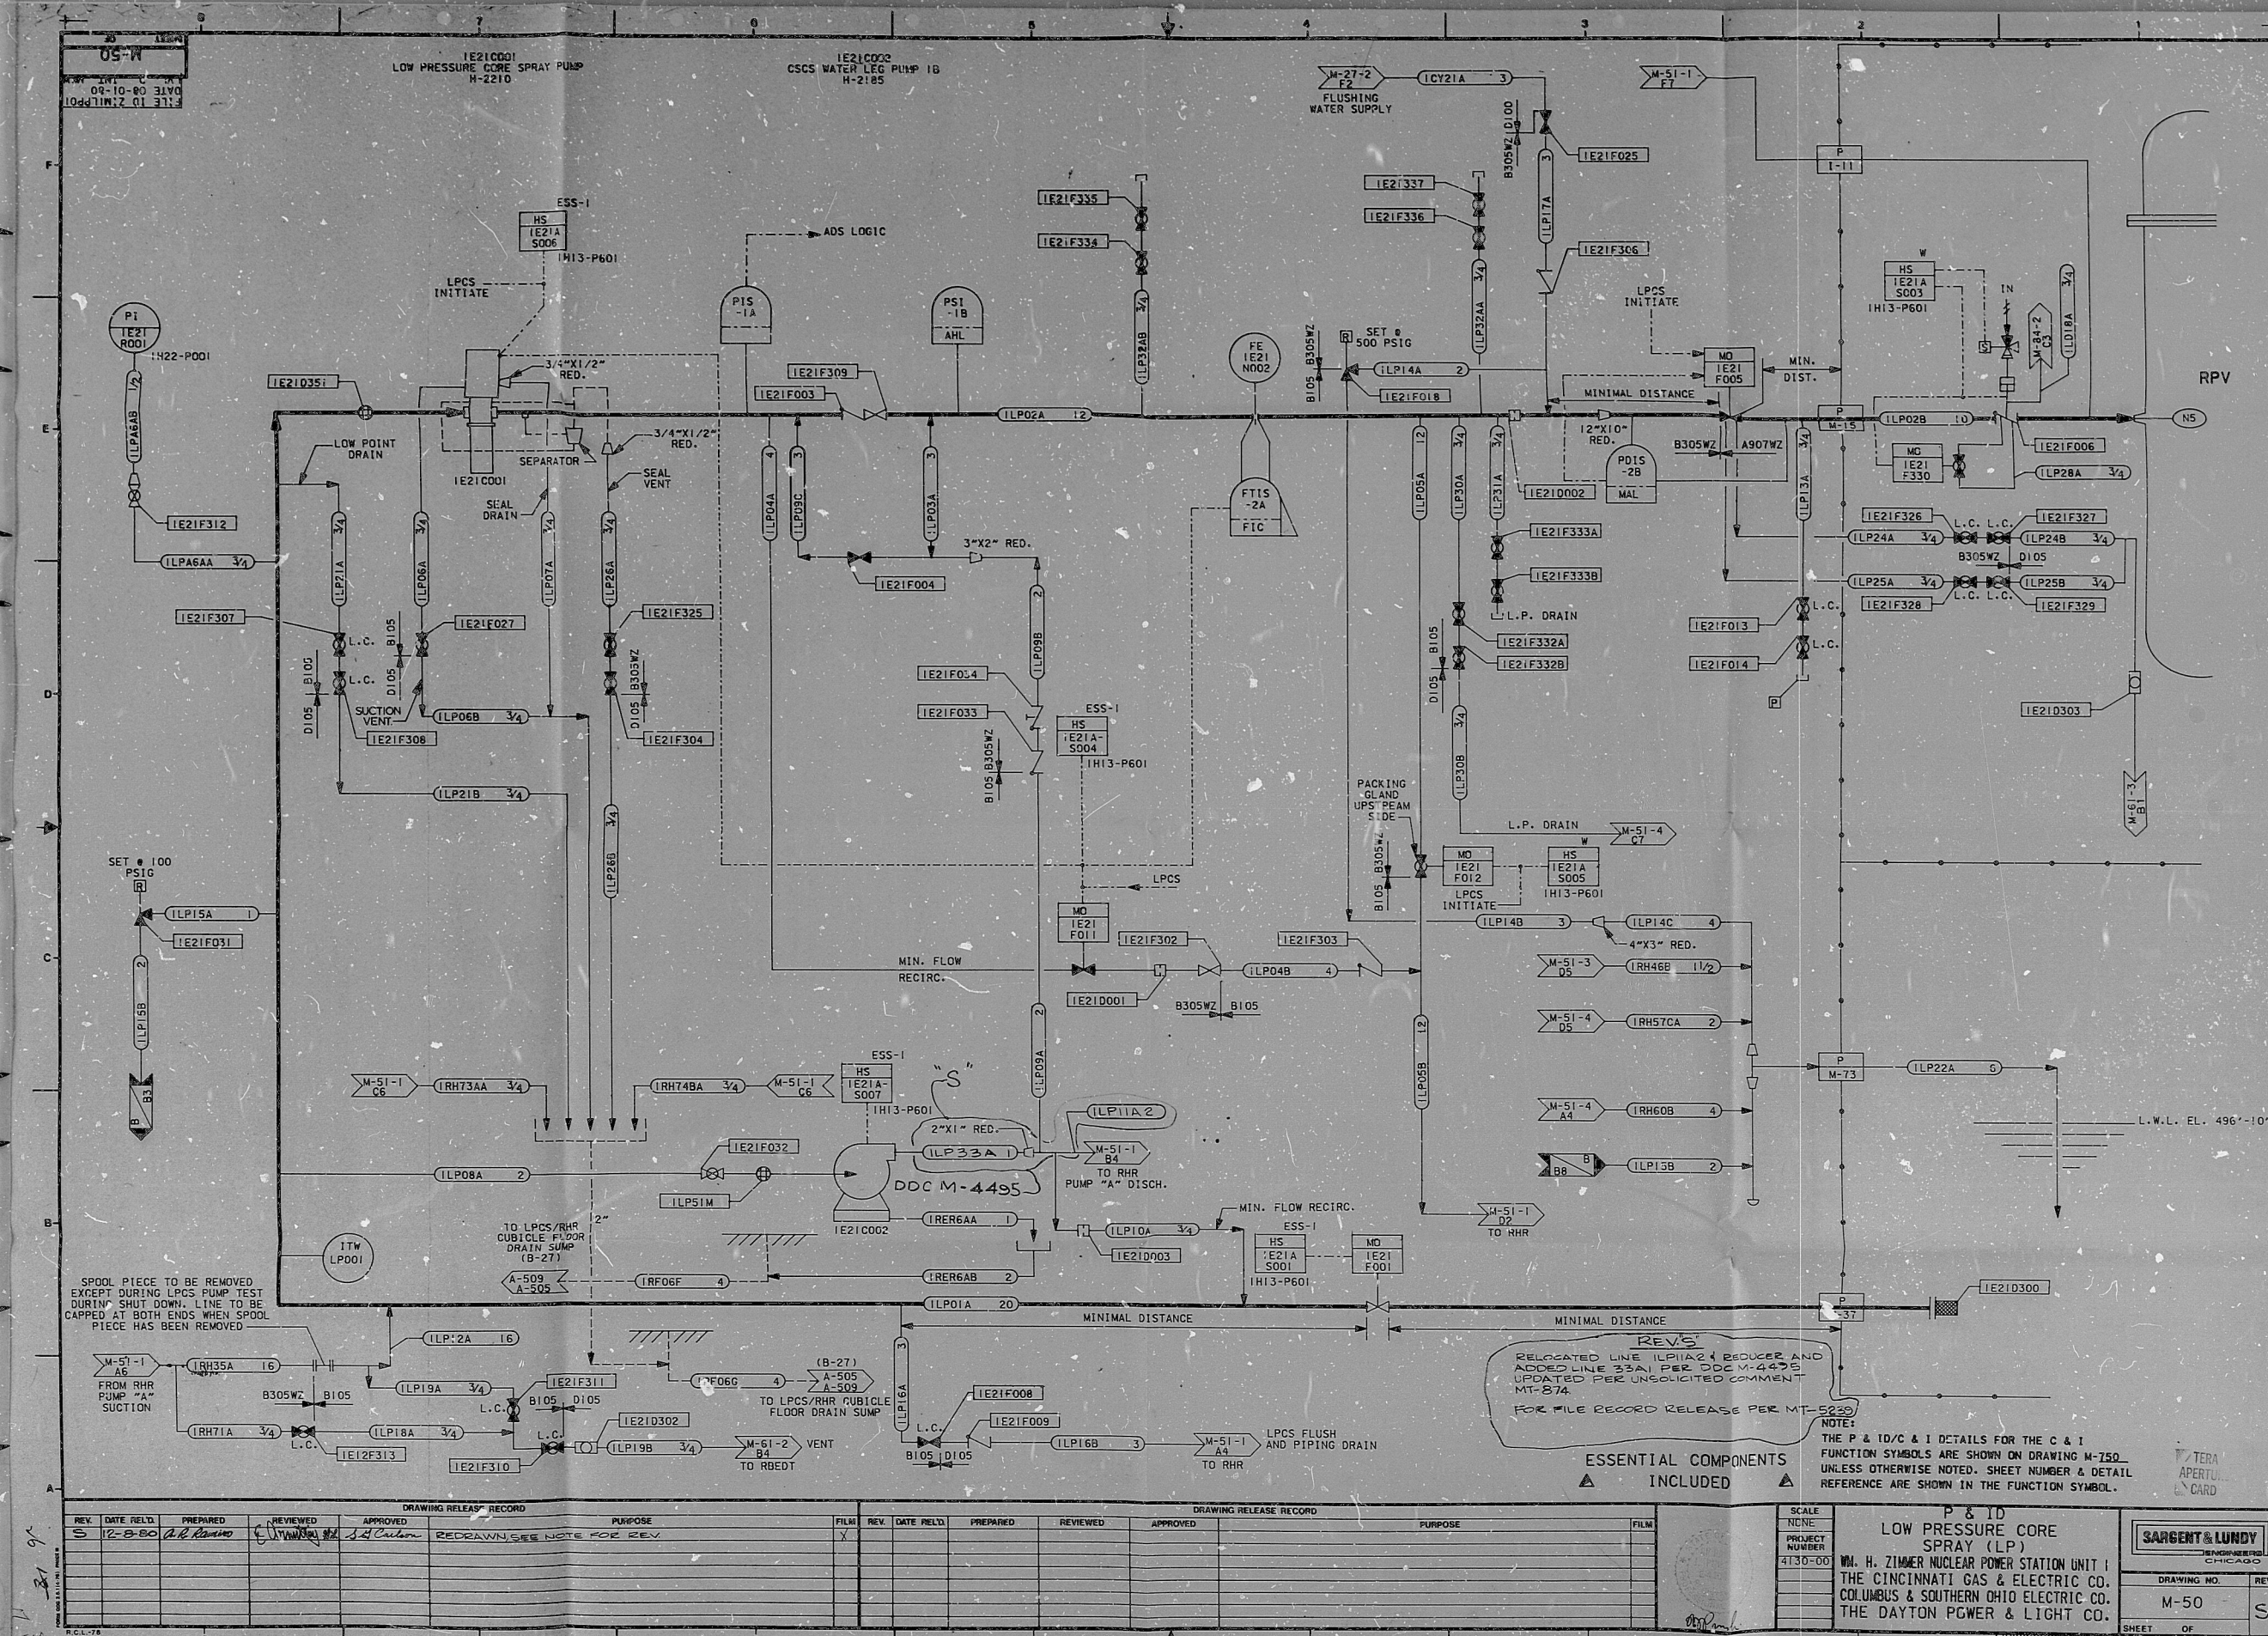

DRAWING RELEASE RECORD						DRAWING RELEASE RECORD						SCALE NONE		P & ID LOW PRESSURE CORE SPRAY (LP)		SARGENT & LUNDY ENGINEERS CHICAGO	
REV.	DATE	FILED	PREPARED	REVIEWED	PURPOSE	REV.	DATE	FILED	PREPARED	REVIEWED	PURPOSE			WM. H. ZIMMER NUCLEAR POWER STATION UNIT I THE CINCINNATI GAS & ELECTRIC CO. COLUMBUS & SOUTHERN OHIO ELECTRIC CO. THE DAYTON POWER & LIGHT CO.			
1	2-8-80		A.R. Rando	C. H. H. H. H.	REDRAWN SEE NOTE FOR REV												
														DRAWING NO. M-50 SHEET OF S			

R.C.L.-78

RIDS-PDR

8104010358

