


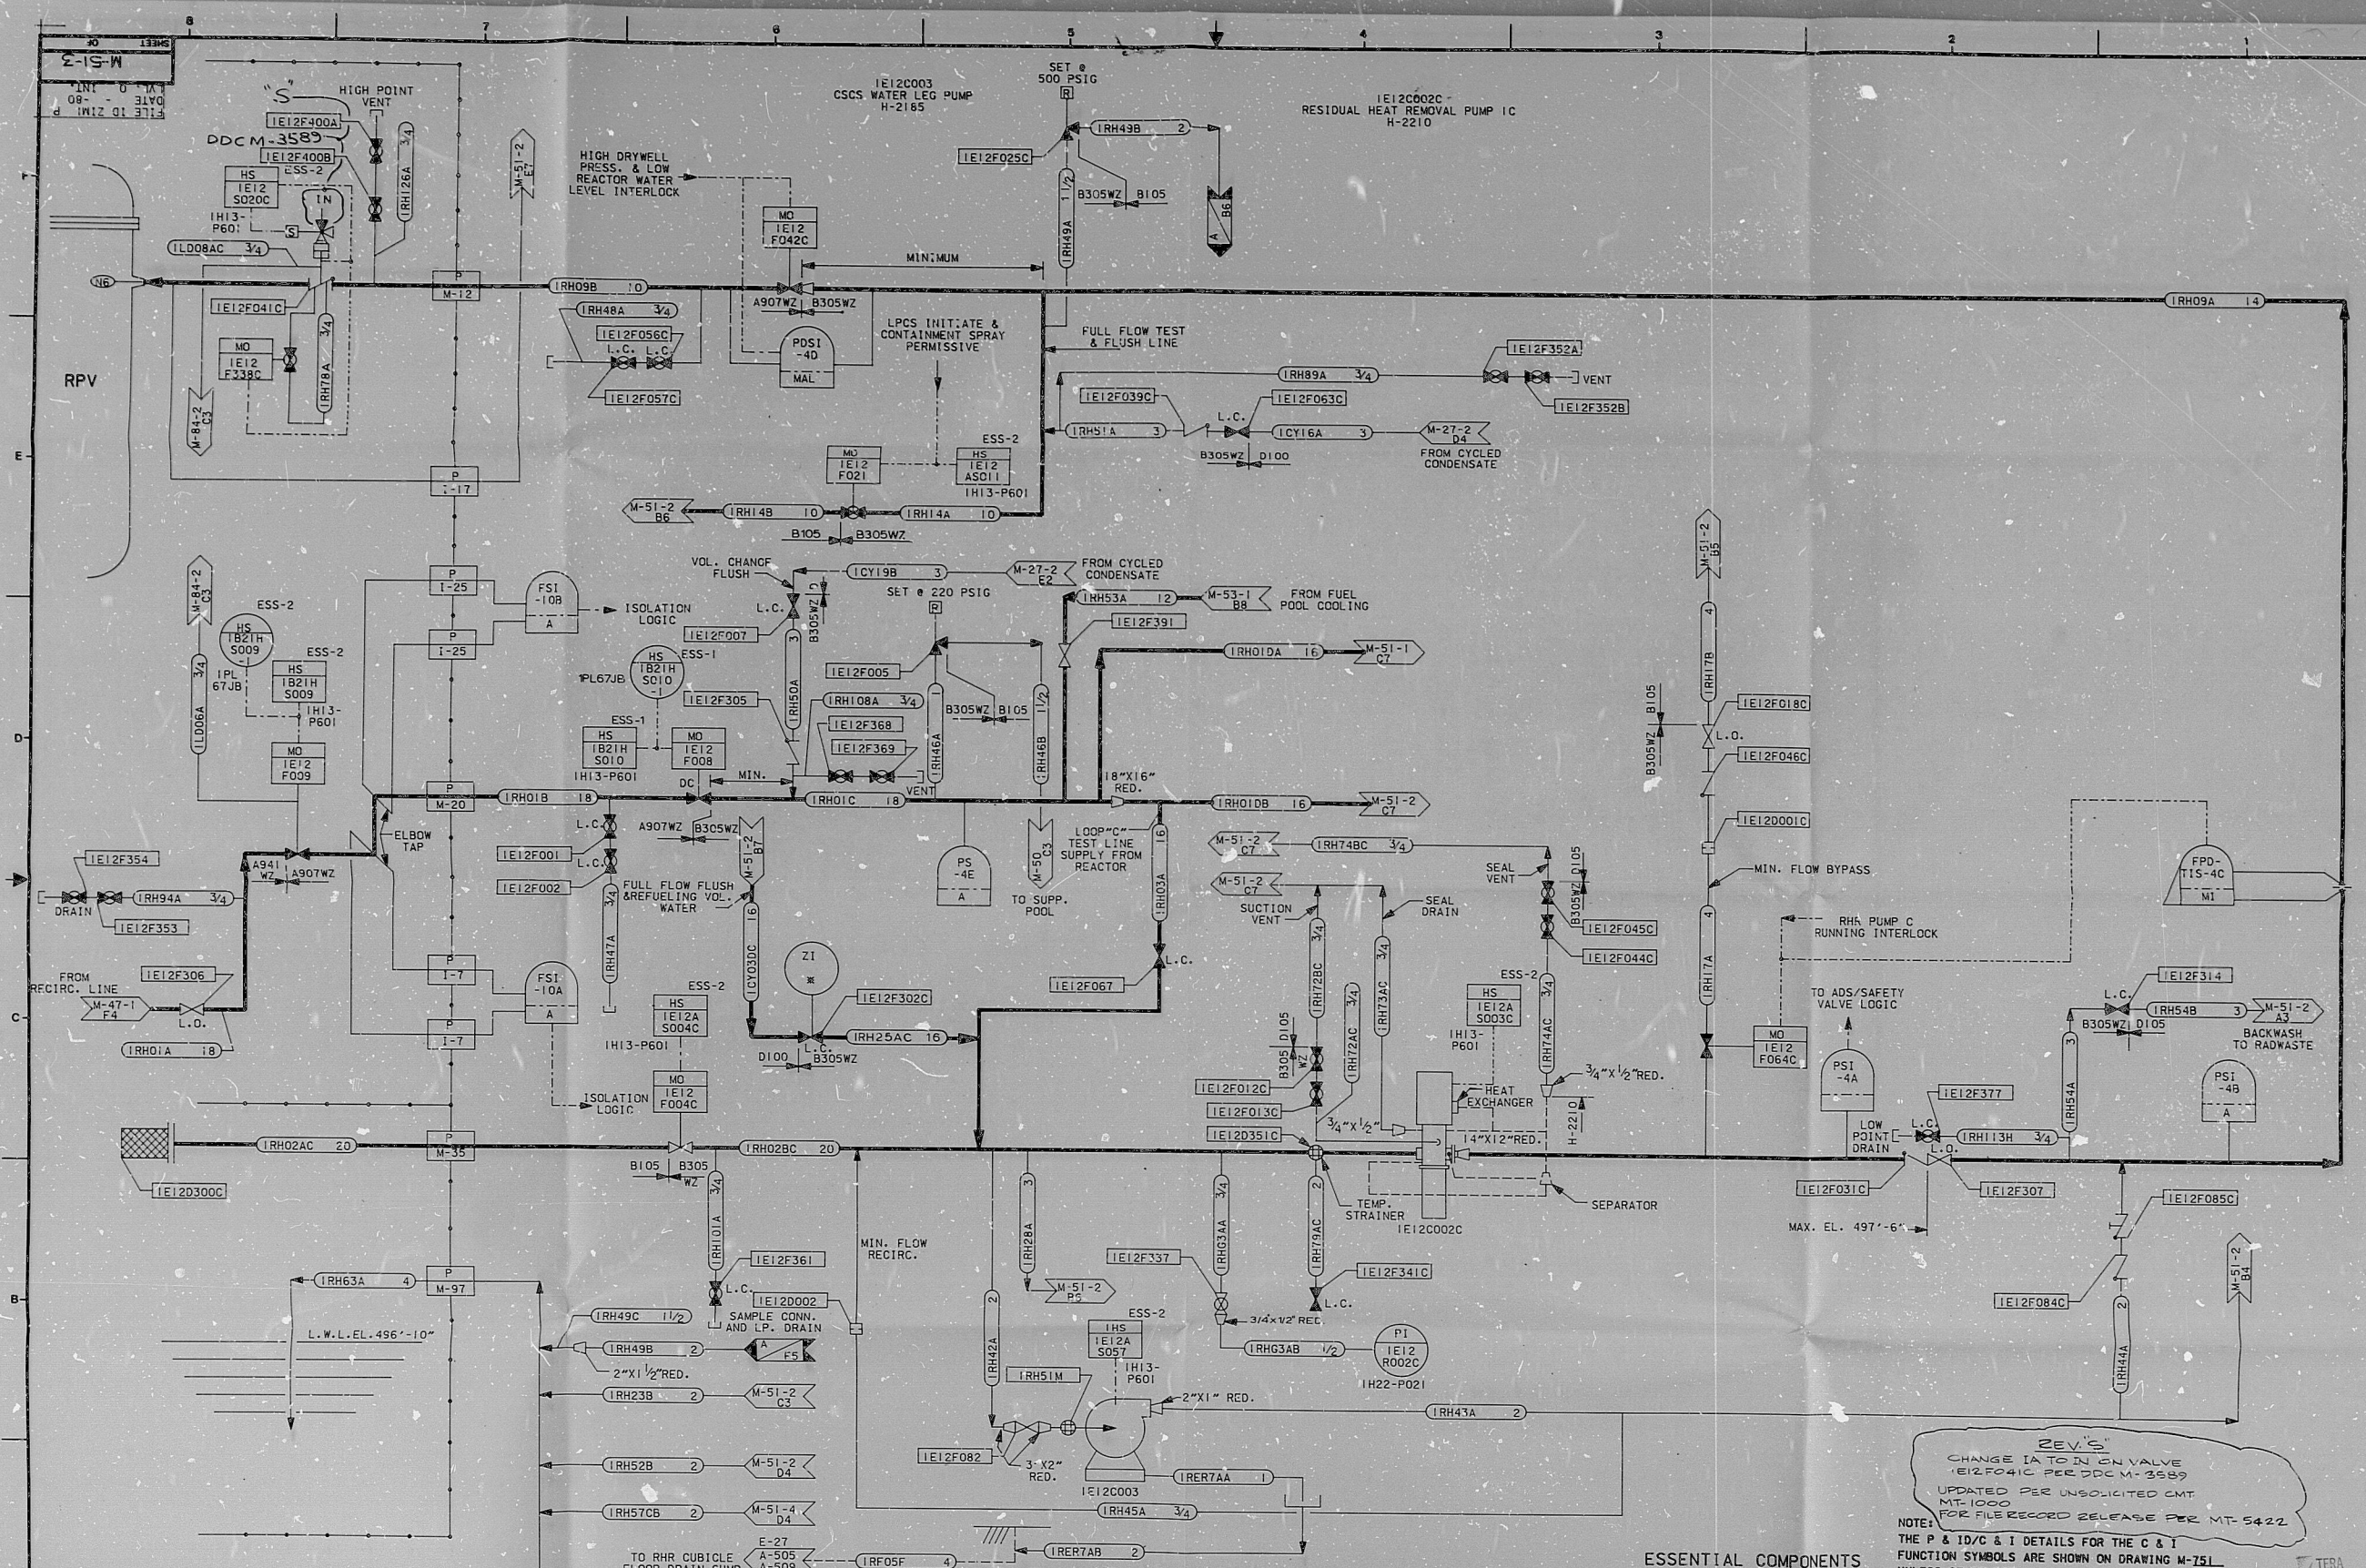

REV'S
CHANGE IATON ON VALVE
IE12F041C PER DDCM-3589
UPDATED PER UNSOLICITED CMT
MT-1000
FOR FILE RECORD RELEASE PER MT-5422

ESSENTIAL COMPONENTS
INCLUDED

REV.	DATE	RELD.	PREPARED	REVIEWED	APPROVED	PURPOSE	FILM	REV.	DATE	RELD.	PREPARED	REVIEWED	APPROVED	PURPOSE	FILM
1	12-8-80		2 R. Remick			REDRAWN FOR FILE RECORD RELEASE PER MT-5250									
2	1-13-81		2 R. Remick			SEE NOTE									

SCALE
NONE
PROJECT
NUMBER
4130-00

P & ID
RESIDUAL HEAT REMOVAL
(RH)

WM. H. ZIMMER NUCLEAR POWER STATION UNIT 1
THE CINCINNATI GAS & ELECTRIC CO.
COLUMBUS & SOUTHERN OHIO ELECTRIC CO.
THE DAYTON POWER & LIGHT CO.

SARGENT & LUNDY
ENGINEERS
CHICAGO

DRAWING NO.
M-51

REV.
S

SHEET 3 OF 3

REDS-PDR

8104010368

