


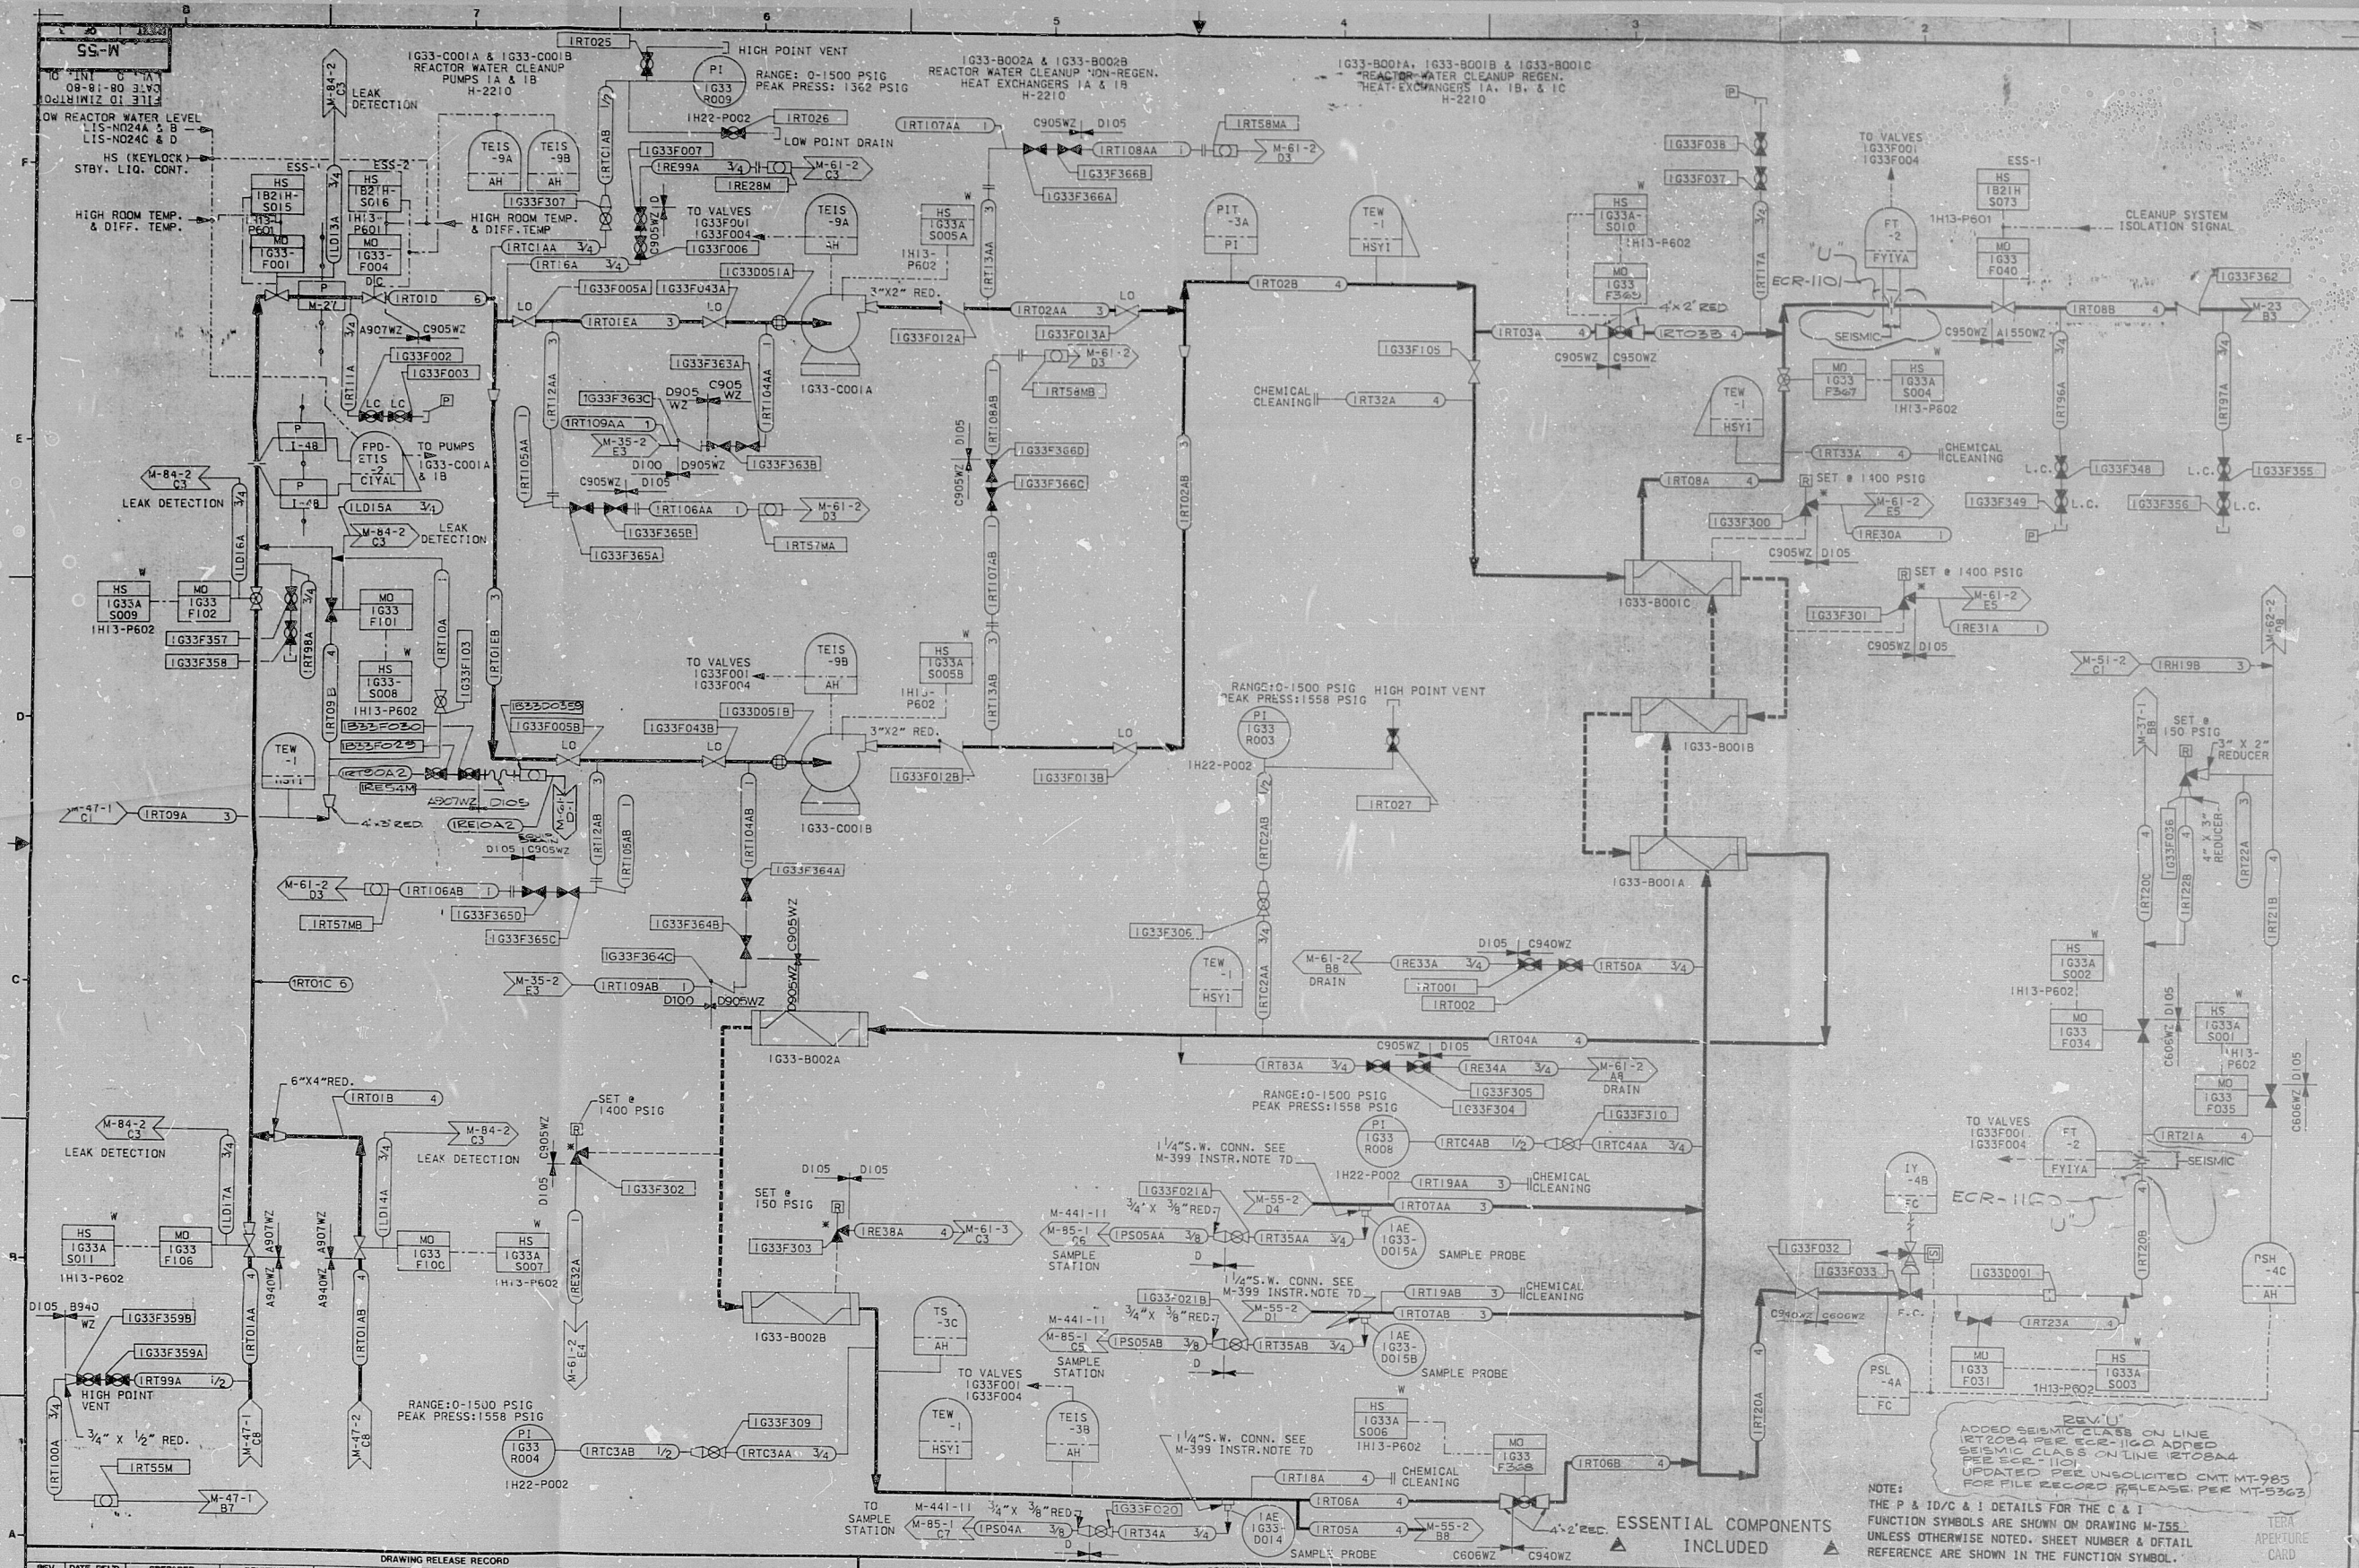

DRAWING RELEASE RECORD									
REV	DATE	RELD	PREPARED	REVIEWED	APPROVED	PURPOSE	FILM	REV	DATE
1	11-3-60		A. R. Romano			REDESIGNED			
2	12-28-60		A. R. Romano			REDESIGNED			

DRAWING RELEASE RECORD									
REV	DATE	RELD	PREPARED	REVIEWED	APPROVED	PURPOSE	FILM	REV	DATE
1	11-3-60		A. R. Romano			REDESIGNED			
2	12-28-60		A. R. Romano			REDESIGNED			

NOTE: THE P & ID/C & I DETAILS FOR THE C & I FUNCTION SYMBOLS ARE SHOWN ON DRAWING M-755. UNLESS OTHERWISE NOTED, SHEET NUMBER & DETAIL REFERENCE ARE SHOWN IN THE FUNCTION SYMBOL.

SCALE: NONE
 PROJECT: 4130-00
 SHEET: 1 OF 3

P & ID
 REACTOR WATER CLEANUP (RT)

W. H. ZIMMER NUCLEAR POWER STATION UNIT 1
 THE CINCINNATI GAS & ELECTRIC CO.
 COLUMBUS & SOUTHERN OHIO ELECTRIC CO.
 THE DAYTON POWER & LIGHT CO.

SARGENT & LUNDY
 ENGINEERS
 CHICAGO, ILL.

DRAWING NO. M-55
 REV. U

RDS-PDR

8104010379

