


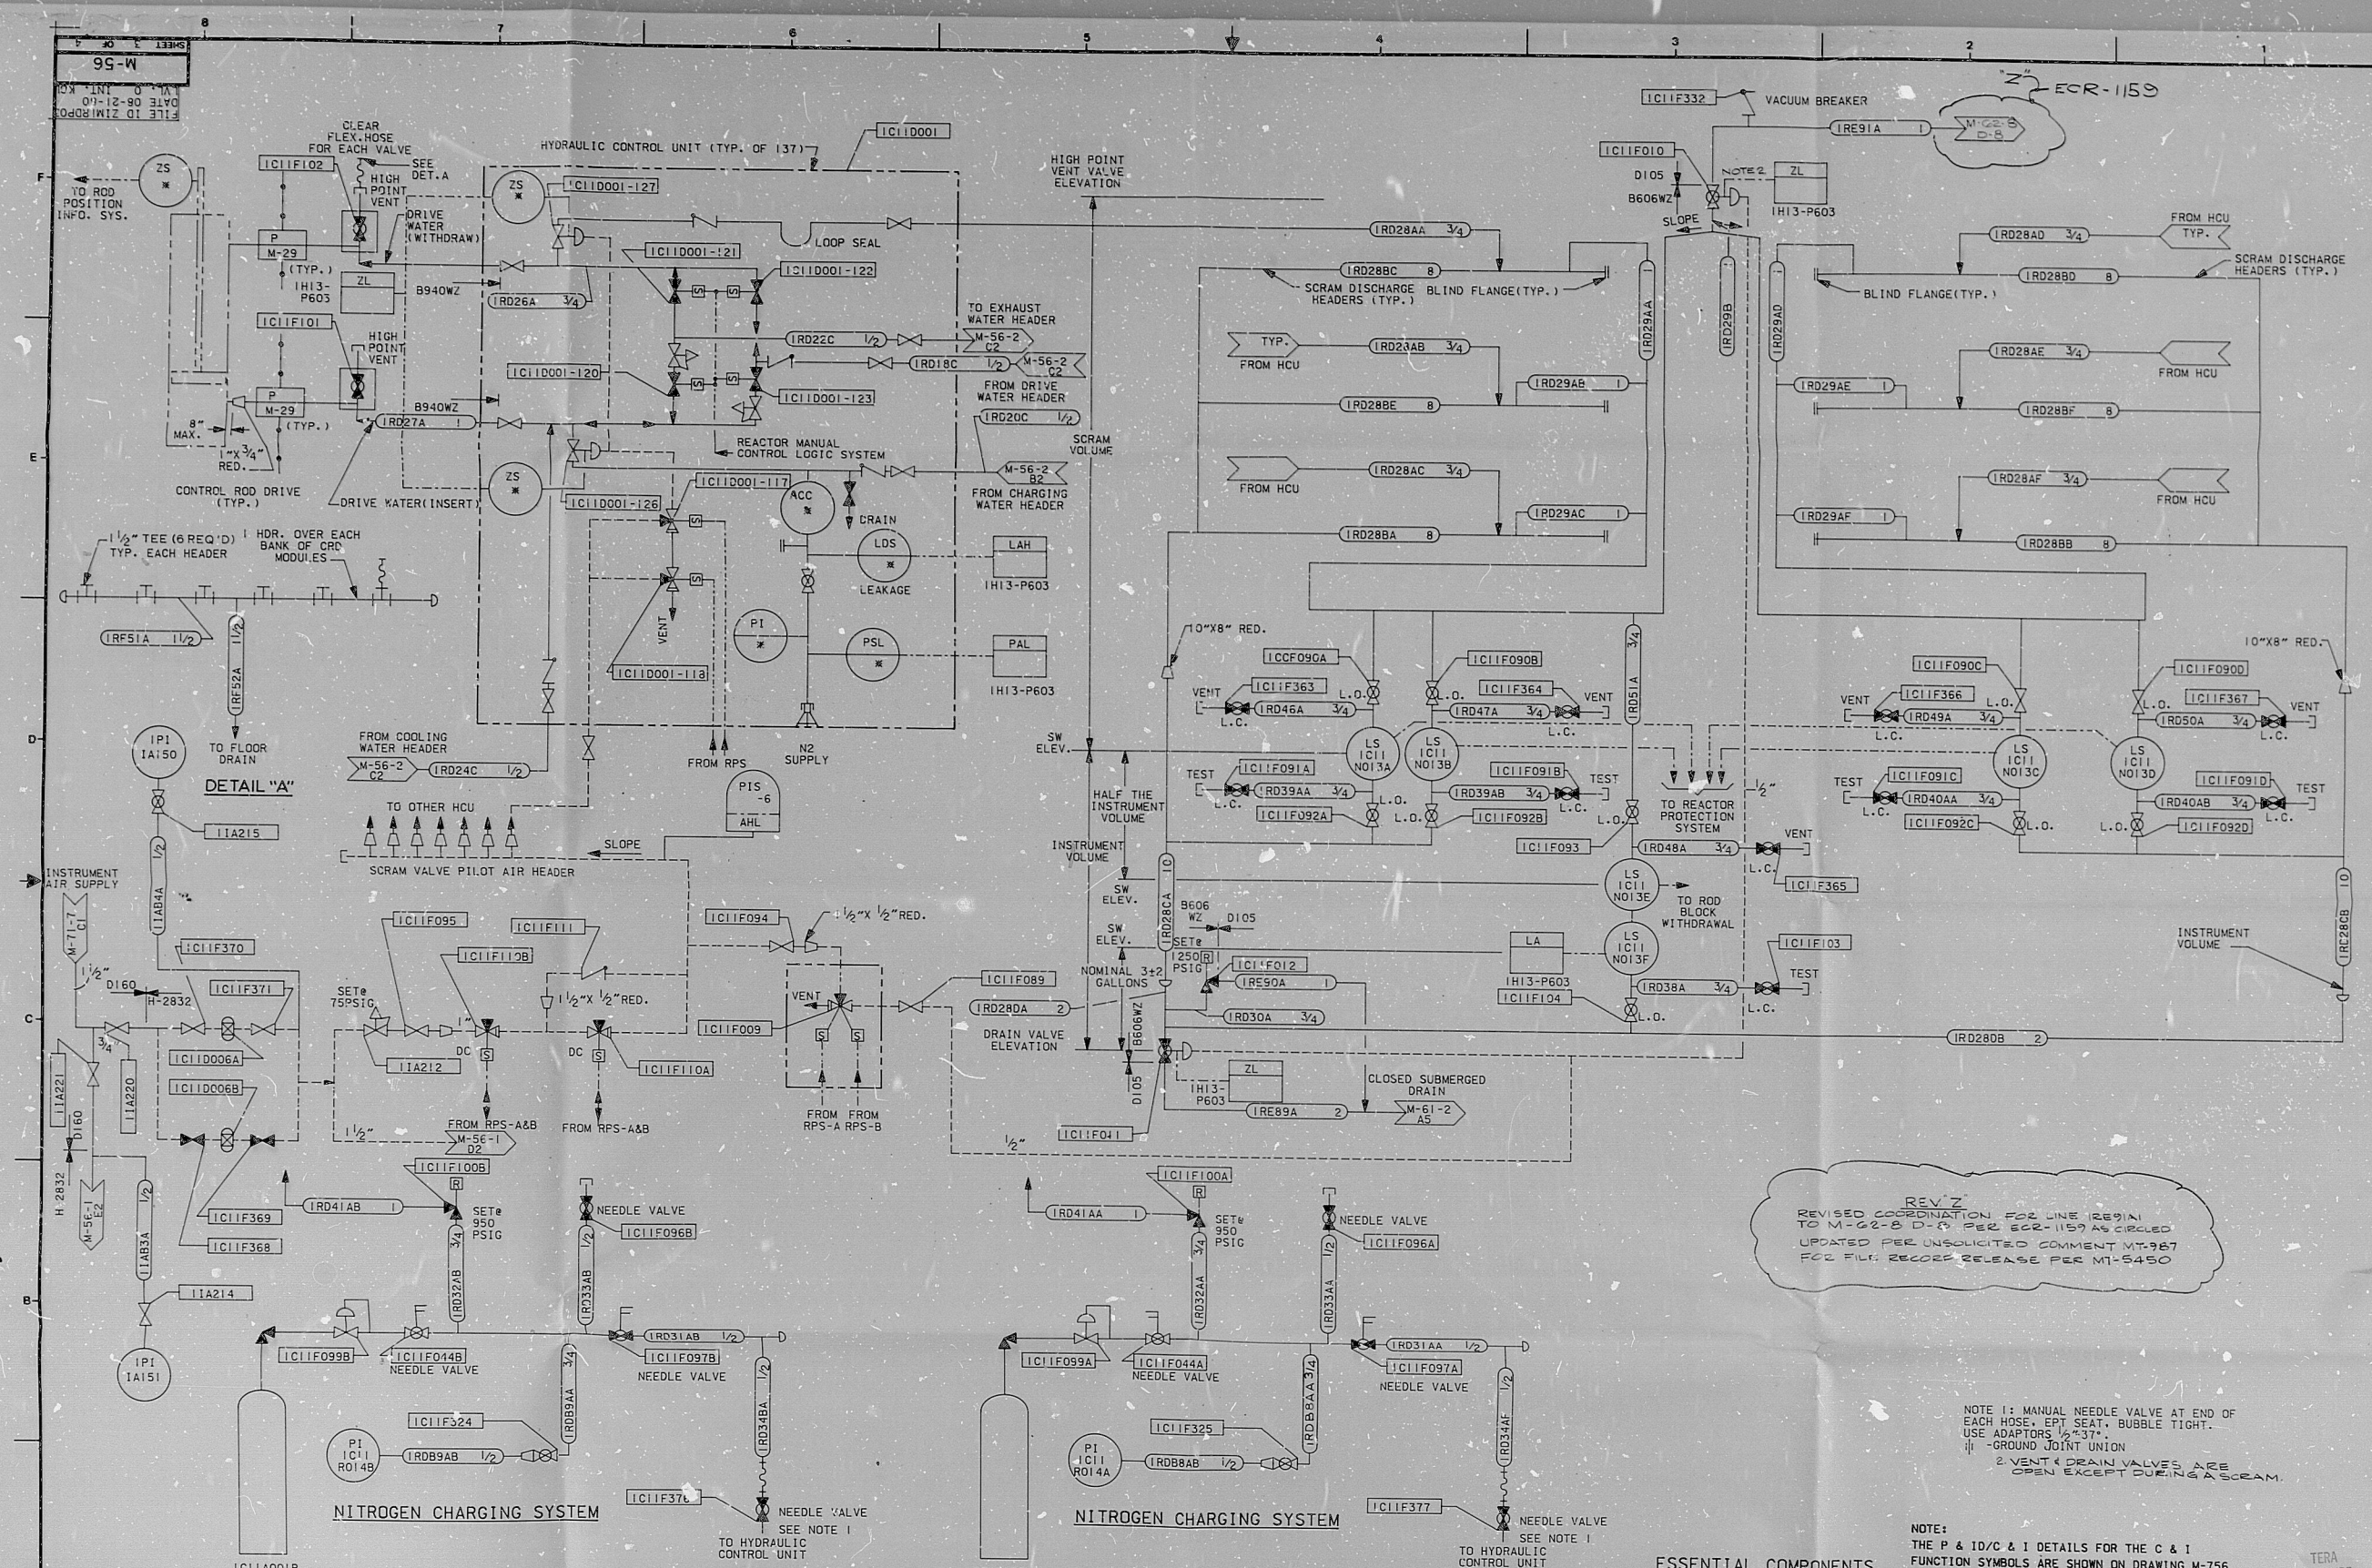

REV. Z
REVISED COORDINATION FOR LINE 1291A
TO M-22-B D-1 PER ECR-1157 AS CIRCLED
UPDATED PER UNSOLICITED COMMENT MT-967
FOR FILE, RECORD RELEASE PER MT-5450

NOTE 1: MANUAL NEEDLE VALVE AT END OF
EACH HOSE, EPT SEAT, BUBBLE TIGHT.
USE ADAPTORS 1/2\"/>

NOTE:
THE P & ID/C & I DETAILS FOR THE C & I
FUNCTION SYMBOLS ARE SHOWN ON DRAWING M-756
UNLESS OTHERWISE NOTED. SHEET NUMBER & DETAIL
REFERENCE ARE SHOWN IN THE FUNCTION SYMBOL.

ESSENTIAL COMPONENTS
INCLUDED

DRAWING RELEASE RECORD												DRAWING RELEASE RECORD												SCALE		PROJECT		DRAWING NO.		REV	
REV.	DATE REL'D	PREPARED	REVIEWED	APPROVED	PURPOSE	FILM	REV.	DATE REL'D	PREPARED	REVIEWED	APPROVED	PURPOSE	FILM																		
1	1-15-81	D. E. Romano	J. Romano	J. Romano	LEGRAWN SEE NOTE																										
		</																													

SARGENT & LUNDY
ENGINEERS
CHICAGO
DRAWING NO. M-56
REV. Z
SHEET 3 OF 4

RDS-PDR

8104010389

