


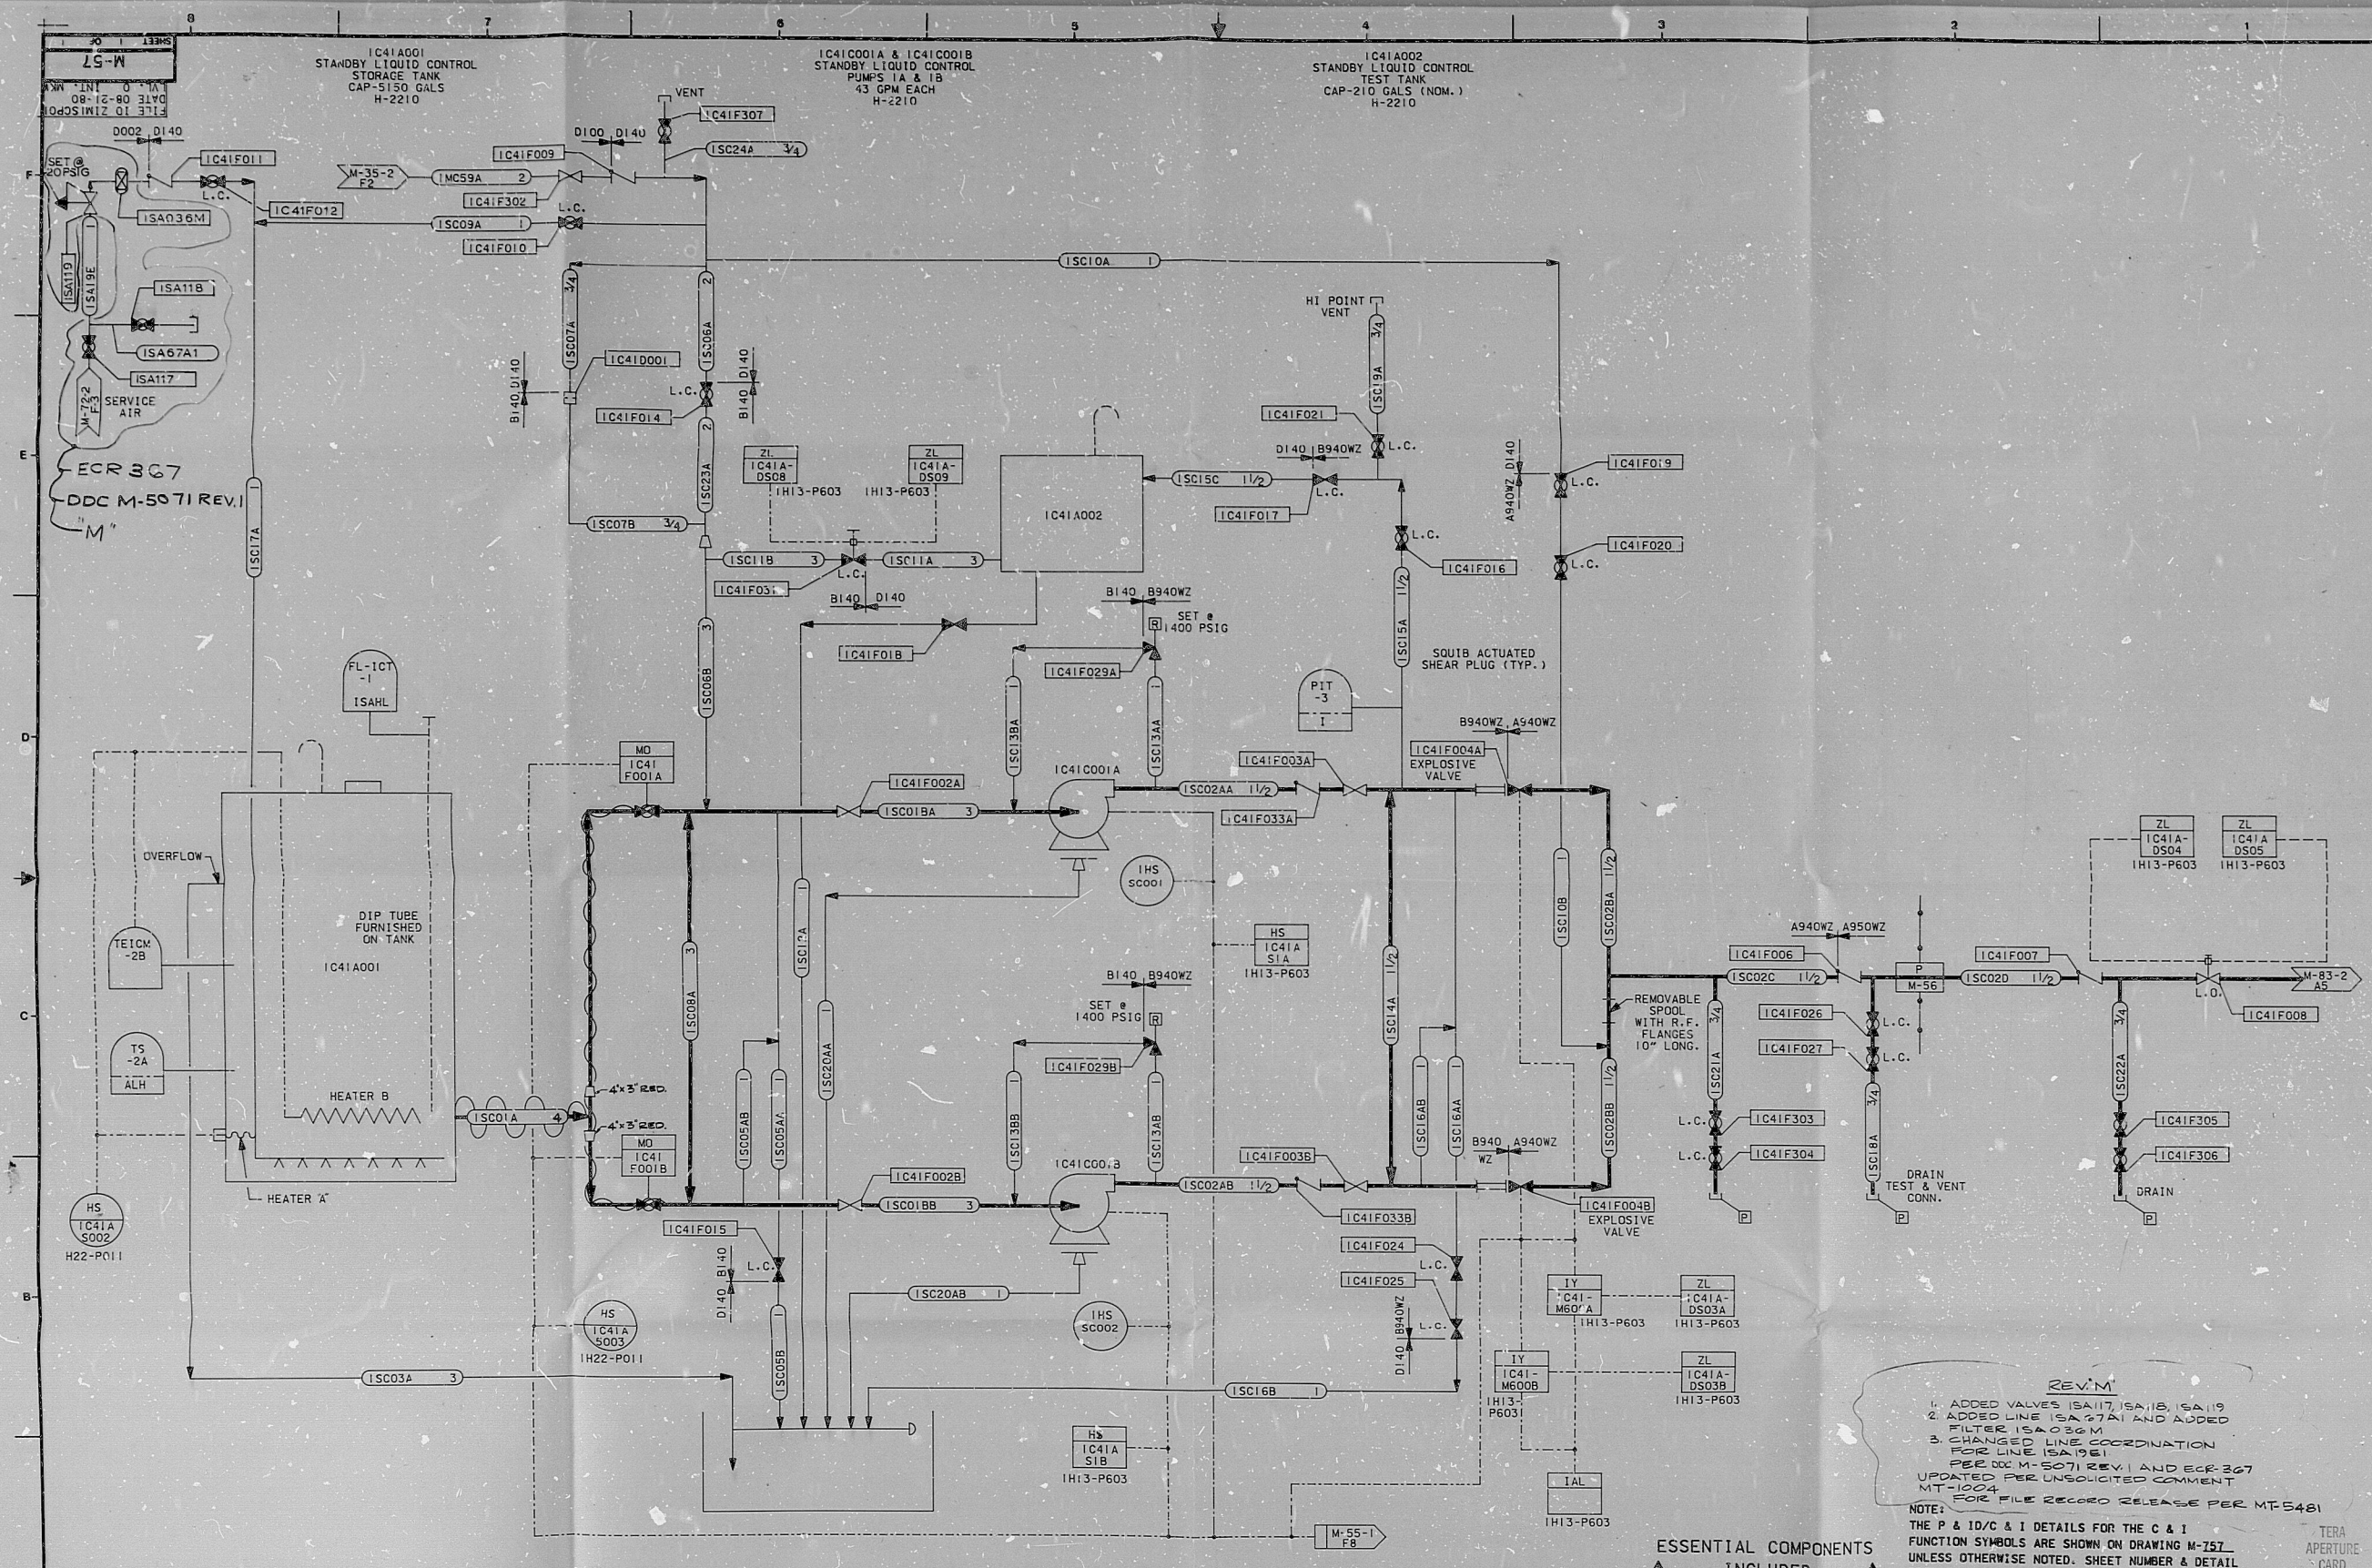

REV. M
1. ADDED VALVES ISA117, ISA118, ISA119
2. ADDED LINE ISA27A1 AND ADDED
FILTER ISA036M
3. CHANGED LINE COORDINATION
FOR LINE ISA1961
PER M-5071 REV. I AND ECR-367
UPDATED PER UNSOLICITED COMMENT
MT-1004
FOR FILE RECORD RELEASE PER MT-5481

NOTE:
THE P & ID/C & I DETAILS FOR THE C & I
FUNCTION SYMBOLS ARE SHOWN ON DRAWING M-752.
UNLESS OTHERWISE NOTED, SHEET NUMBER & DETAIL
REFERENCE ARE SHOWN IN THE FUNCTION SYMBOL.

ESSENTIAL COMPONENTS
INCLUDED

DRAWING RELEASE RECORD						DRAWING RELEASE RECORD					
REV.	DATE	RELD.	PREPARED	REVIEWED	APPROVED	PURPOSE	REV.	DATE	RELD.	PREPARED	REVIEWED
L	11-6-80		R. R. Rawlins			REDRAWN SEE NOTE FOR REV.					
M	1-21-81		R. R. Rawlins			SEE NOTE FOR REV.					

SCALE
NONE
PROJECT
NUMBER
4130-00

**P & ID
STANDBY LIQUID
CONTROL (SC)**
H. H. ZIMMER NUCLEAR POWER STATION UNIT I
THE CINCINNATI GAS & ELECTRIC CO.
COLUMBUS & SOUTHERN OHIO ELECTRIC CO.
THE DAYTON POWER & LIGHT CO.

SARGENT & LUNDY
ENGINEERS
CHICAGO
DRAWING NO.
M-57
SHEET 1 OF 1

RDS-RDR

8104010390

