

22

17

11


8.5

11

17

22

34

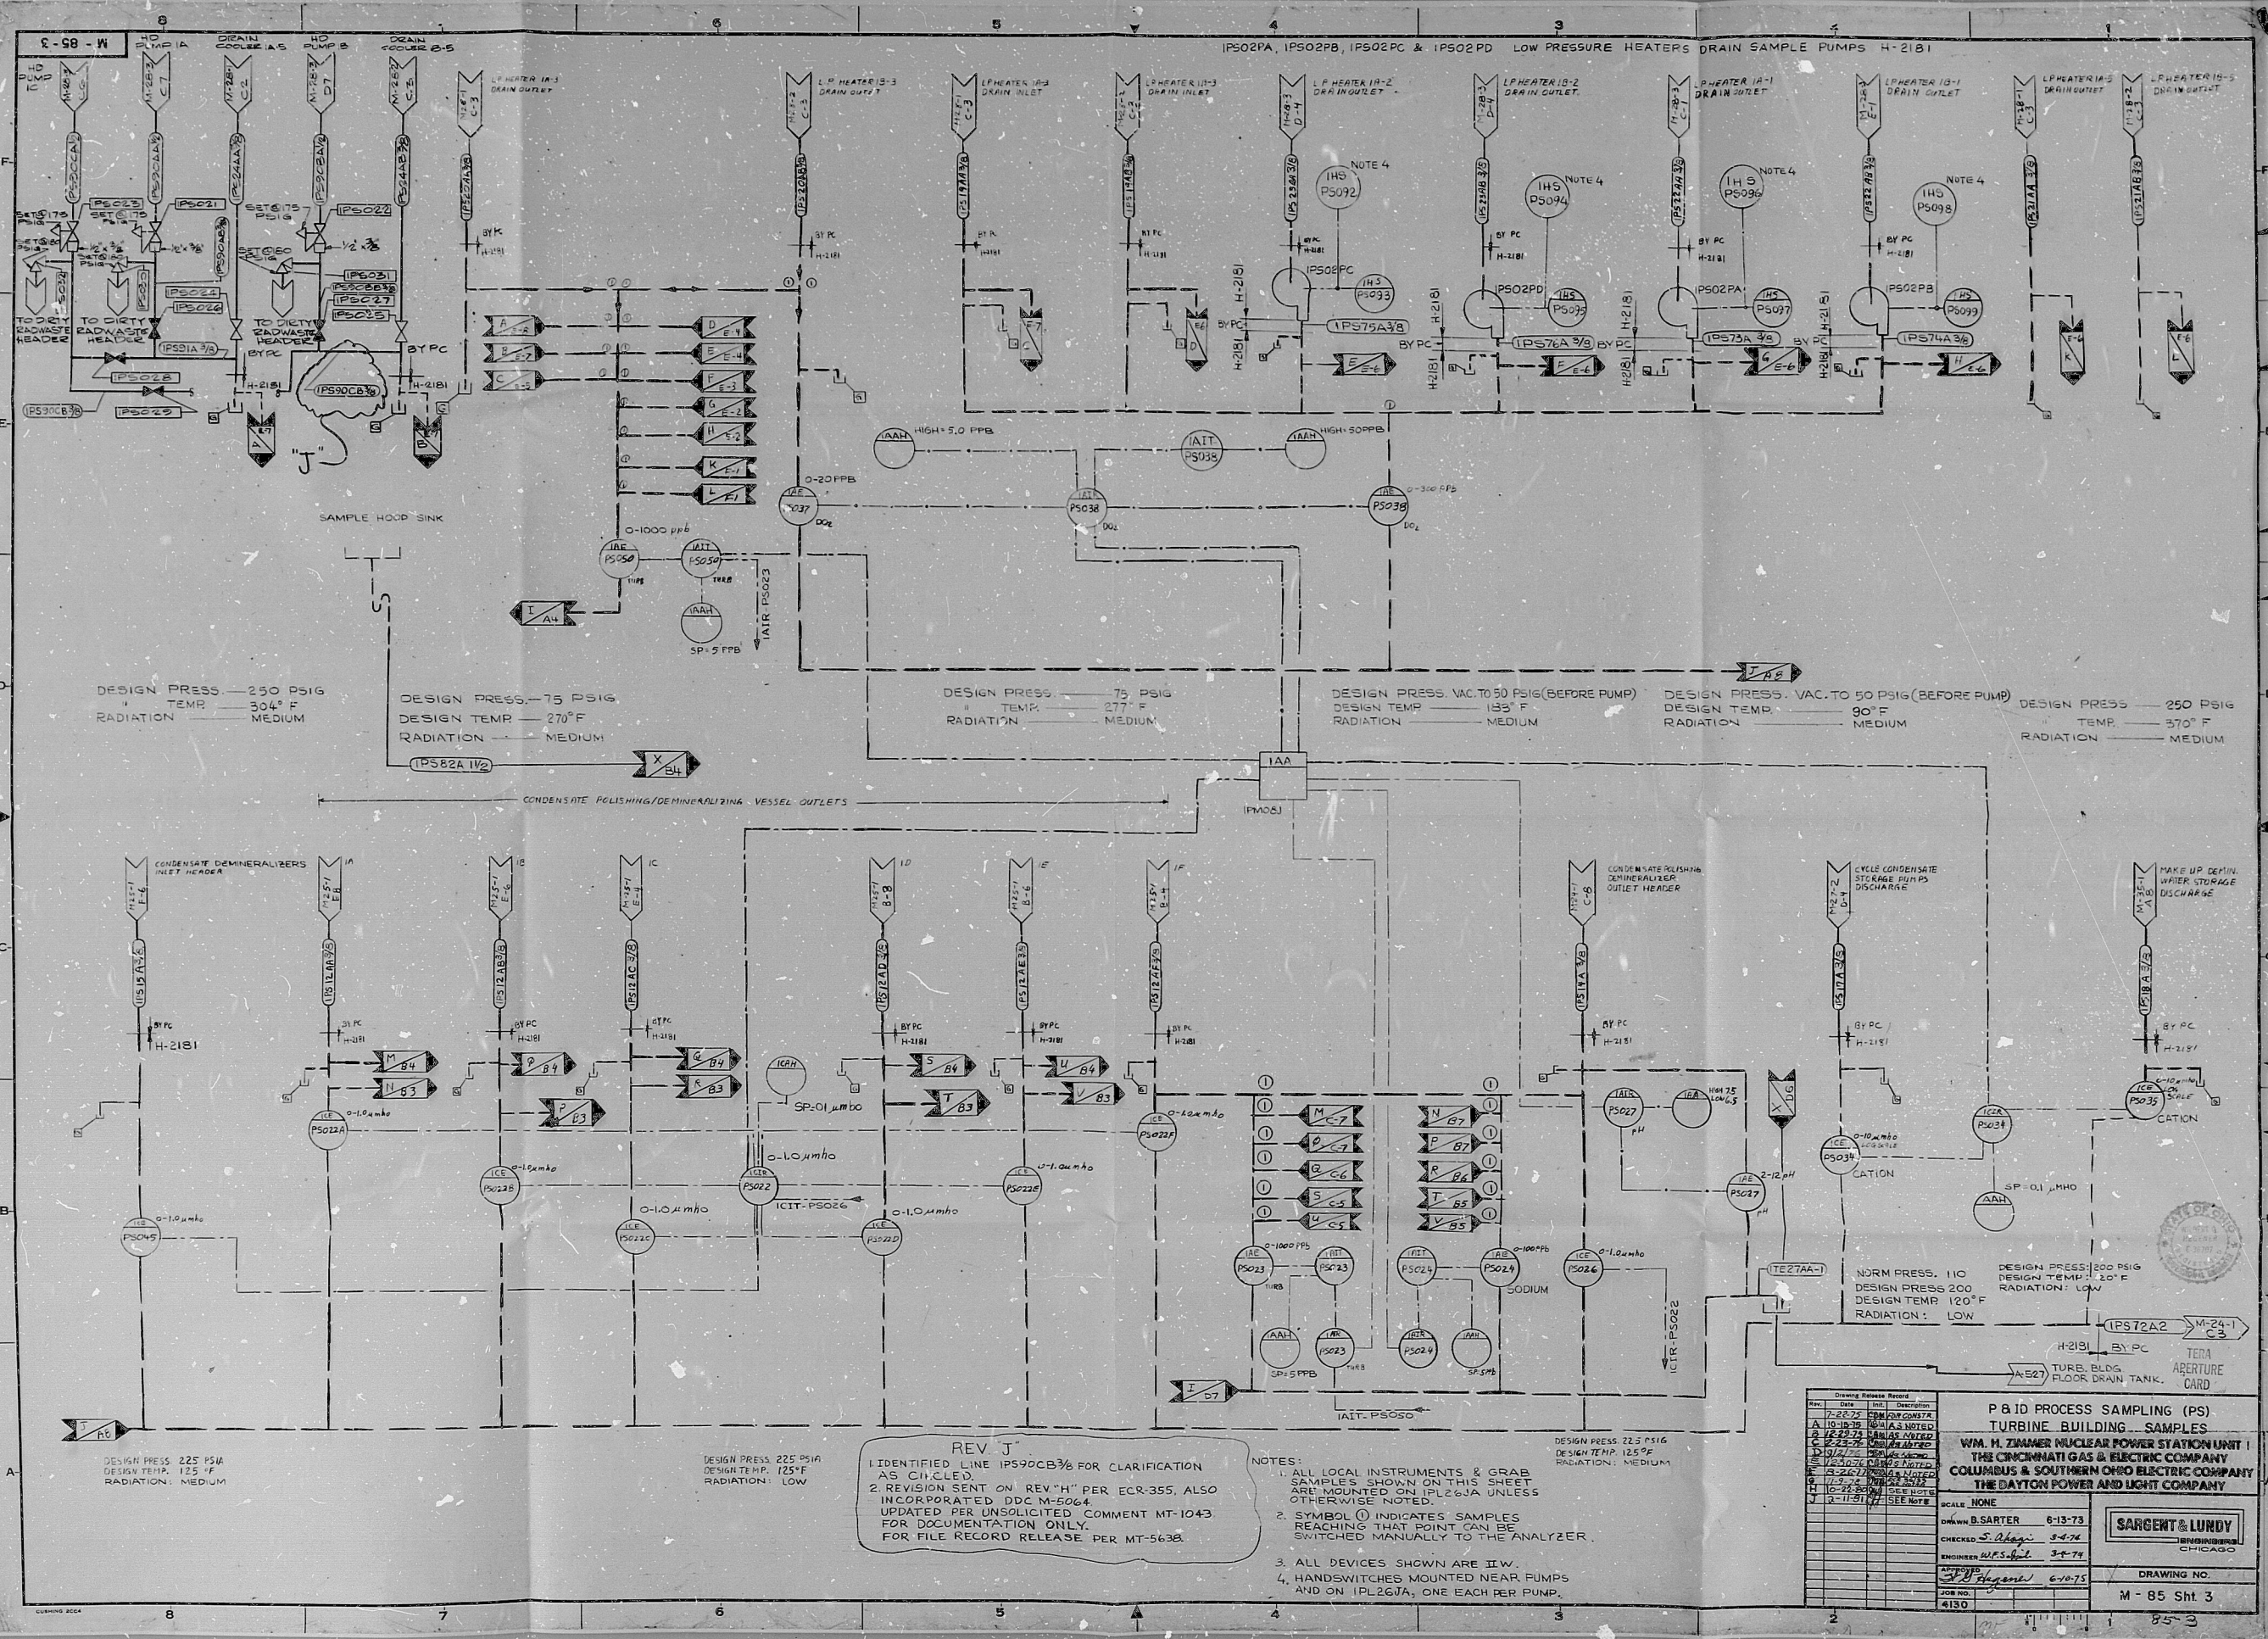

Drawing Revisions			
No.	Date	By	Description
1	7-25-73	W.H. Zimmer	FOR CONSTRUCTION
2	10-10-73	W.H. Zimmer	REVISIONS
3	11-15-73	W.H. Zimmer	REVISIONS
4	12-15-73	W.H. Zimmer	REVISIONS
5	1-15-74	W.H. Zimmer	REVISIONS
6	2-15-74	W.H. Zimmer	REVISIONS
7	3-15-74	W.H. Zimmer	REVISIONS
8	4-15-74	W.H. Zimmer	REVISIONS
9	5-15-74	W.H. Zimmer	REVISIONS
10	6-15-74	W.H. Zimmer	REVISIONS
11	7-15-74	W.H. Zimmer	REVISIONS
12	8-15-74	W.H. Zimmer	REVISIONS
13	9-15-74	W.H. Zimmer	REVISIONS
14	10-15-74	W.H. Zimmer	REVISIONS
15	11-15-74	W.H. Zimmer	REVISIONS
16	12-15-74	W.H. Zimmer	REVISIONS
17	1-15-75	W.H. Zimmer	REVISIONS
18	2-15-75	W.H. Zimmer	REVISIONS
19	3-15-75	W.H. Zimmer	REVISIONS
20	4-15-75	W.H. Zimmer	REVISIONS
21	5-15-75	W.H. Zimmer	REVISIONS
22	6-15-75	W.H. Zimmer	REVISIONS
23	7-15-75	W.H. Zimmer	REVISIONS
24	8-15-75	W.H. Zimmer	REVISIONS
25	9-15-75	W.H. Zimmer	REVISIONS
26	10-15-75	W.H. Zimmer	REVISIONS
27	11-15-75	W.H. Zimmer	REVISIONS
28	12-15-75	W.H. Zimmer	REVISIONS
29	1-15-76	W.H. Zimmer	REVISIONS
30	2-15-76	W.H. Zimmer	REVISIONS
31	3-15-76	W.H. Zimmer	REVISIONS
32	4-15-76	W.H. Zimmer	REVISIONS
33	5-15-76	W.H. Zimmer	REVISIONS
34	6-15-76	W.H. Zimmer	REVISIONS
35	7-15-76	W.H. Zimmer	REVISIONS
36	8-15-76	W.H. Zimmer	REVISIONS
37	9-15-76	W.H. Zimmer	REVISIONS
38	10-15-76	W.H. Zimmer	REVISIONS
39	11-15-76	W.H. Zimmer	REVISIONS
40	12-15-76	W.H. Zimmer	REVISIONS
41	1-15-77	W.H. Zimmer	REVISIONS
42	2-15-77	W.H. Zimmer	REVISIONS
43	3-15-77	W.H. Zimmer	REVISIONS
44	4-15-77	W.H. Zimmer	REVISIONS
45	5-15-77	W.H. Zimmer	REVISIONS
46	6-15-77	W.H. Zimmer	REVISIONS
47	7-15-77	W.H. Zimmer	REVISIONS
48	8-15-77	W.H. Zimmer	REVISIONS
49	9-15-77	W.H. Zimmer	REVISIONS
50	10-15-77	W.H. Zimmer	REVISIONS
51	11-15-77	W.H. Zimmer	REVISIONS
52	12-15-77	W.H. Zimmer	REVISIONS
53	1-15-78	W.H. Zimmer	REVISIONS
54	2-15-78	W.H. Zimmer	REVISIONS
55	3-15-78	W.H. Zimmer	REVISIONS
56	4-15-78	W.H. Zimmer	REVISIONS
57	5-15-78	W.H. Zimmer	REVISIONS
58	6-15-78	W.H. Zimmer	REVISIONS
59	7-15-78	W.H. Zimmer	REVISIONS
60	8-15-78	W.H. Zimmer	REVISIONS
61	9-15-78	W.H. Zimmer	REVISIONS
62	10-15-78	W.H. Zimmer	REVISIONS
63	11-15-78	W.H. Zimmer	REVISIONS
64	12-15-78	W.H. Zimmer	REVISIONS
65	1-15-79	W.H. Zimmer	REVISIONS
66	2-15-79	W.H. Zimmer	REVISIONS
67	3-15-79	W.H. Zimmer	REVISIONS
68	4-15-79	W.H. Zimmer	REVISIONS
69	5-15-79	W.H. Zimmer	REVISIONS
70	6-15-79	W.H. Zimmer	REVISIONS
71	7-15-79	W.H. Zimmer	REVISIONS
72	8-15-79	W.H. Zimmer	REVISIONS
73	9-15-79	W.H. Zimmer	REVISIONS
74	10-15-79	W.H. Zimmer	REVISIONS
75	11-15-79	W.H. Zimmer	REVISIONS
76	12-15-79	W.H. Zimmer	REVISIONS
77	1-15-80	W.H. Zimmer	REVISIONS
78	2-15-80	W.H. Zimmer	REVISIONS
79	3-15-80	W.H. Zimmer	REVISIONS
80	4-15-80	W.H. Zimmer	REVISIONS
81	5-15-80	W.H. Zimmer	REVISIONS
82	6-15-80	W.H. Zimmer	REVISIONS
83	7-15-80	W.H. Zimmer	REVISIONS
84	8-15-80	W.H. Zimmer	REVISIONS
85	9-15-80	W.H. Zimmer	REVISIONS
86	10-15-80	W.H. Zimmer	REVISIONS
87	11-15-80	W.H. Zimmer	REVISIONS
88	12-15-80	W.H. Zimmer	REVISIONS
89	1-15-81	W.H. Zimmer	REVISIONS
90	2-15-81	W.H. Zimmer	REVISIONS
91	3-15-81	W.H. Zimmer	REVISIONS
92	4-15-81	W.H. Zimmer	REVISIONS
93	5-15-81	W.H. Zimmer	REVISIONS
94	6-15-81	W.H. Zimmer	REVISIONS
95	7-15-81	W.H. Zimmer	REVISIONS
96	8-15-81	W.H. Zimmer	REVISIONS
97	9-15-81	W.H. Zimmer	REVISIONS
98	10-15-81	W.H. Zimmer	REVISIONS
99	11-15-81	W.H. Zimmer	REVISIONS
100	12-15-81	W.H. Zimmer	REVISIONS

P&ID PROCESS SAMPLING (PS)
TURBINE BUILDING - SAMPLES
WM. H. ZIMMER NUCLEAR POWER STATION UNIT 1
THE CINCINNATI GAS & ELECTRIC COMPANY
COLUMBUS & SOUTHERN OHIO ELECTRIC COMPANY
THE DAYTON POWER AND LIGHT COMPANY

SCALE: NONE
DRAWN: B. SARTER 6-13-73
CHECKED: S. B. B. 5-4-74
ENGINEER: W. H. ZIMMER 3-4-74
DATE: 6-13-73
JOB NO.: 4130
DRAWING NO.: M-85 Sht 3
85-3

RDS-PDR

8104010425

