


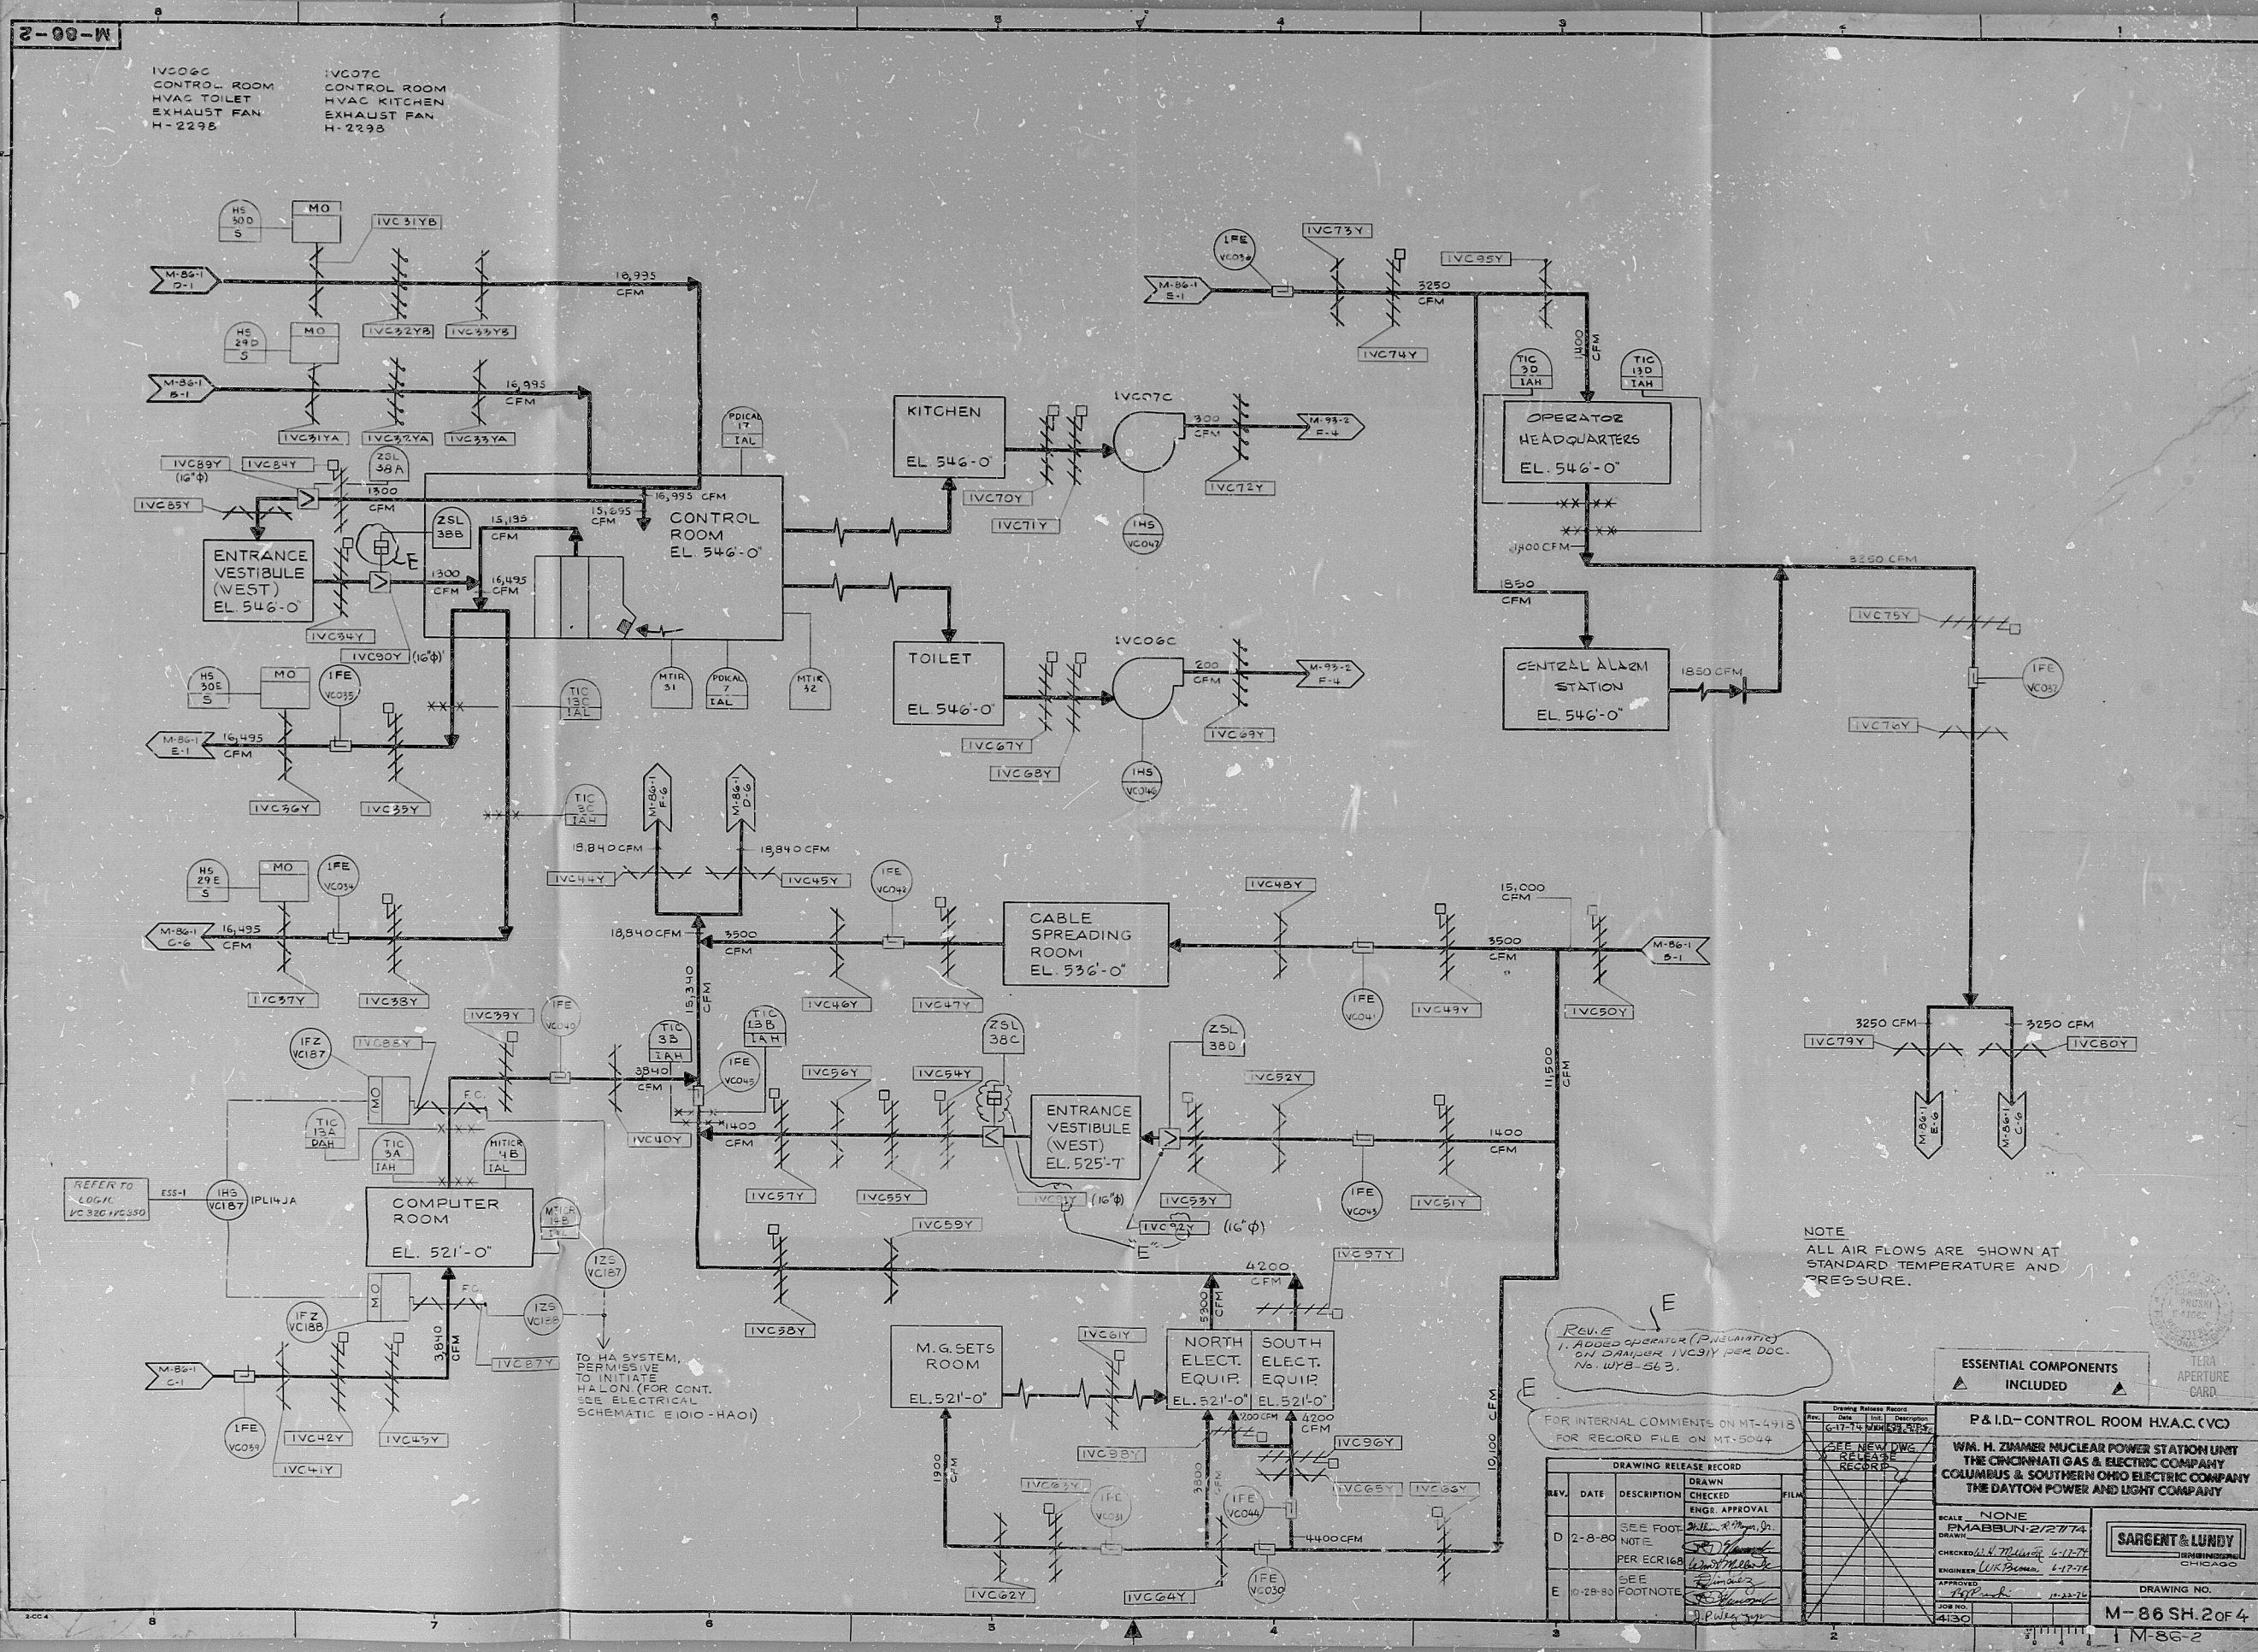

NOTE:
ALL AIR FLOWS ARE SHOWN AT
STANDARD TEMPERATURE AND
PRESSURE.

Revise
1. ADDED OPERATOR (PNEUMATIC)
ON DAMPER IVC31Y PER DOC.
No. WYB-563.

FOR INTERNAL COMMENTS ON MT-4918
FOR RECORD FILE ON MT-5044

DRAWING RELEASE RECORD		
REV.	DATE	DESCRIPTION
D	2-8-80	SEE FOOTNOTE PER ECR 168
E	10-28-80	SEE FOOTNOTE

Drawing Release Record		
Rev.	Date	Description
1	11-22-79	SEE NEW DWS RELEASE RECORD
2	11-22-79	SEE NEW DWS RELEASE RECORD
3	11-22-79	SEE NEW DWS RELEASE RECORD
4	11-22-79	SEE NEW DWS RELEASE RECORD
5	11-22-79	SEE NEW DWS RELEASE RECORD
6	11-22-79	SEE NEW DWS RELEASE RECORD
7	11-22-79	SEE NEW DWS RELEASE RECORD
8	11-22-79	SEE NEW DWS RELEASE RECORD
9	11-22-79	SEE NEW DWS RELEASE RECORD
10	11-22-79	SEE NEW DWS RELEASE RECORD
11	11-22-79	SEE NEW DWS RELEASE RECORD
12	11-22-79	SEE NEW DWS RELEASE RECORD
13	11-22-79	SEE NEW DWS RELEASE RECORD
14	11-22-79	SEE NEW DWS RELEASE RECORD
15	11-22-79	SEE NEW DWS RELEASE RECORD
16	11-22-79	SEE NEW DWS RELEASE RECORD
17	11-22-79	SEE NEW DWS RELEASE RECORD
18	11-22-79	SEE NEW DWS RELEASE RECORD
19	11-22-79	SEE NEW DWS RELEASE RECORD
20	11-22-79	SEE NEW DWS RELEASE RECORD

ESSENTIAL COMPONENTS INCLUDED

P&ID-CONTROL ROOM HVAC CVCO

WM. H. ZIMMER NUCLEAR POWER STATION UNIT
THE CINCINNATI GAS & ELECTRIC COMPANY
COLUMBUS & SOUTHERN OHIO ELECTRIC COMPANY
THE DAYTON POWER AND LIGHT COMPANY

SCALE: NONE

DATE: 2/27/74

CHECKED: [Signature]

ENGINEER: [Signature]

DRAWING NO. M-86 SH. 2 of 4

1 M-86-2

RDS-RDR

8104010428

