


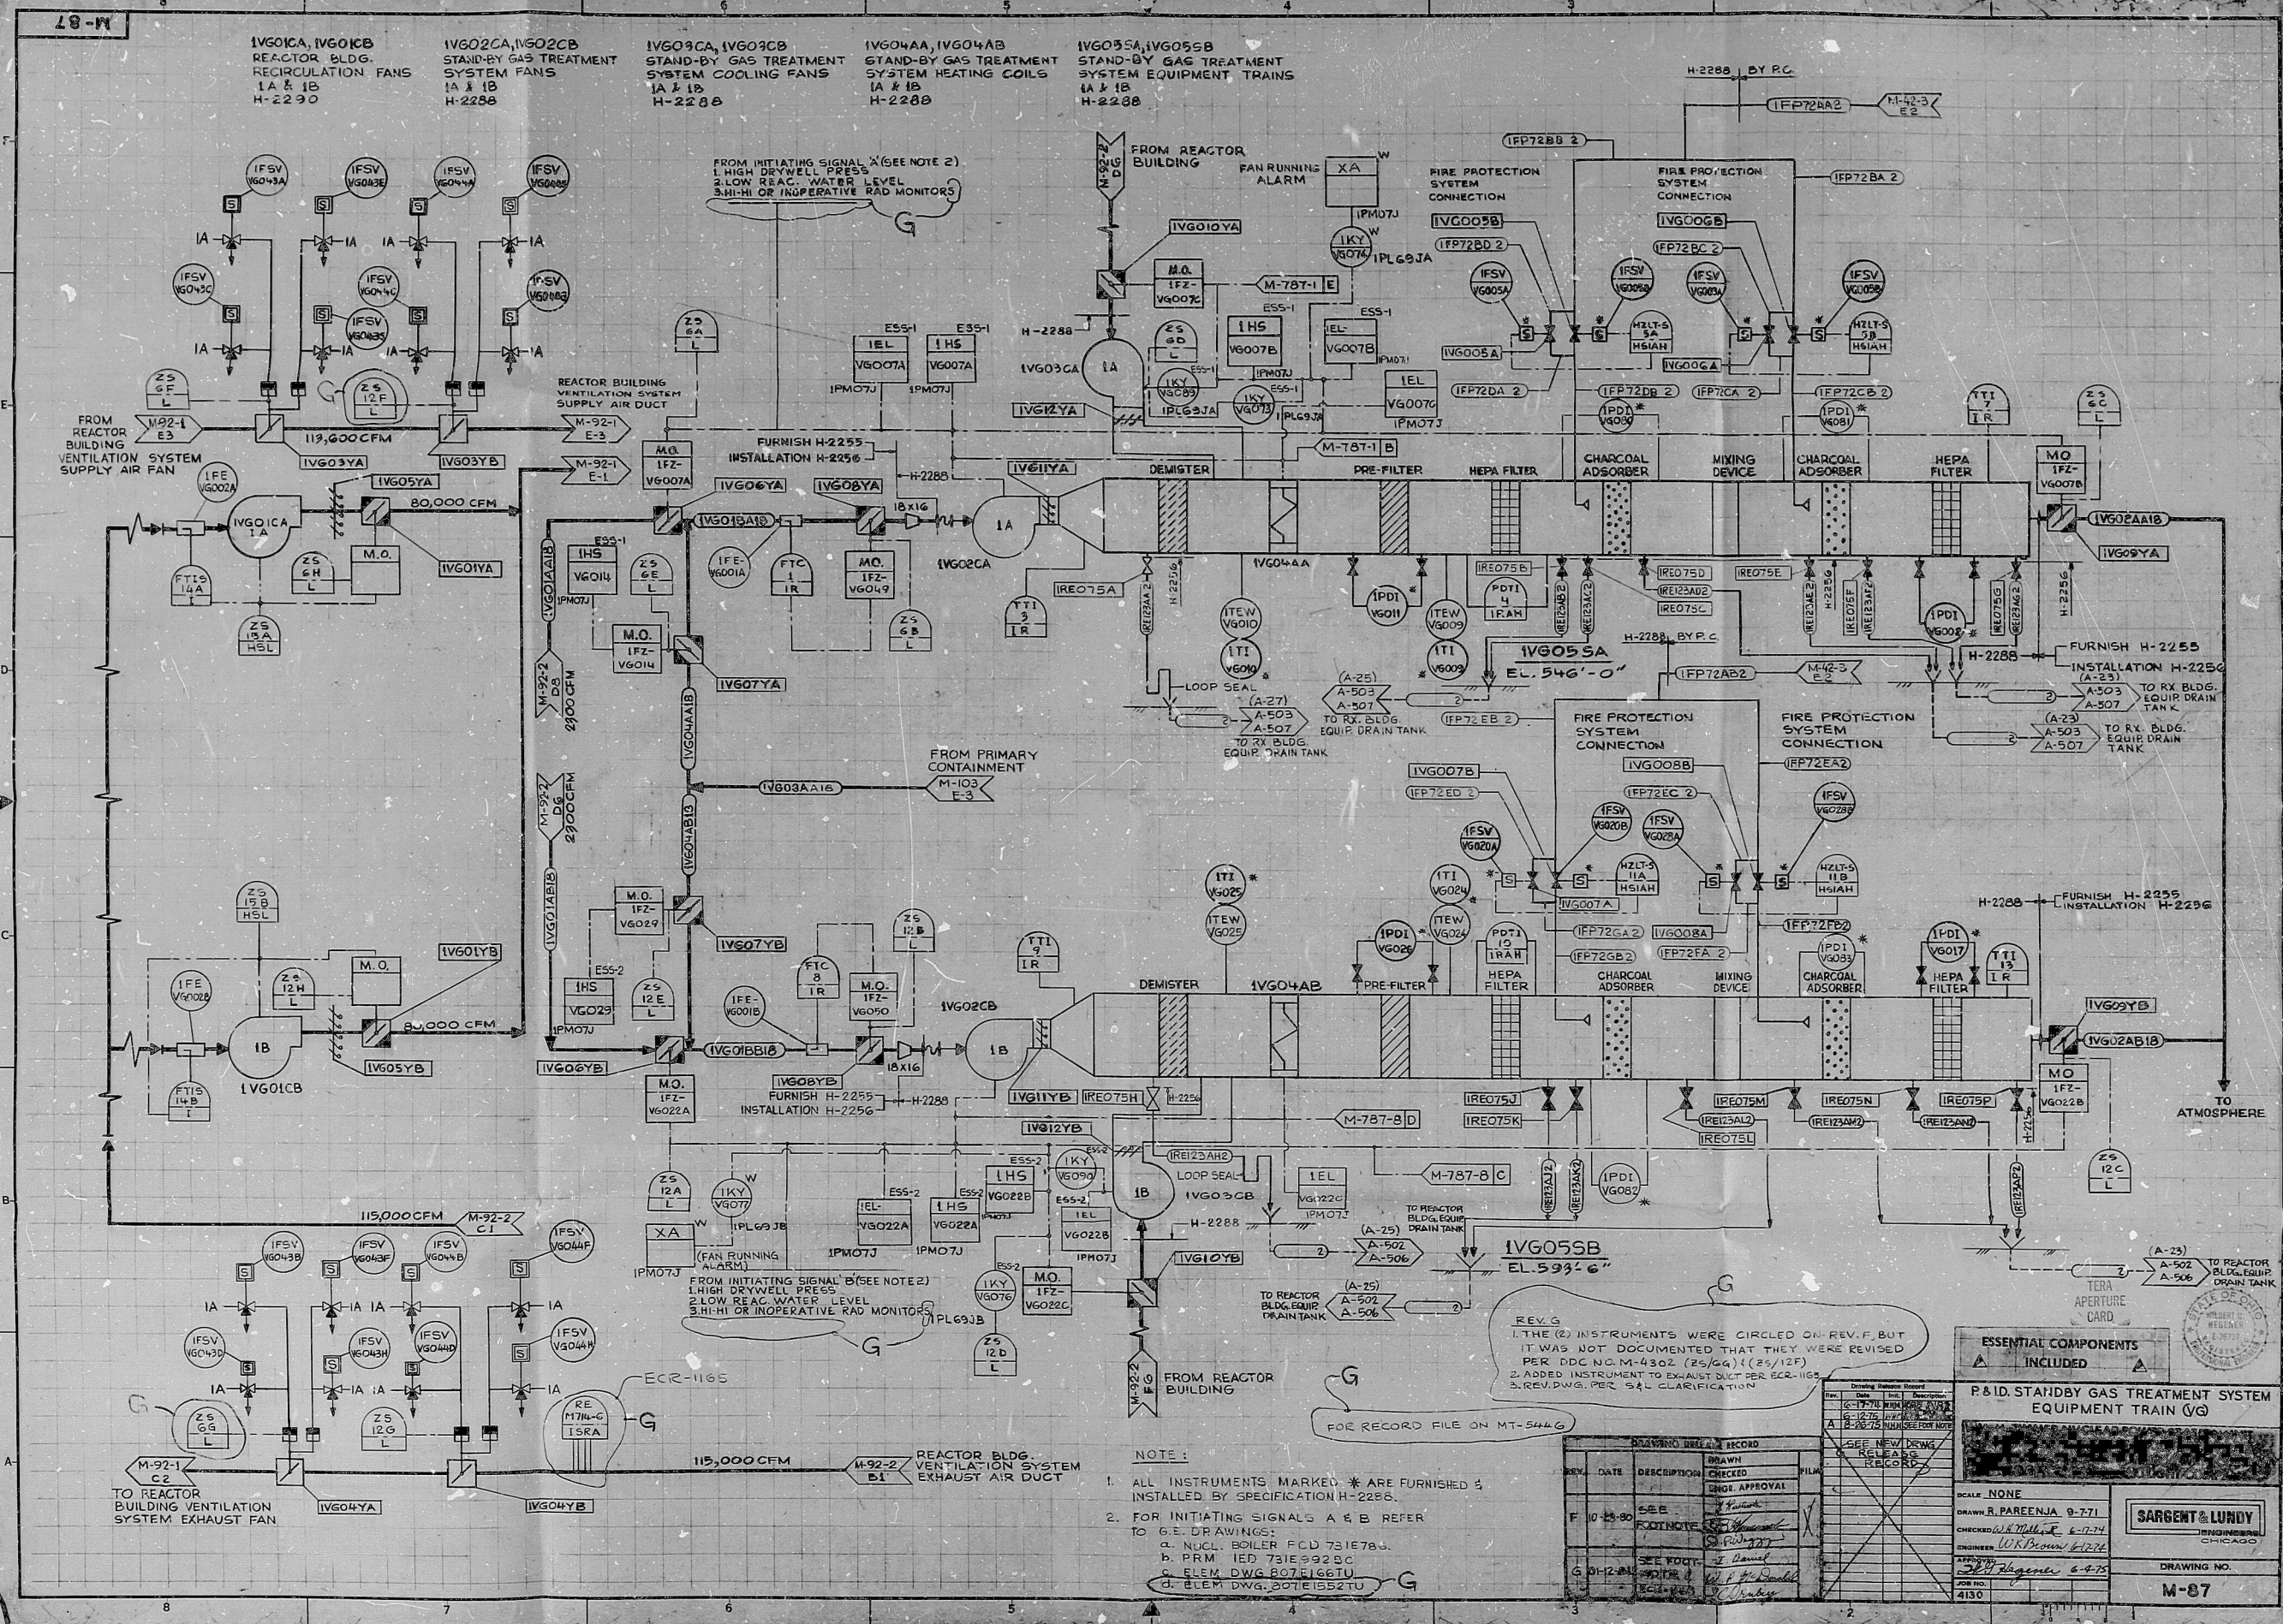

NOTE:  
1. ALL INSTRUMENTS MARKED \* ARE FURNISHED & INSTALLED BY SPECIFICATION H-2288.  
2. FOR INITIATING SIGNALS A & B REFER TO G.E. DRAWINGS:  
a. NUCL. BOILER FCD 731678J.  
b. PRM. IED 731E 992BC  
c. ELEM. DWG. 807E166TU  
d. ELEM. DWG. 807E1552TU

REV. G  
1. THE (2) INSTRUMENTS WERE CIRCLED ON REV. F, BUT IT WAS NOT DOCUMENTED THAT THEY WERE REVISED PER DDG NO. M-4302 (25/GG) (25/12F)  
2. ADDED INSTRUMENT TO EXHAUST DUCT PER G.E. 1105  
3. REV. DWG. PER S&L CLARIFICATION

**ESSENTIAL COMPONENTS INCLUDED**

**P&ID STANDBY GAS TREATMENT SYSTEM EQUIPMENT TRAIN (VG)**

SCALE: NONE  
DRAWN: R. PAREENJA 9-771  
CHECKED: W. H. HARRIS 6-17-74  
ENGINEER: L. R. BROWN 6-17-74  
DATE: 6-17-74  
JOB NO. 4130  
DRAWING NO. M-87

**SARGENT & LUNDY**  
ENGINEERS  
CHICAGO

| REV. | DATE     | DESCRIPTION     | CHECKED     | APPROVAL    |
|------|----------|-----------------|-------------|-------------|
| F    | 10-13-80 | SEE EXPLANATION | [Signature] | [Signature] |
| G    | 04-28-81 | SEE FOOTNOTES   | [Signature] | [Signature] |

2505-PO12

8104010431

