




REV.
1. DELETED INSTRUMENT FROM VENT STACK PER ECR-1165.
2. REVISED DWG. PER S&L CLARIFICATION.

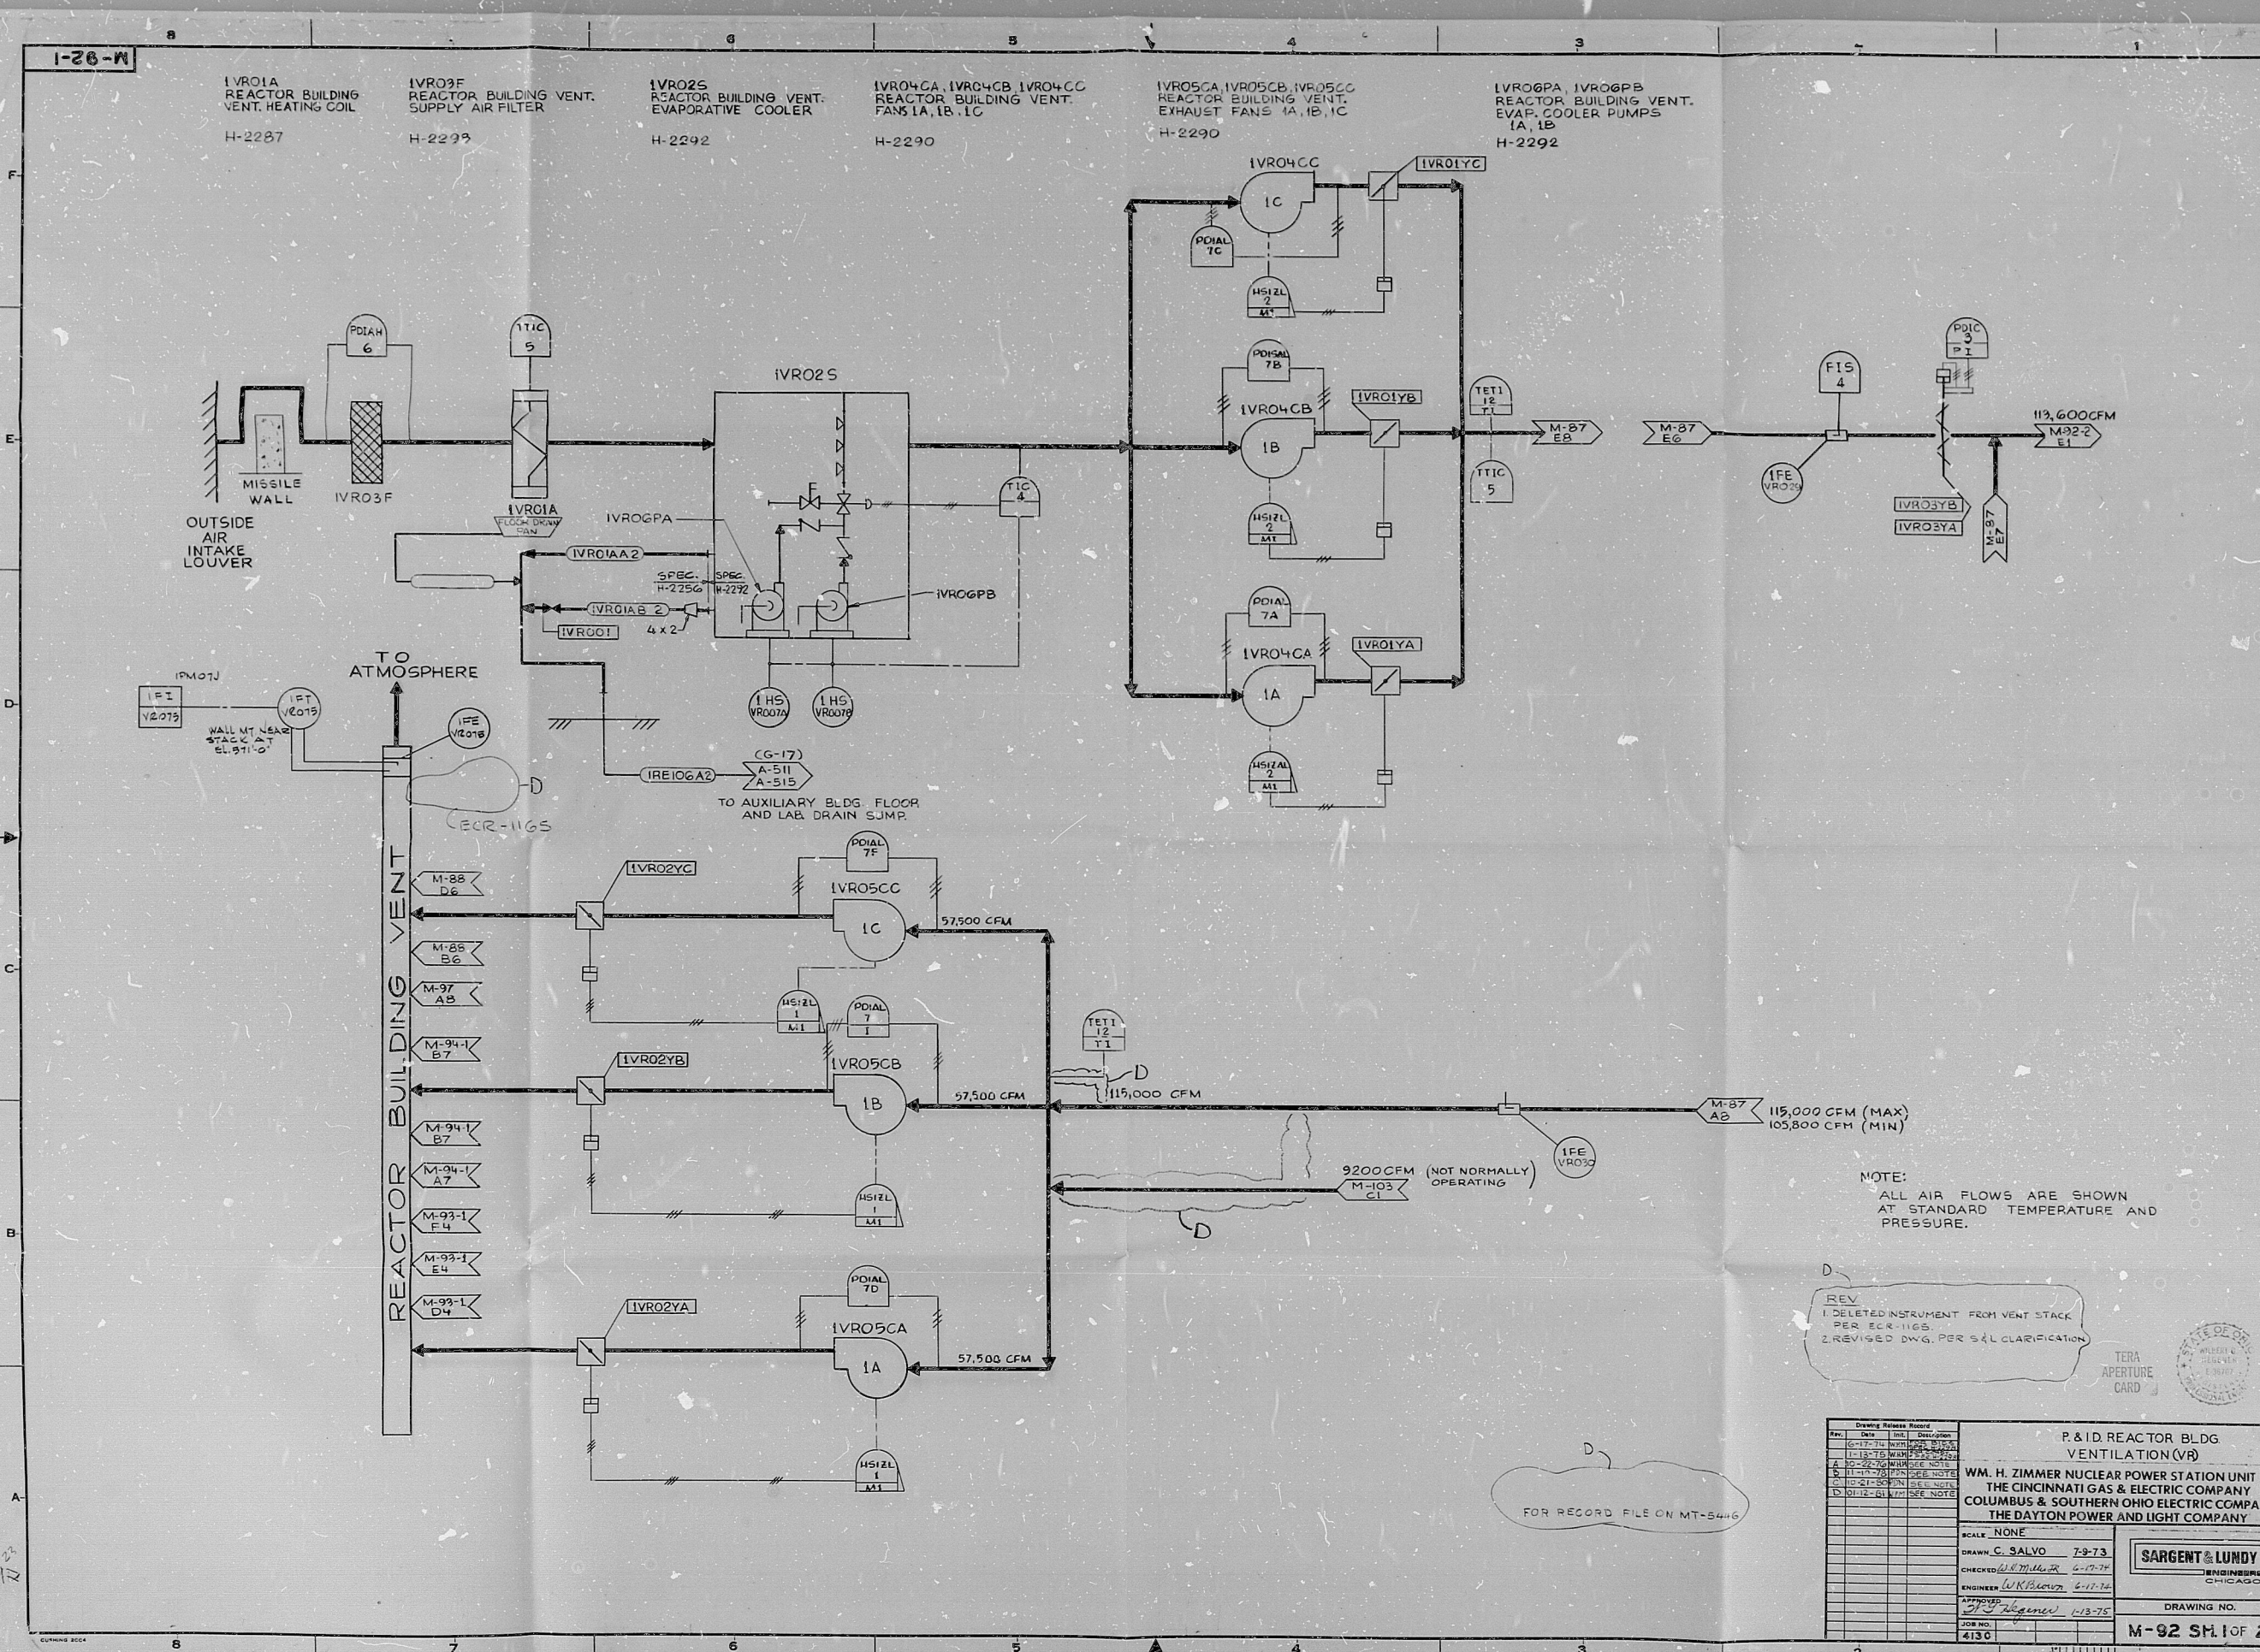

Drawing Release Record			
Rev.	Date	Int.	Description
1	6-17-74	W.H.Z.	ISSUED FOR CONSTRUCTION
2	1-18-75	W.H.Z.	ISSUED FOR CONSTRUCTION
3	10-20-75	W.H.Z.	ISSUED FOR CONSTRUCTION
4	11-14-75	W.H.Z.	ISSUED FOR CONSTRUCTION
5	12-21-75	W.H.Z.	ISSUED FOR CONSTRUCTION
6	01-12-76	W.H.Z.	ISSUED FOR CONSTRUCTION

P&ID REACTOR BLDG VENTILATION (VR)	
WM. H. ZIMMER NUCLEAR POWER STATION UNIT	
THE CINCINNATI GAS & ELECTRIC COMPANY	
COLUMBUS & SOUTHERN OHIO ELECTRIC COMPANY	
THE DAYTON POWER AND LIGHT COMPANY	
SCALE: NONE	
DRAWN: C. SALVO	7-9-73
CHECKED: G. M. M. M.	6-17-74
ENGINEER: W. K. M. M.	6-17-74
APPROVED: J. J. J. J.	6-17-74
JOB NO. 4130	
DRAWING NO. M-92 SH. 1 OF 2	

FOR RECORD FILE ON MT-5446

RDS-RDR

8104910441

