


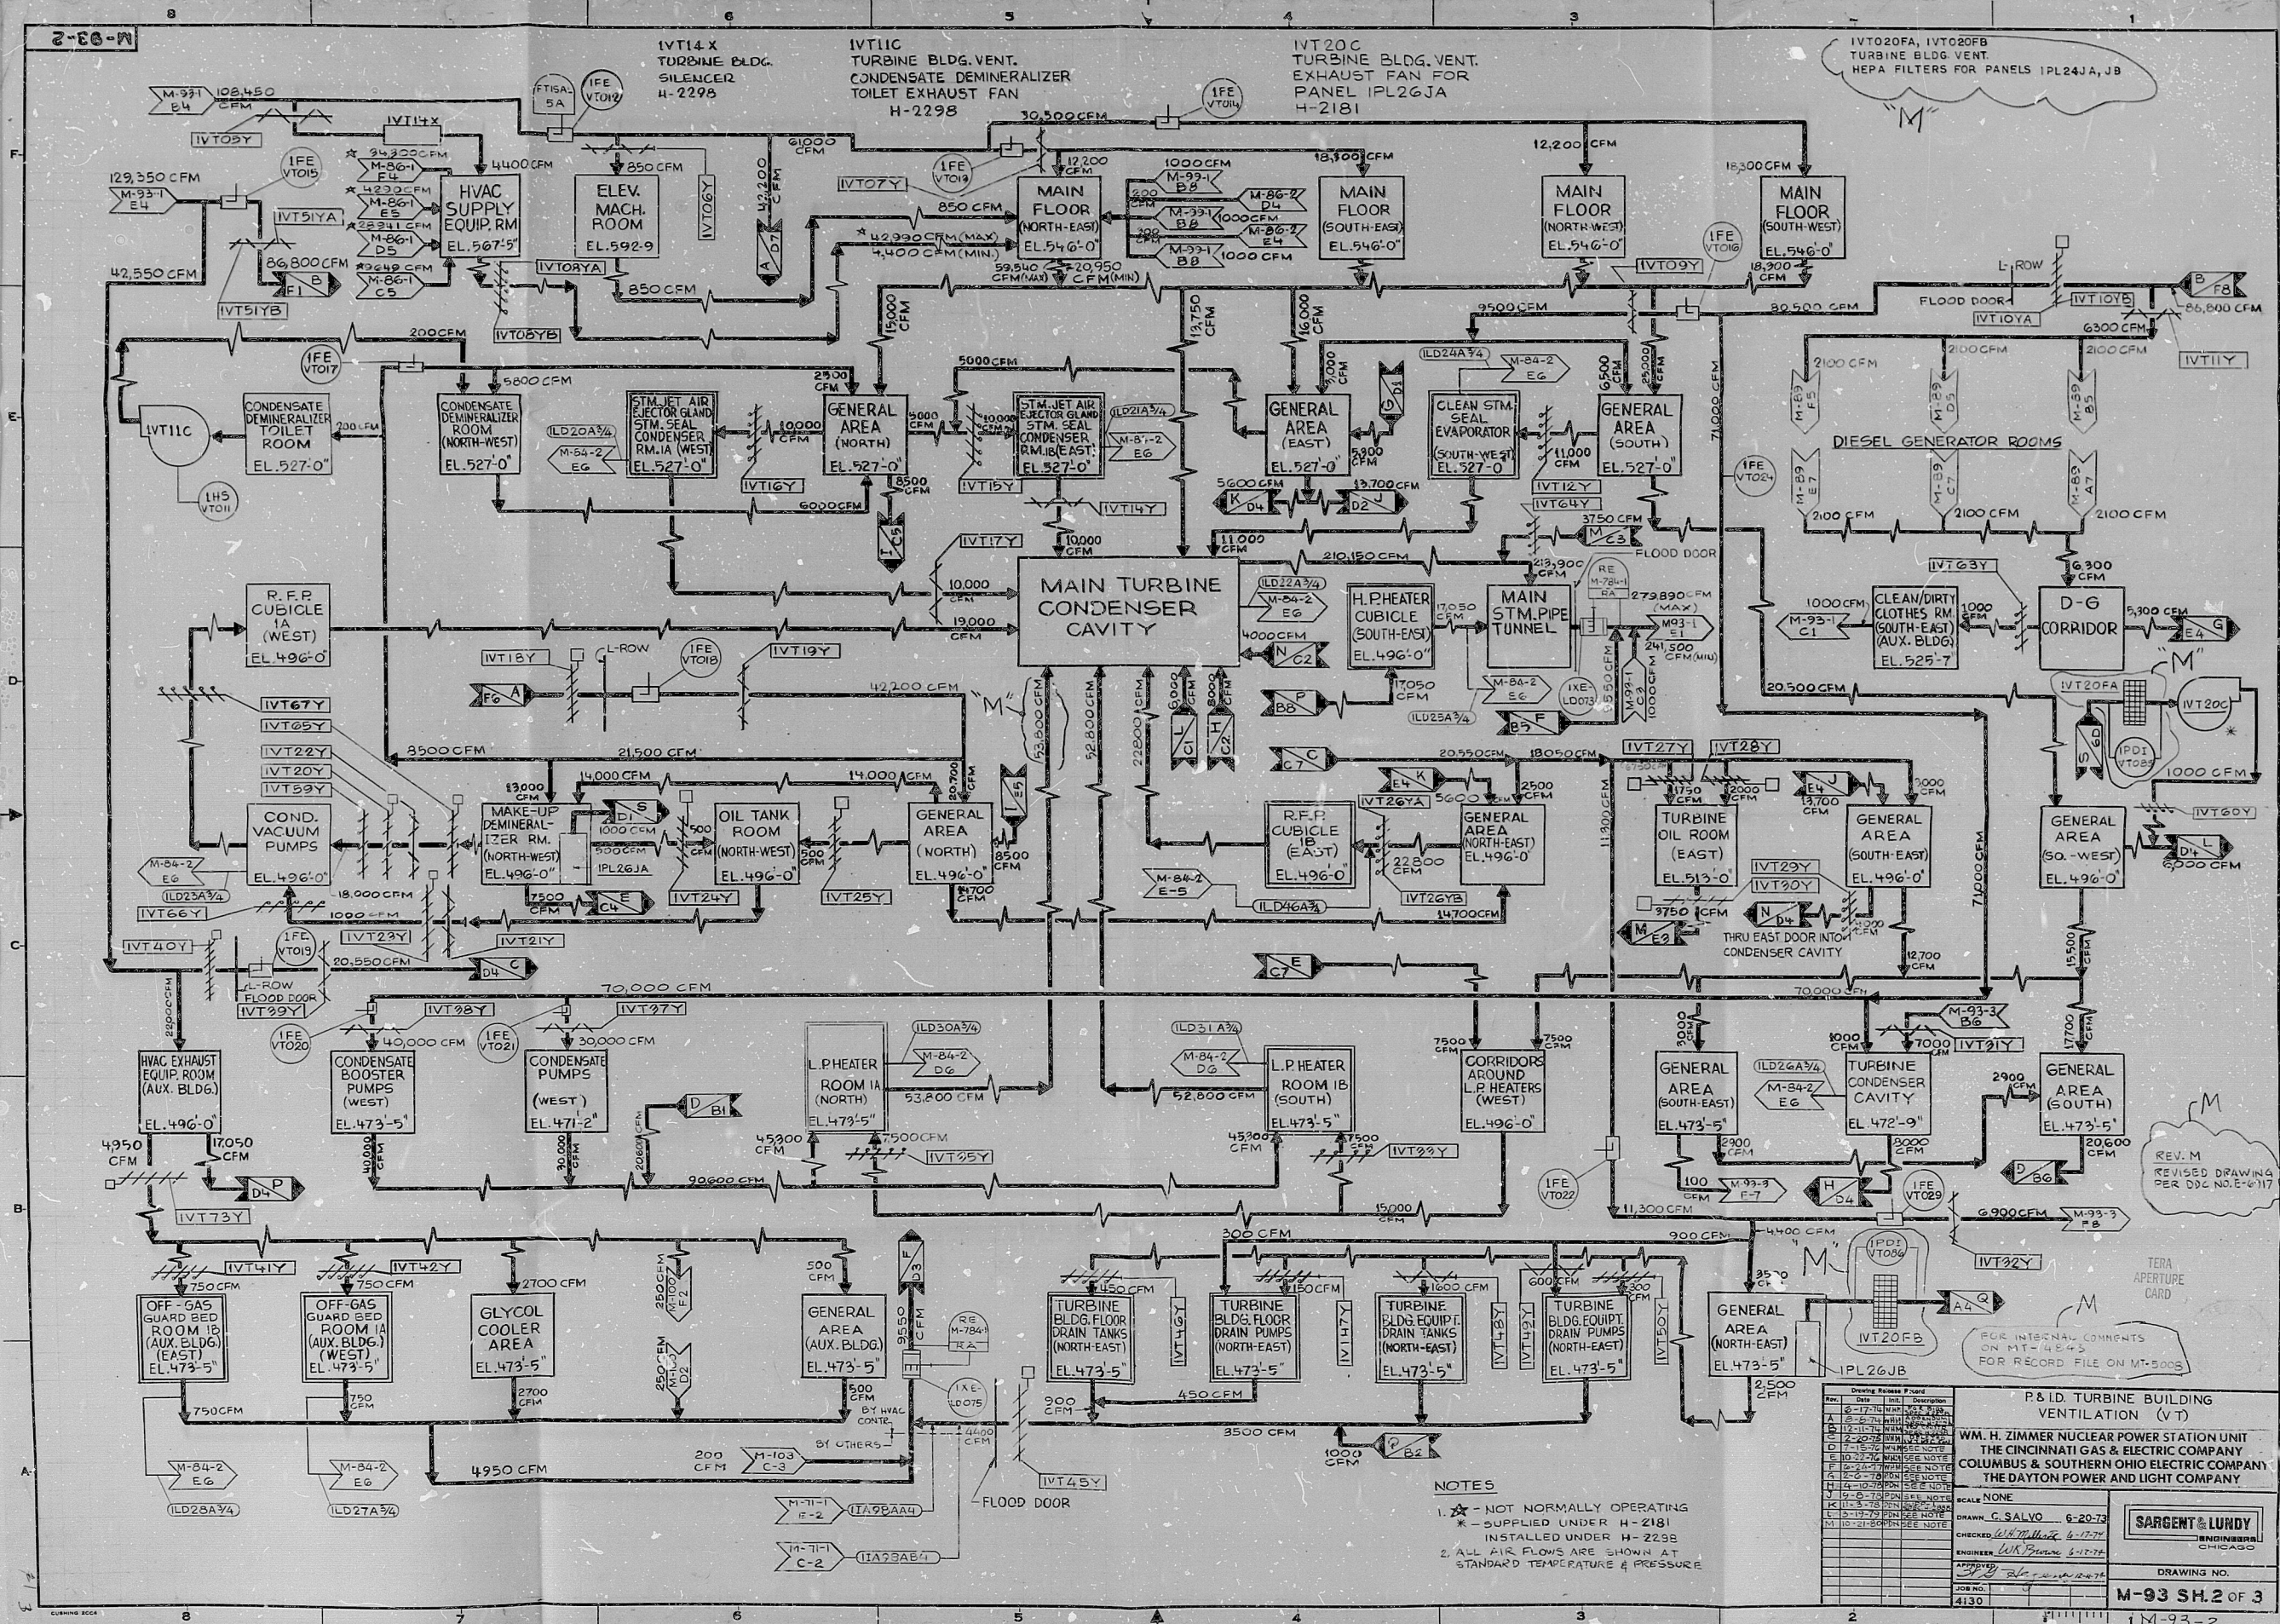

NOTES

- ★ NOT NORMALLY OPERATING
- * SUPPLIED UNDER H-2181
- INSTALLED UNDER H-2298
- ALL AIR FLOWS ARE SHOWN AT STANDARD TEMPERATURE & PRESSURE

Drawing Revision Table			
Rev.	Date	By	Description
1	6-20-73	G. SALVO	ISSUED FOR CONSTRUCTION
2	12-14-73	G. SALVO	REVISIONS TO H-2181
3	12-14-73	G. SALVO	REVISIONS TO H-2181
4	12-14-73	G. SALVO	REVISIONS TO H-2181
5	12-14-73	G. SALVO	REVISIONS TO H-2181
6	12-14-73	G. SALVO	REVISIONS TO H-2181
7	12-14-73	G. SALVO	REVISIONS TO H-2181
8	12-14-73	G. SALVO	REVISIONS TO H-2181
9	12-14-73	G. SALVO	REVISIONS TO H-2181
10	12-14-73	G. SALVO	REVISIONS TO H-2181

P&ID TURBINE BUILDING VENTILATION (VT)	
WM. H. ZIMMER NUCLEAR POWER STATION UNIT	
THE CINCINNATI GAS & ELECTRIC COMPANY	
COLUMBUS & SOUTHERN OHIO ELECTRIC COMPANY	
THE DAYTON POWER AND LIGHT COMPANY	
SCALE: NONE	
DRAWN: G. SALVO 6-20-73	
CHECKED: W. H. MILLER 6-27-73	
ENGINEER: W. H. MILLER 6-27-73	
APPROVED: [Signature] 6-27-73	
JOB NO. 4130	
DRAWING NO. M-93 SH.2 OF 3	

RIDS PD12

8104010444

