


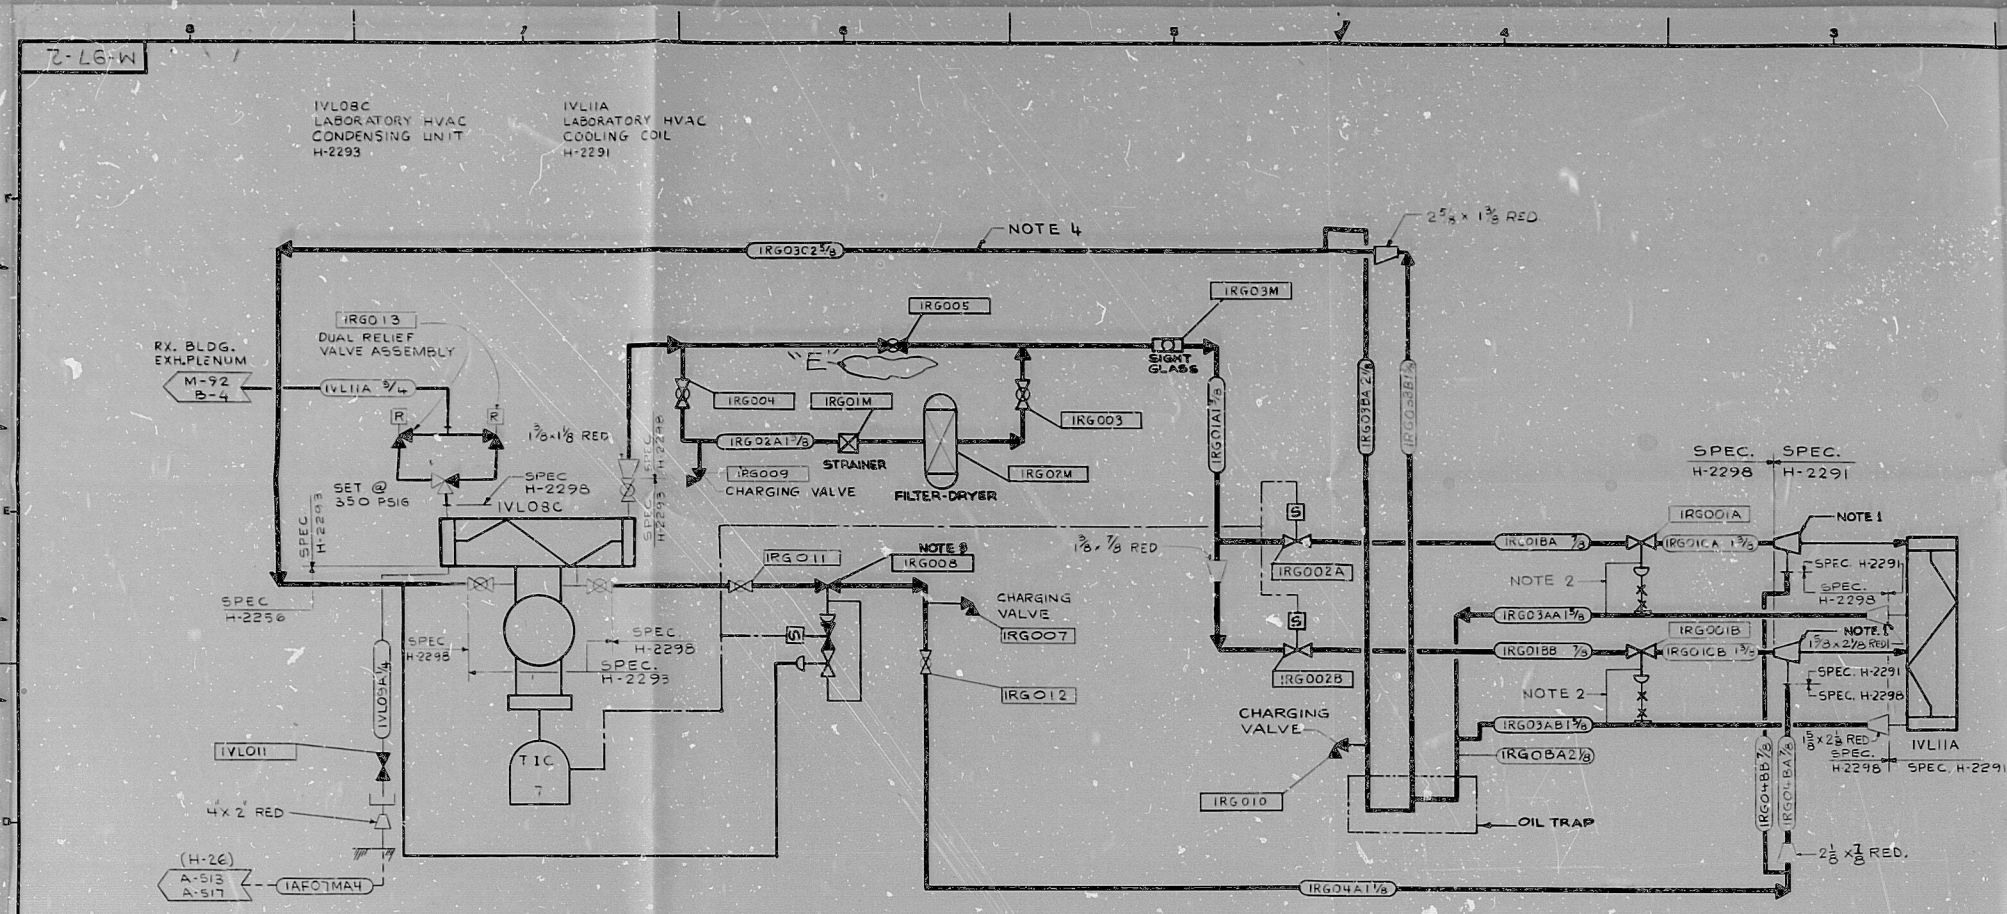

- NOTES
1. SIDE-INLET HOT GAS BY-PASS VENTURI TYPE DISTRIBUTOR.
 2. 1/4" EQUALIZER LINES.
 3. HOT GAS BY-PASS ASSEMBLY.
 4. ALL THE HORIZONTAL REFRIGERANT PIPING SHALL BE SLOPED DOWN 1/4" / 20' IN THE DIRECTION OF FLOW.

REV. "E"

1. REMOVED "LC" FROM VALVE IRG005.

PER MT. 511.

FOR INTERNAL COMMENTS ON MT-4918 FOR RECORD FILE ON MT-5044

Rev.	Date	By	Description
1	6-17-74	W. H. ZIMMER	REVISION
2	6-17-74	W. H. ZIMMER	REVISION
3	6-17-74	W. H. ZIMMER	REVISION
4	6-17-74	W. H. ZIMMER	REVISION
5	6-17-74	W. H. ZIMMER	REVISION
6	6-17-74	W. H. ZIMMER	REVISION
7	6-17-74	W. H. ZIMMER	REVISION
8	6-17-74	W. H. ZIMMER	REVISION
9	6-17-74	W. H. ZIMMER	REVISION
10	6-17-74	W. H. ZIMMER	REVISION

SCALE: NONE

DRAWN: S. OLIVO 2/23/74

CHECKED: W. H. ZIMMER 6-17-74

ENGINEER: W. H. ZIMMER 6-17-74

APPROVED: W. H. ZIMMER 6-17-74

DATE: 6-17-74

TIME: 11:30

PROJECT: P&ID LABORATORY HVAC REFRIGERATION SYSTEM (RG)

CLIENT: WM. H. ZIMMER NUCLEAR POWER STATION UNIT

OWNER: THE CINCINNATI GAS & ELECTRIC COMPANY

DESIGNER: COLUMBUS & SOUTHERN OHIO ELECTRIC COMPANY

CONTRACTOR: THE DAYTON POWER AND LIGHT COMPANY

DRAWING NO. M-97 SH. 2 OF 3

DATE: 6-17-74

RDS-RDR

81040/0457

