


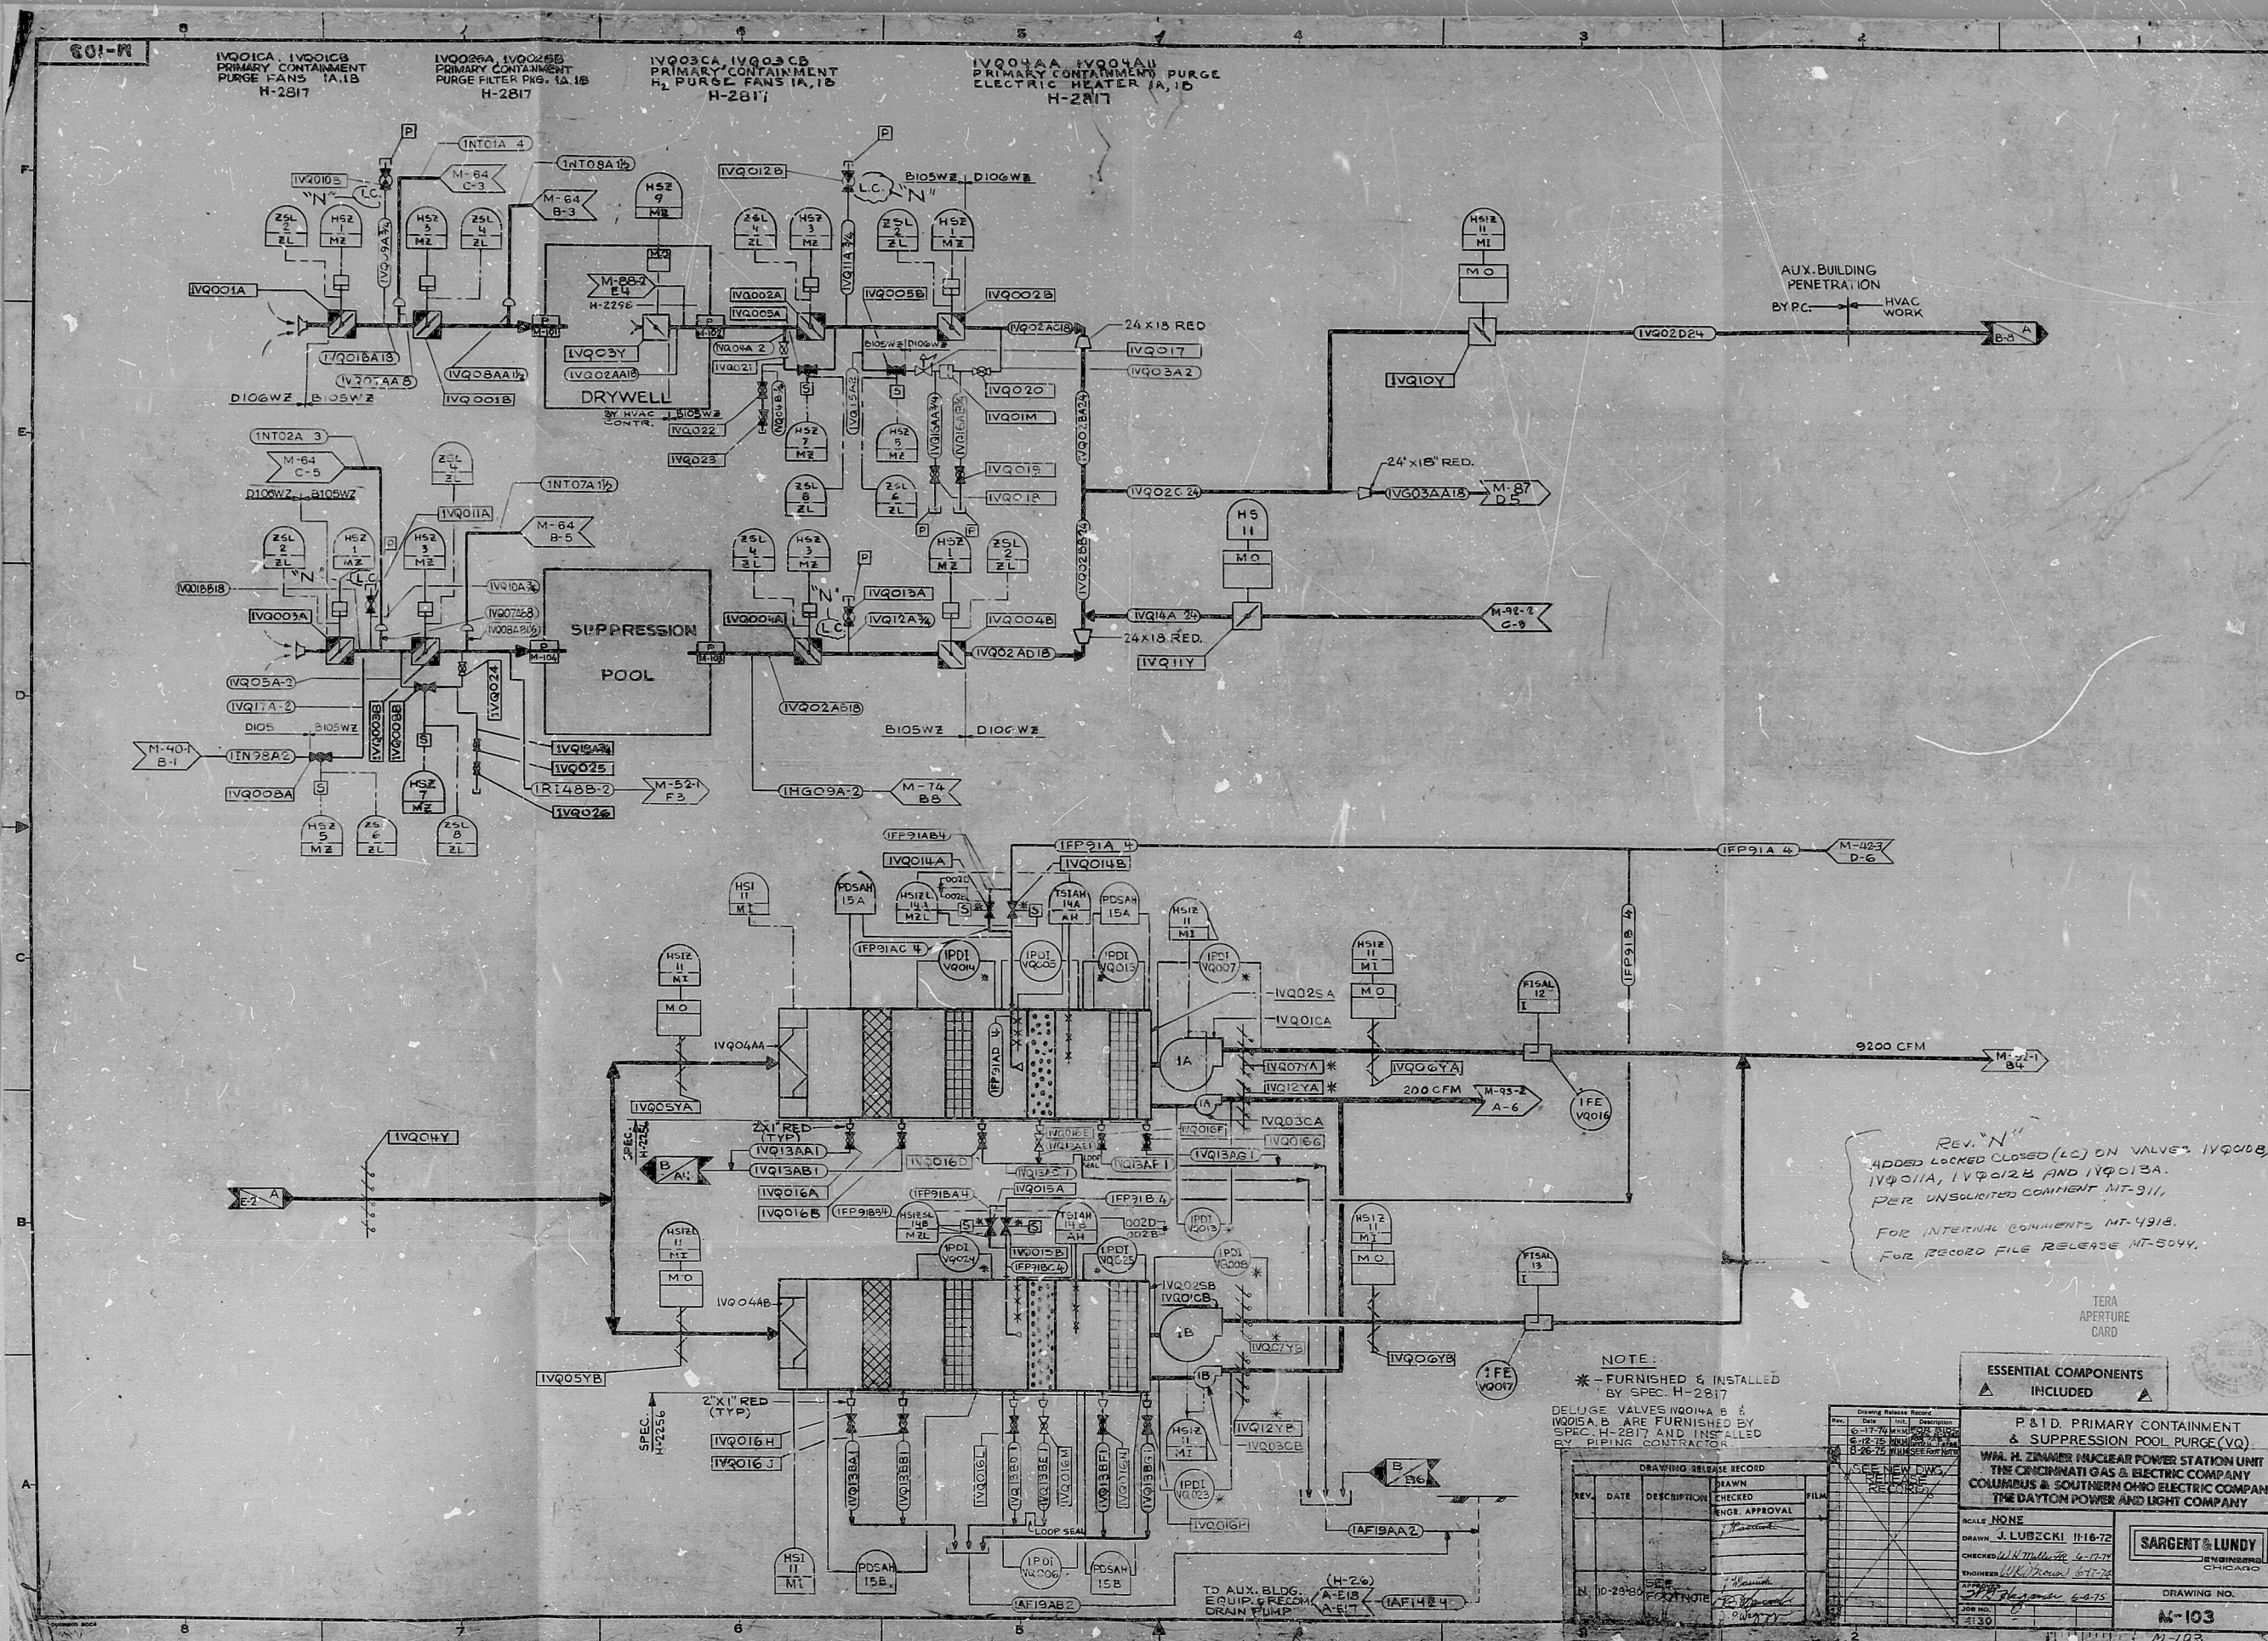

REV. "N"
ADDED LOCKED CLOSED (LC) ON VALVES IVQ008,
IVQ011A, IVQ012B AND IVQ013A.
PER UNSOLICITED COMMENT NT-311,
FOR INTERNAL COMMENTS NT-4918,
FOR RECORD FILE RELEASE NT-5044.

NOTE:
* FURNISHED & INSTALLED
BY SPEC. H-2817
DELUGE VALVES IVQ014A &
IVQ015A ARE FURNISHED BY
SPEC. H-2817 AND INSTALLED
BY PIPING CONTRACTOR

REV.	DATE	DESCRIPTION	DRAWN	CHECKED	APPROVAL	FILM
1	10-29-60	SEE NEW P&ID FOR NOTE	J. Lubczki	J. Lubczki	J. Lubczki	

ESSENTIAL COMPONENTS INCLUDED	
P&ID PRIMARY CONTAINMENT & SUPPRESSION POOL PURGE (VQ)	
W.A. H. ZIMMER NUCLEAR POWER STATION UNIT THE CINCINNATI GAS & ELECTRIC COMPANY COLUMBUS & SOUTHERN OHIO ELECTRIC COMPANY THE DAYTON POWER AND LIGHT COMPANY	
SCALE: NONE	DRAWING NO. M-103
DRAWN: J. LUBCZKI 11-6-72	ENGINEER: J. LUBCZKI 11-6-72
CHECKED: W. H. MULLER 4-17-74	ENGINEER: W. H. MULLER 4-17-74
APPROVED: J. LUBCZKI 4-2-75	ENGINEER: J. LUBCZKI 4-2-75

RDS-JD7

8104010467

