
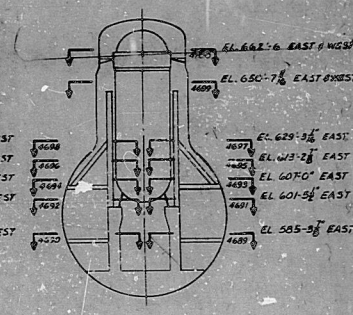


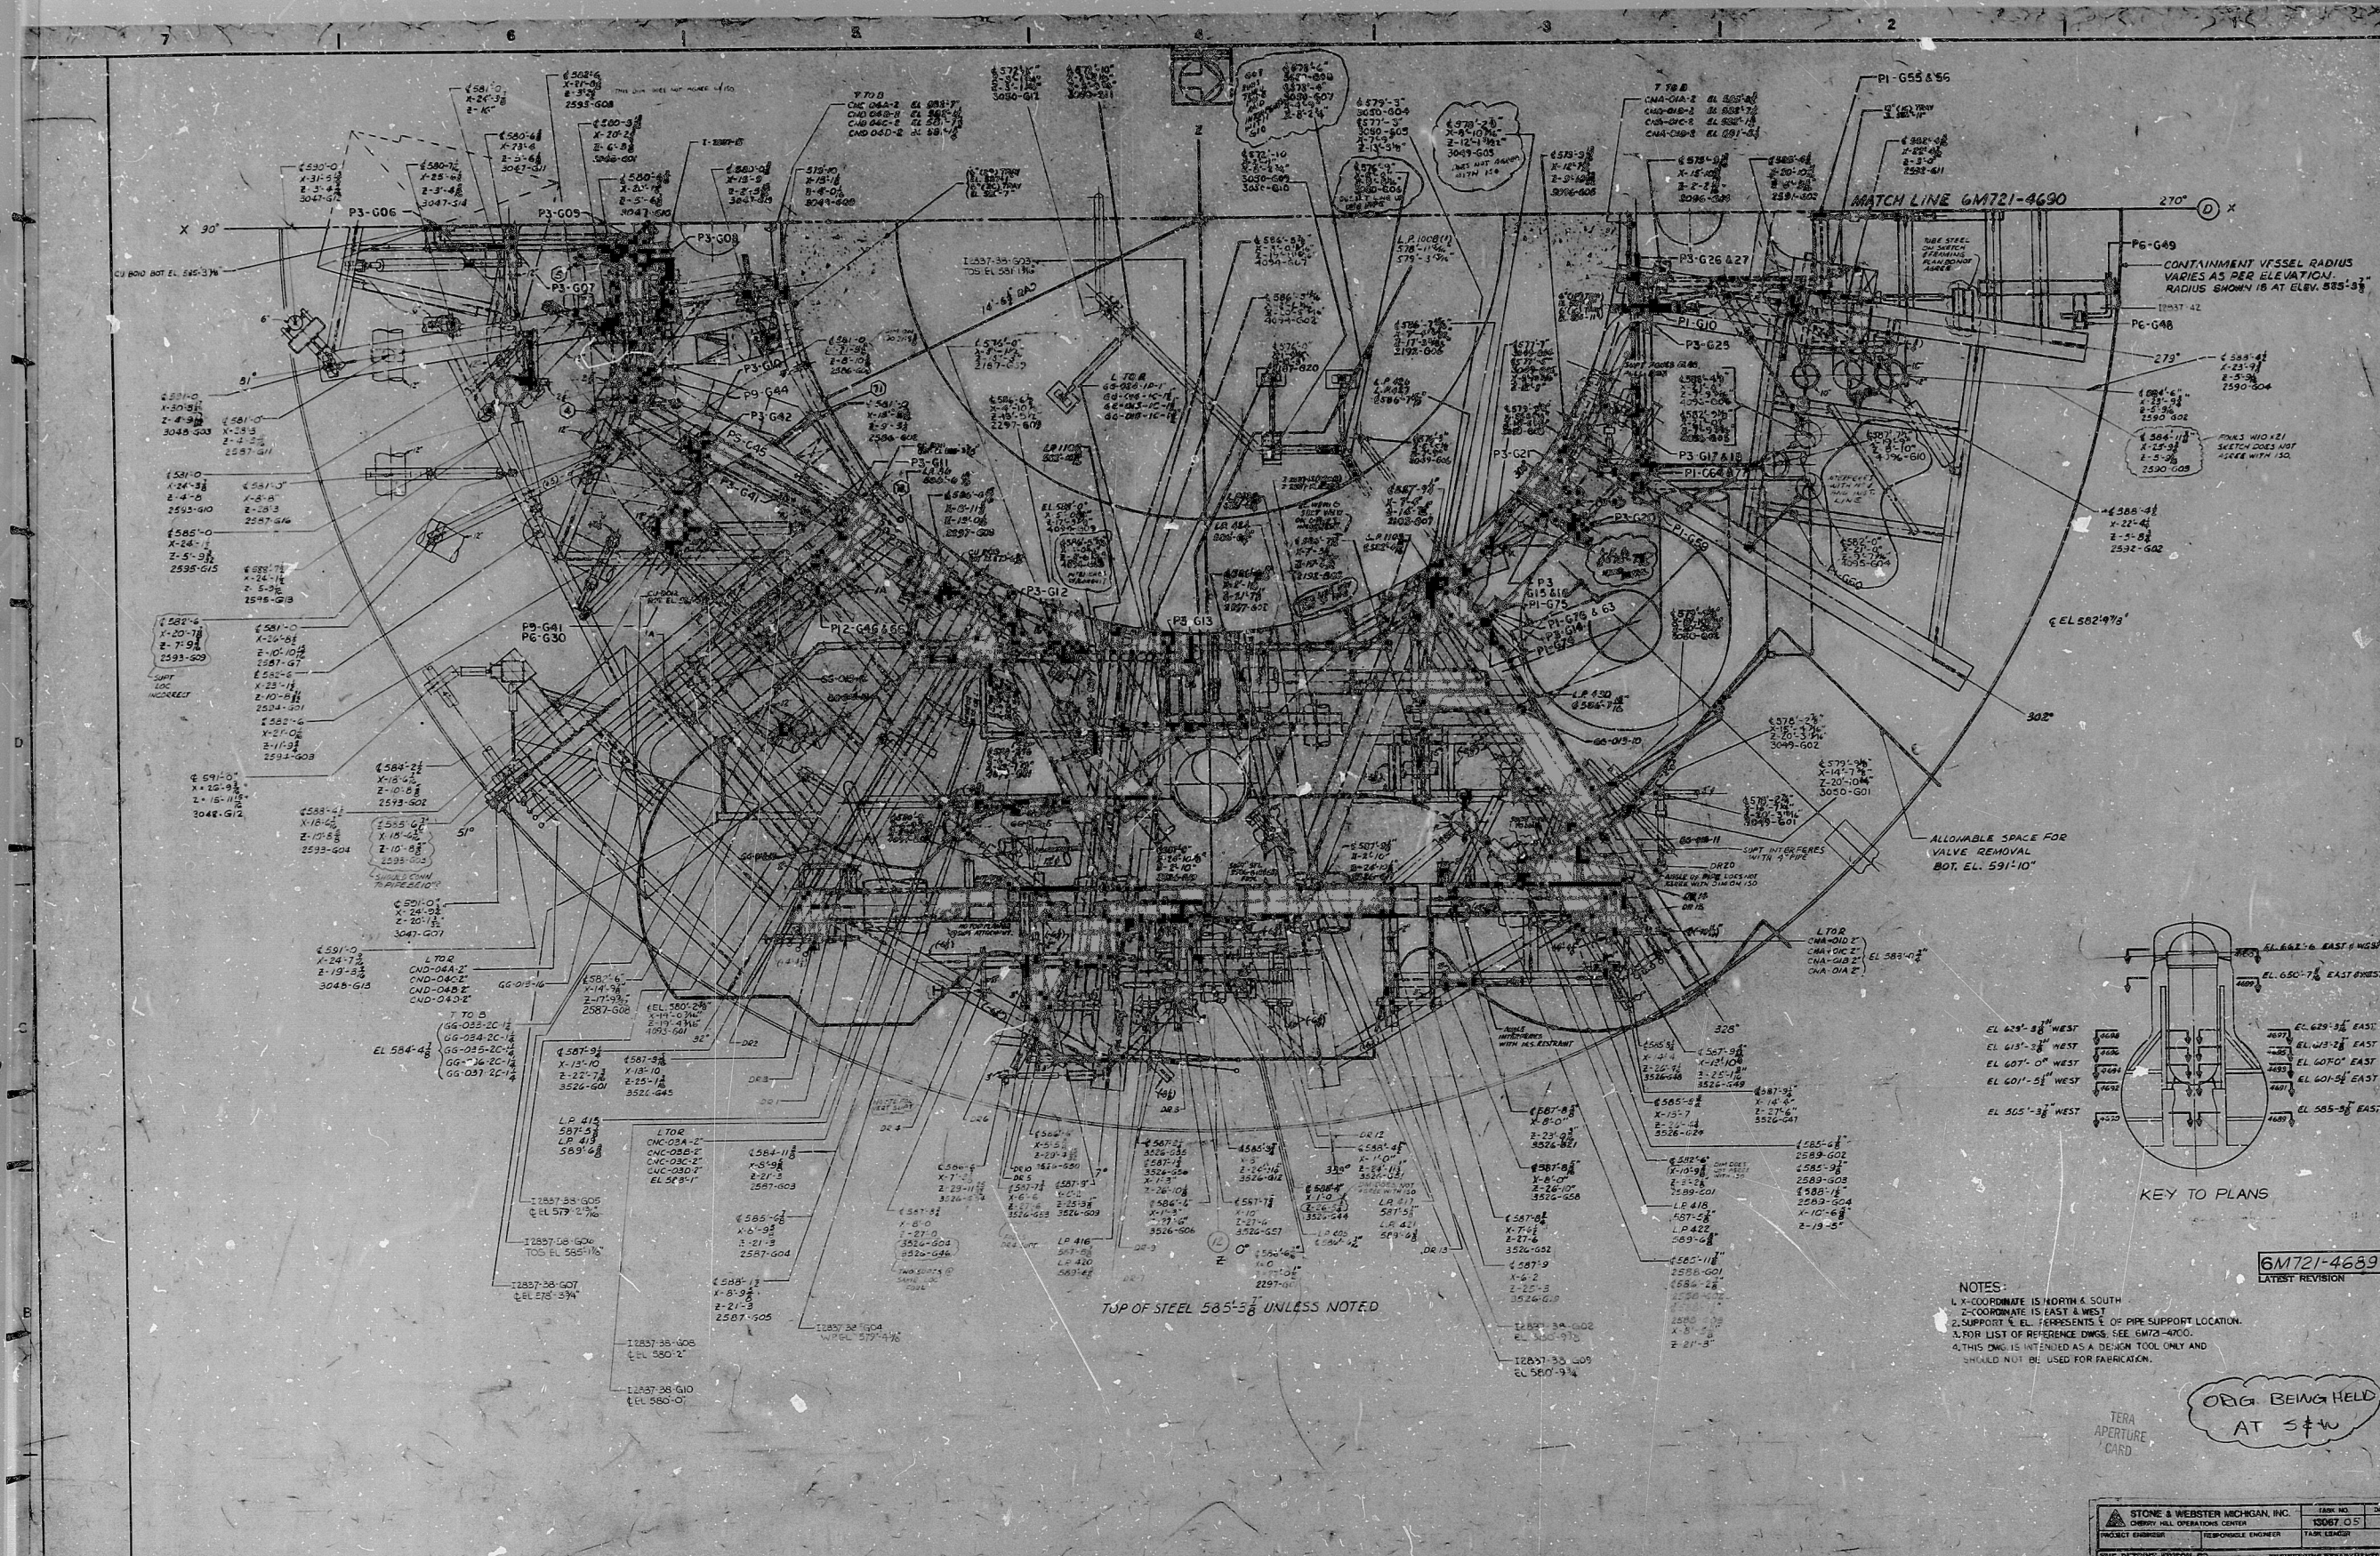

NOTES:
1. X-COORDINATE IS NORTH & SOUTH
2. Y-COORDINATE IS EAST & WEST
3. SUPPORT ELEVATION REPRESENTS E.O. OF PIPE SUPPORT LOCATION
4. FOR LIST OF REFERENCE DIMS. SEE 6M72-4100
5. THIS DWG IS INTENDED AS A DESIGN TOOL ONLY AND SHOULD NOT BE USED FOR FABRICATION.

ORG BEING HELD AT 3/4\"/>

REVISIONS										DOCUMENT CONTROL									
NO.	DATE	BY	CHKD.	APP'D.	REASON	NO.	DATE	BY	CHKD.	APP'D.	NO.	DATE	BY	CHKD.	APP'D.	NO.	DATE	BY	CHKD.
1						1					1					1			
2						2					2					2			
3						3					3					3			
4						4					4					4			
5						5					5					5			
6						6					6					6			
7						7					7					7			
8						8					8					8			
9						9					9					9			
10						10					10					10			

STONE & WEBSTER MCGRAW, INC.		13067.05	DATE
PROJECT ENGINEER		RESPONSIBLE ENGINEER	TASK LEADER
THE DETROIT EDISON CO. ENGINEERING DEPARTMENT			
TITLE: DRYWELL COMPOSITE PLAN @ EL 585-3 1/2 EAST			
LOCATION: ENRICO/FEHM ATOMIC POWER PLANT, UNIT 2			
DRAWN: J. ROMANELLO			
CHECKED: J. ROMANELLO			
DATE: 1/1/70			
SCALE: AS SHOWN			
SHEET NO. 6M72-4689			
TOTAL SHEETS: 1			

MO. 8104060375

REDS-PDR

8104060389

