



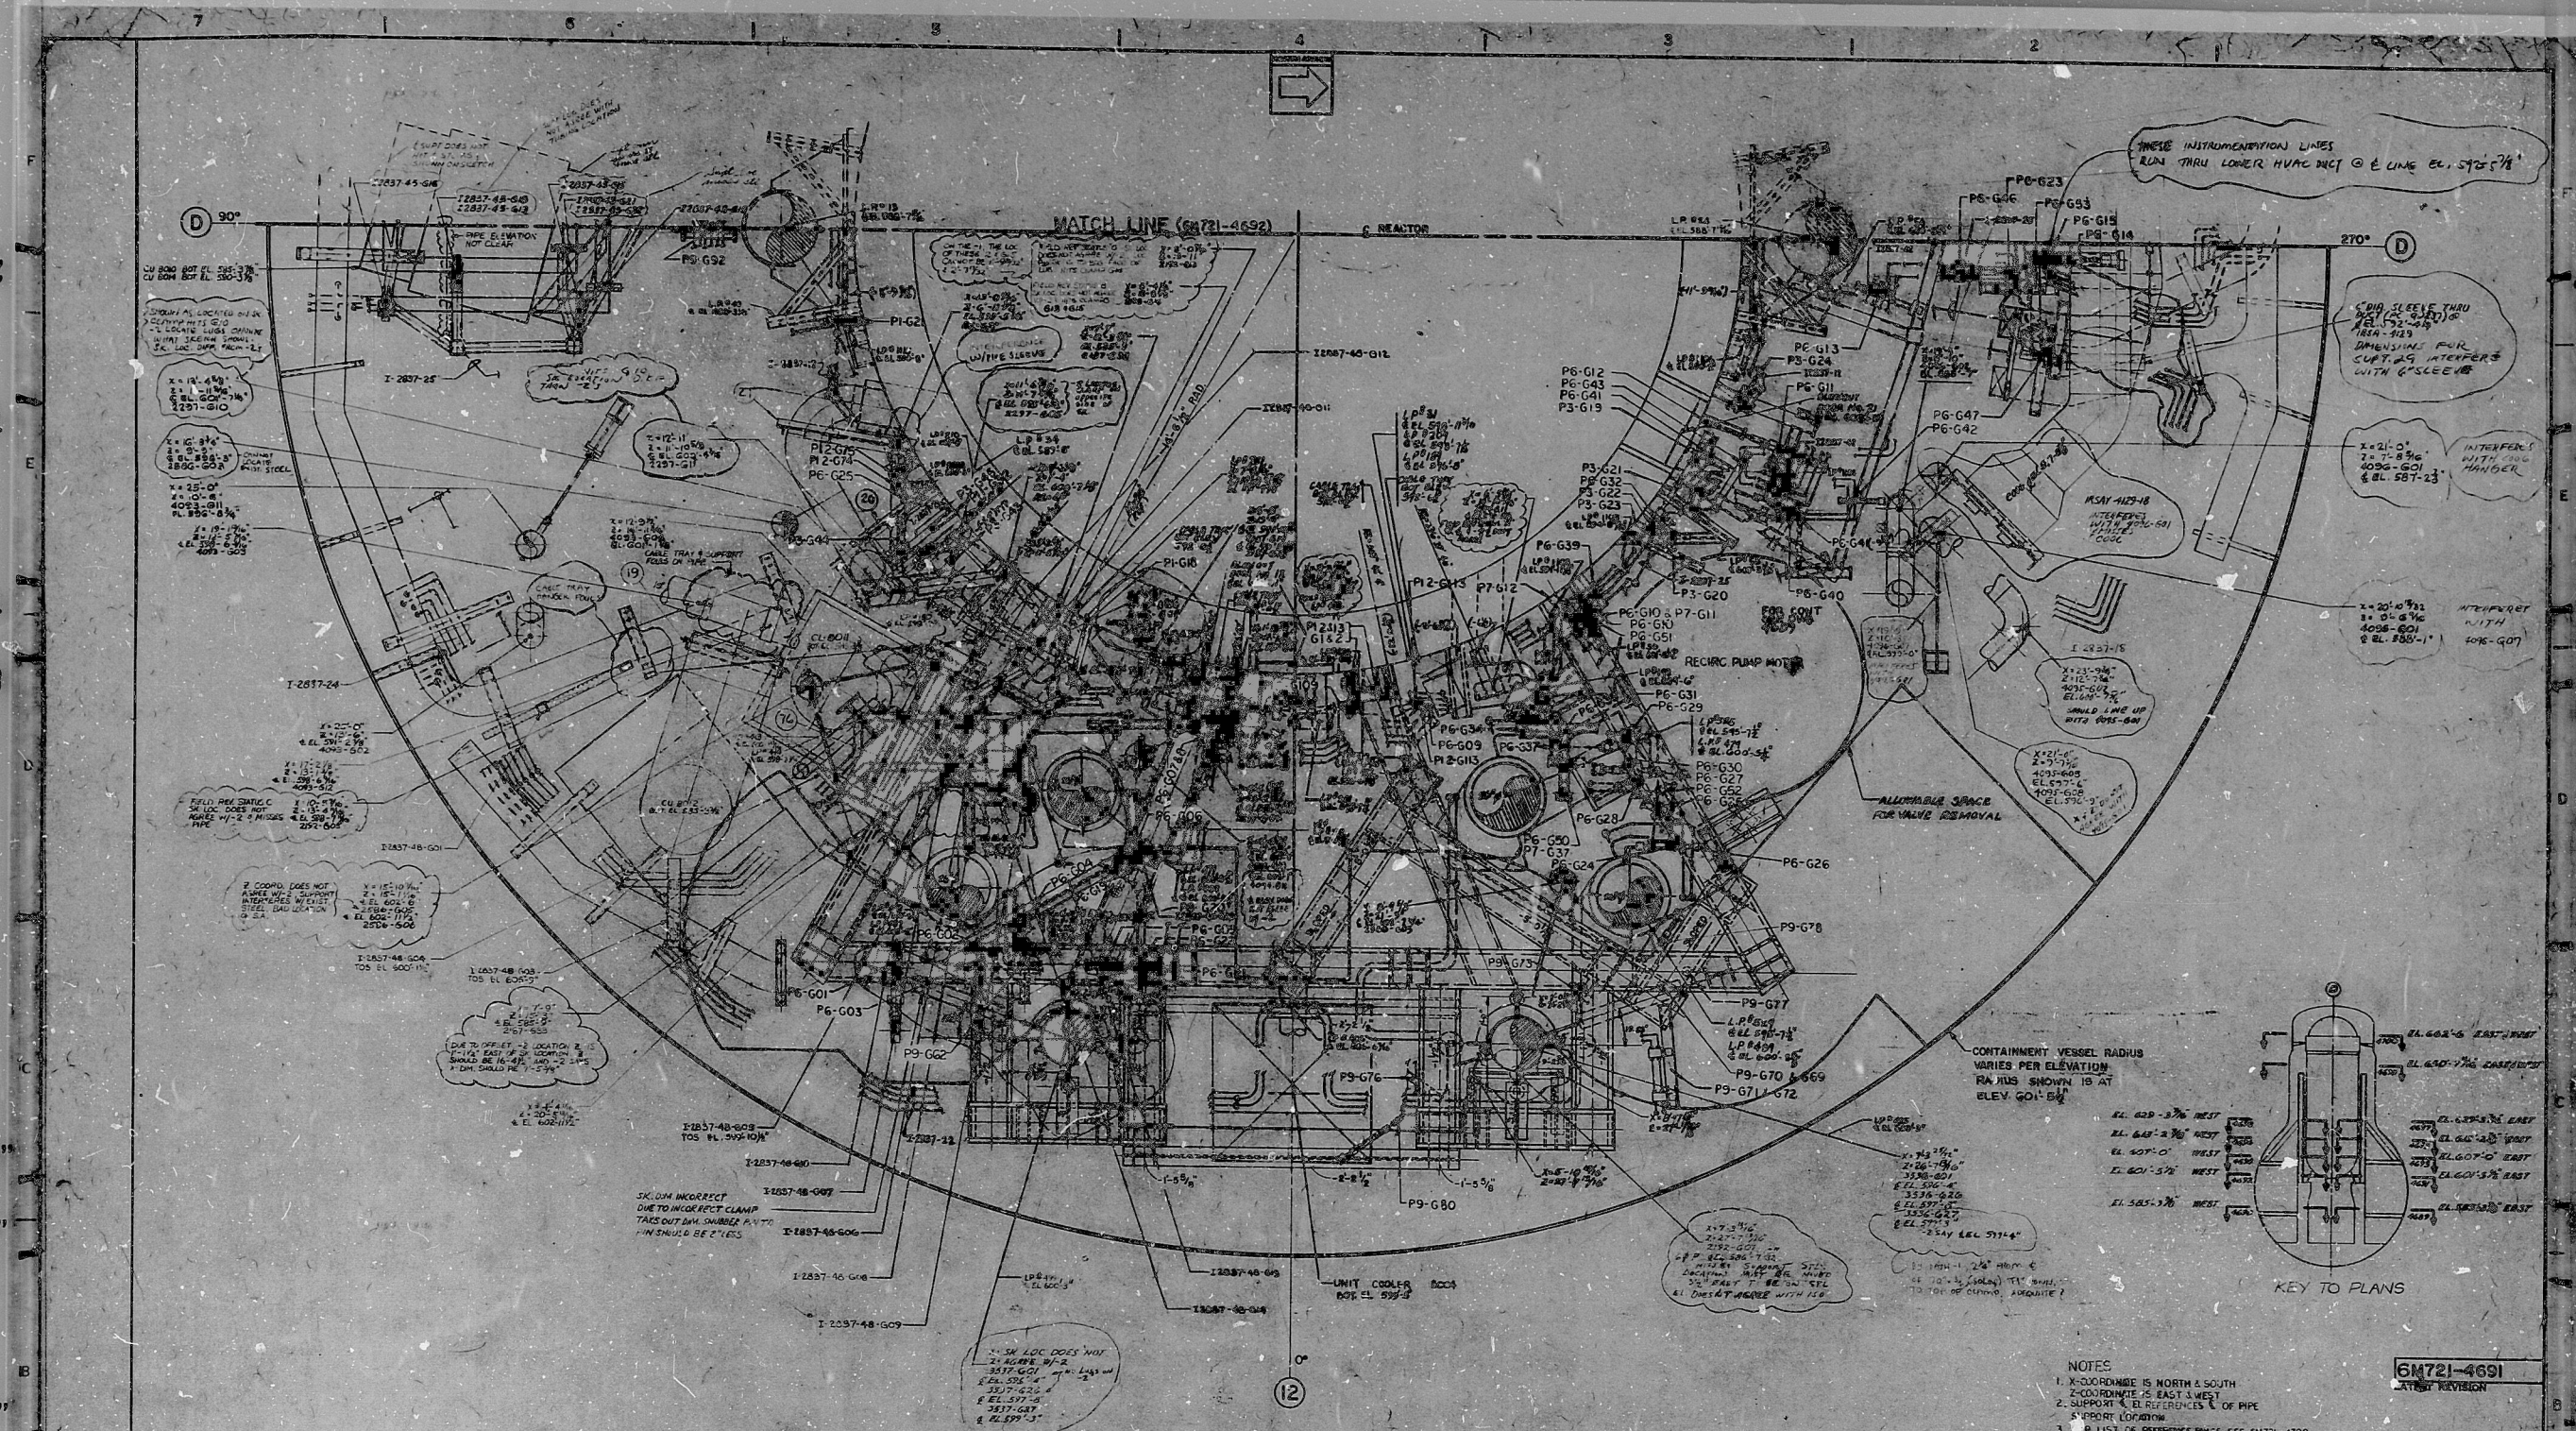

TOP OF STEEL AT EL. 601'-5 1/2"
(UNLESS OTHERWISE NOTED)

- NOTES
1. X-DIRECTION IS NORTH & SOUTH
 2. COORDINATE IS EAST & WEST
 3. SUPPORT & B. REFERENCE X OF PIPE SUPPORT LOCATION
 4. LIST OF REFERENCE DIMS. SEE 0470-1400
 5. THIS LIST IS INTENDED AS A DESIGN TOOL ONLY AND SHOULD NOT BE USED FOR FABRICATION

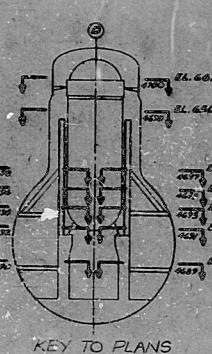

REVISIONS										APPROVALS									
NO.	DATE	BY	CHKD.	APP'D.	REASON	NO.	DATE	BY	CHKD.	APP'D.	NO.	DATE	BY	CHKD.	APP'D.	NO.	DATE	BY	CHKD.
1						1					1					1			
2						2					2					2			
3						3					3					3			
4						4					4					4			
5						5					5					5			
6						6					6					6			
7						7					7					7			
8						8					8					8			
9						9					9					9			
10						10					10					10			

STONE & WEBSTER ENGINEERING, INC.
10000 W. 100TH AVE., SUITE 100
BETHESDA, MD 20814
TEL: (301) 440-1100
FAX: (301) 440-1101
WWW.STONE-WEBS.COM

PROJECT NO. 6M721-4691
DATE 12/07/05
PROJECT ENGINEER: [Signature]
DESIGNER: [Signature]
CHECKER: [Signature]
APPROVED: [Signature]

THE DETROIT Edison CO. NUCLEAR DIVISION
DRYWELL COMPOSITE PLAN
@ EL. 601'-5 1/2" EAST
LOCATION: EHRIC FERRI ATOMIC POWER PLANT N. 2
PROJECT NO. 6M721-4691
SCALE: 1" = 1'-0"

RIDS-RDR

8104060408

