



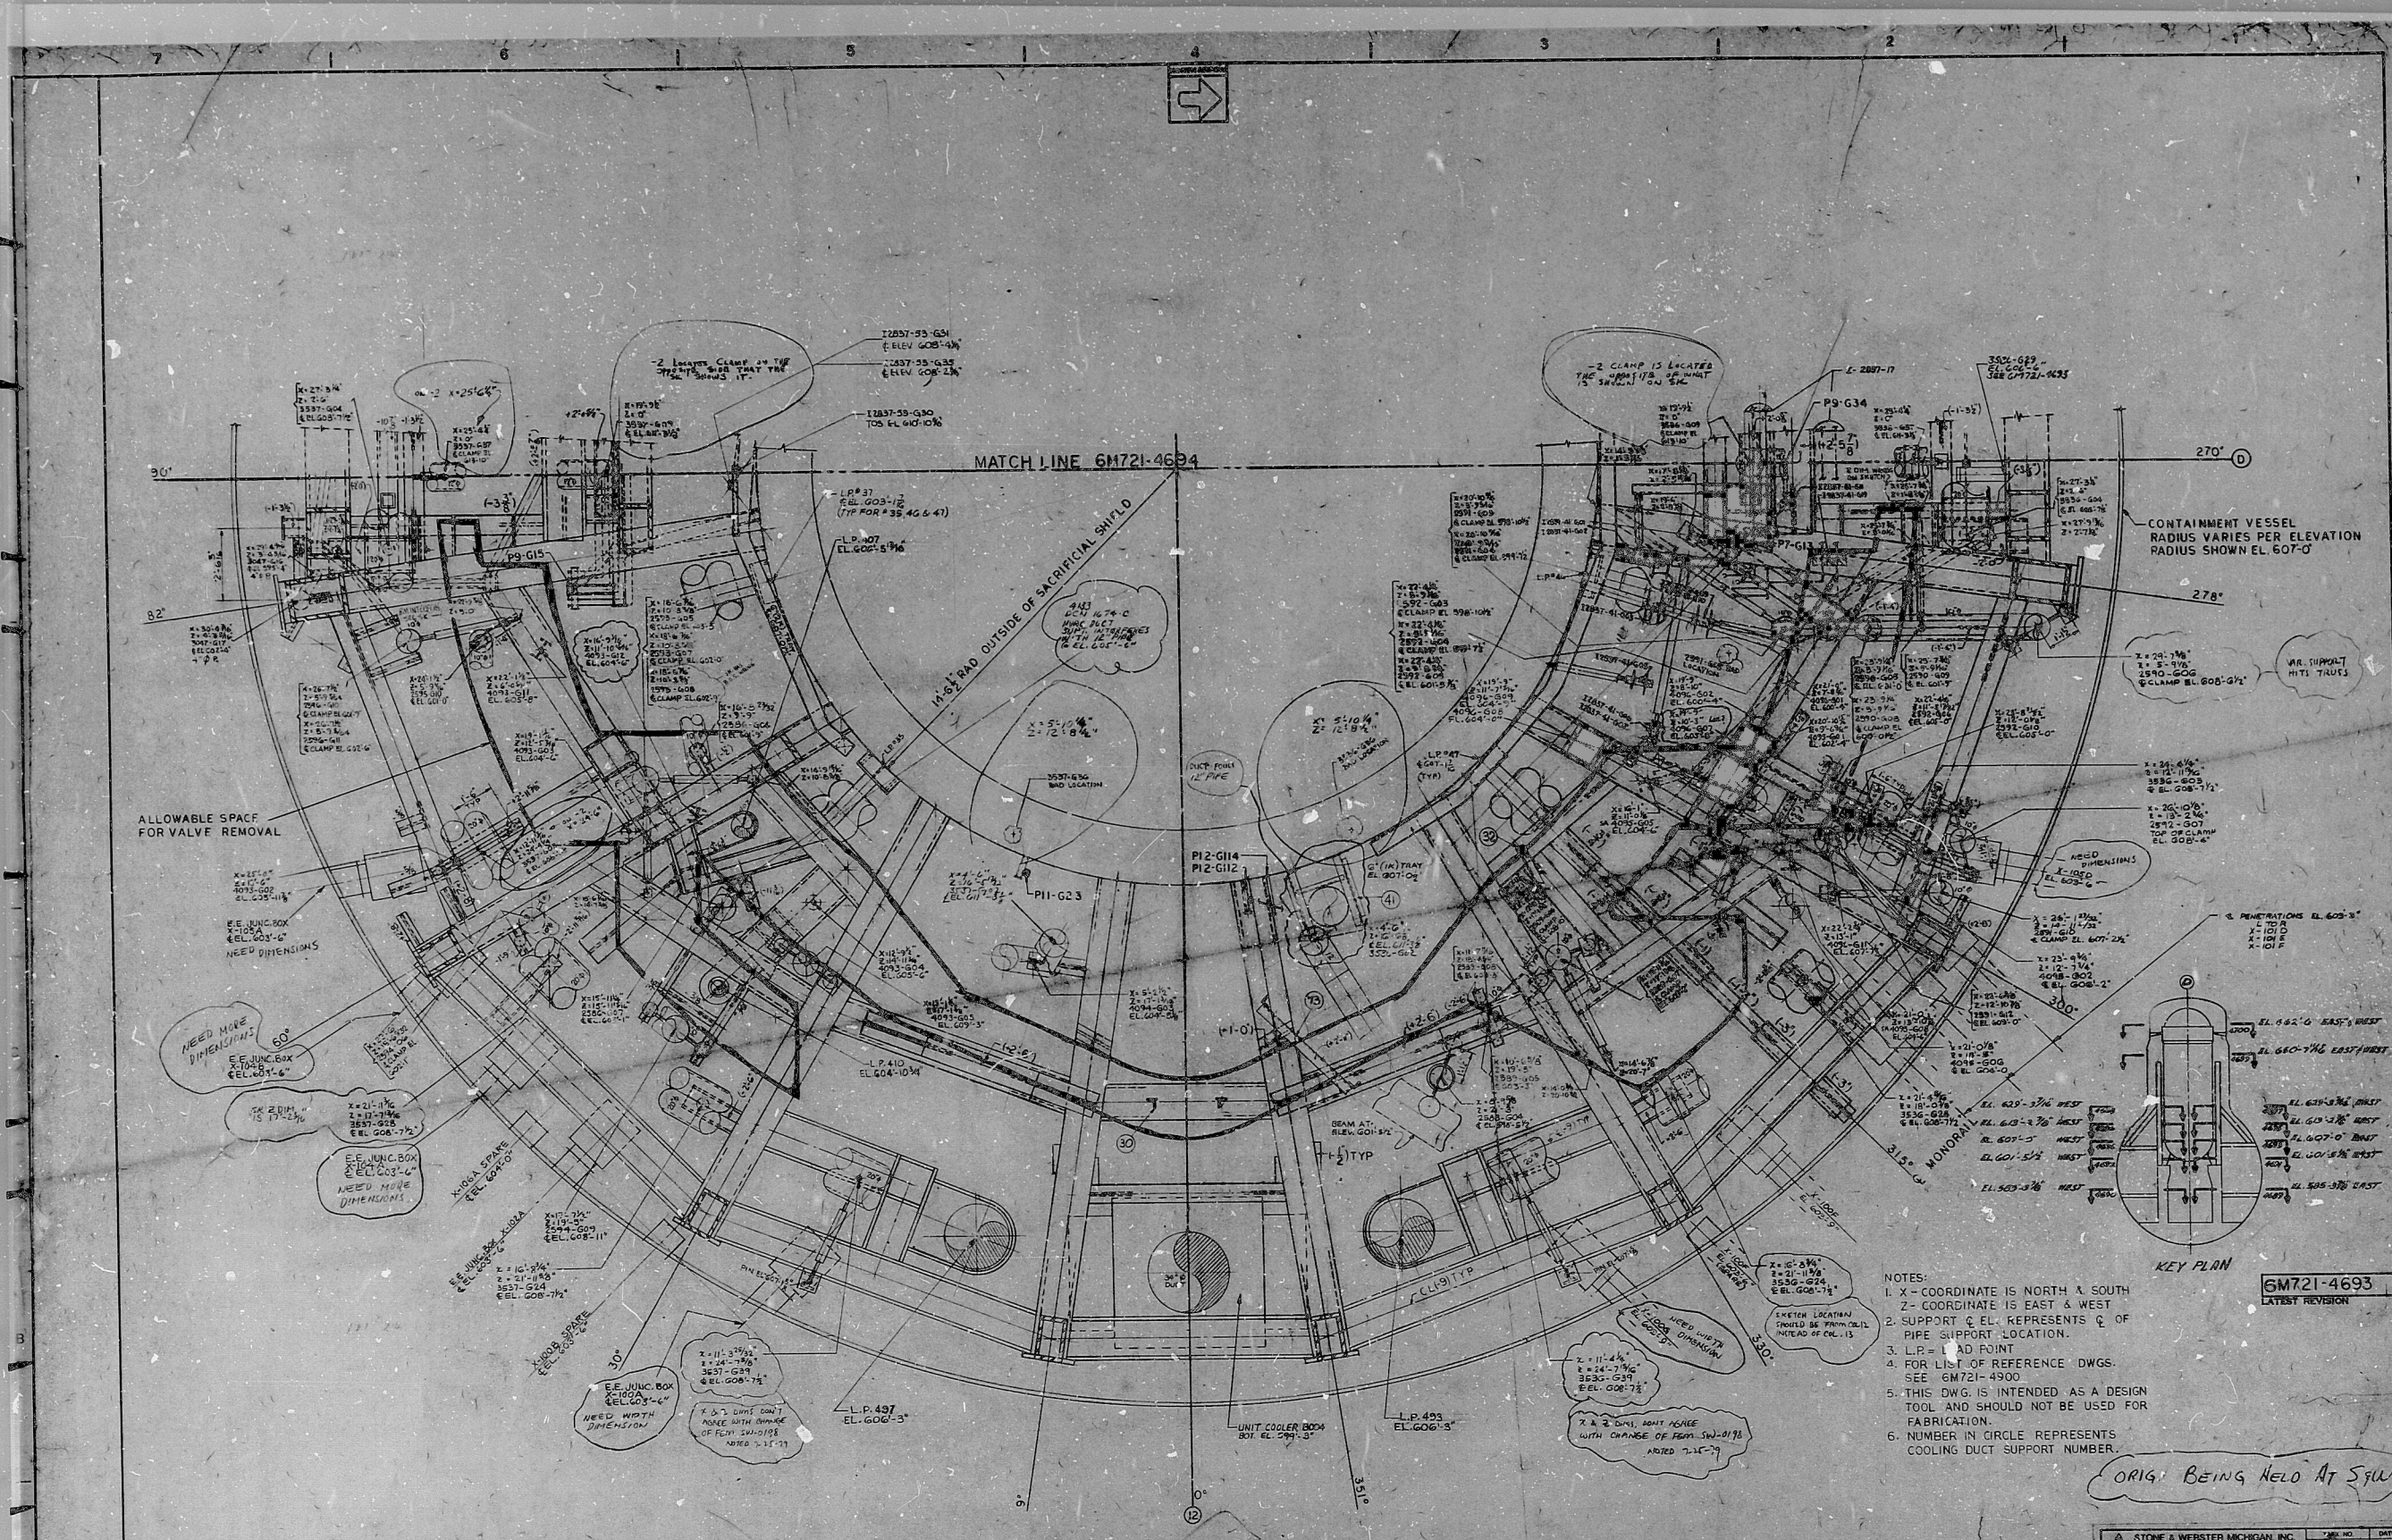

- NOTES:
1. X - COORDINATE IS NORTH & SOUTH
 2. Z - COORDINATE IS EAST & WEST
 3. SUPPORT & EL. REPRESENTS Q OF PIPE SUPPORT LOCATION.
 4. L.P. = LEAD POINT
 5. FOR LIST OF REFERENCE DWGS. SEE 6M721-4900
 6. THIS DWG. IS INTENDED AS A DESIGN TOOL AND SHOULD NOT BE USED FOR FABRICATION.
 7. NUMBER IN CIRCLE REPRESENTS COOLING DUCT SUPPORT NUMBER.

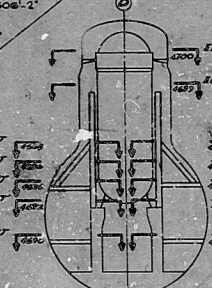

REVISIONS										APPROVALS									
NO.	DATE	BY	CHKD.	APP'D.	REASON	NO.	DATE	BY	CHKD.	APP'D.	NO.	DATE	BY	CHKD.	APP'D.	NO.	DATE	BY	CHKD.
1						1					1					1			
2						2					2					2			
3						3					3					3			
4						4					4					4			
5						5					5					5			
6						6					6					6			
7						7					7					7			
8						8					8					8			
9						9					9					9			
10						10					10					10			

STONE & WEBSTER MICHIGAN, INC.		DATE	12/06/05
PROJECT ENGINEER		DESIGNER	W. FRANCISCO
CHECKED BY		APPROVED BY	J. ROMANELLO
TITLE		DRYWELL COMPOSITE PLAN	
LOCATION		ENRICO FERMI ATOMIC POWER PLANT NO. 2	
DRAWING NO.		6M721-4693	
SCALE		1/2" = 1'-0"	
SHEET NO.		1	
TOTAL SHEETS		1	

RIDS-RDR

8104060421

