




STORRE & WOODBERRY INDUSTRIES, INC.		UNIT NO.	
CHEMICAL MILL OPERATIONS DIVISION		12067 C-6	
PROJECT ENGINEER	APPROVING ENGINEER	TECH. LEGAL	
THE DISTRICT ENGINEER		ENGINEERING DESIGN NUMBER	
TITLE: DRYWELL COMPOSITE PLAN AT EL. 507'-0" WEST			
LOCATION: ENRICO FERMIL ATOMIC POWER PLANT #2			
PROPERTY OF: DOCUMENT CONTROL NO.			
DRAWING NUMBER:		DATE: 11-2-67	
SM721-4694		1. IN SCALE 1/8" = 1'-0" 2. SEE DRAWING FOR 3. SEE DRAWING FOR 4. SEE DRAWING FOR 5. SEE DRAWING FOR 6. SEE DRAWING FOR 7. SEE DRAWING FOR 8. SEE DRAWING FOR 9. SEE DRAWING FOR 10. SEE DRAWING FOR 11. SEE DRAWING FOR 12. SEE DRAWING FOR 13. SEE DRAWING FOR 14. SEE DRAWING FOR 15. SEE DRAWING FOR 16. SEE DRAWING FOR 17. SEE DRAWING FOR 18. SEE DRAWING FOR 19. SEE DRAWING FOR 20. SEE DRAWING FOR 21. SEE DRAWING FOR 22. SEE DRAWING FOR 23. SEE DRAWING FOR 24. SEE DRAWING FOR 25. SEE DRAWING FOR 26. SEE DRAWING FOR 27. SEE DRAWING FOR 28. SEE DRAWING FOR 29. SEE DRAWING FOR 30. SEE DRAWING FOR 31. SEE DRAWING FOR 32. SEE DRAWING FOR 33. SEE DRAWING FOR 34. SEE DRAWING FOR 35. SEE DRAWING FOR 36. SEE DRAWING FOR 37. SEE DRAWING FOR 38. SEE DRAWING FOR 39. SEE DRAWING FOR 40. SEE DRAWING FOR 41. SEE DRAWING FOR 42. SEE DRAWING FOR 43. SEE DRAWING FOR 44. SEE DRAWING FOR 45. SEE DRAWING FOR 46. SEE DRAWING FOR 47. SEE DRAWING FOR 48. SEE DRAWING FOR 49. SEE DRAWING FOR 50. SEE DRAWING FOR 51. SEE DRAWING FOR 52. SEE DRAWING FOR 53. SEE DRAWING FOR 54. SEE DRAWING FOR 55. SEE DRAWING FOR 56. SEE DRAWING FOR 57. SEE DRAWING FOR 58. SEE DRAWING FOR 59. SEE DRAWING FOR 60. SEE DRAWING FOR 61. SEE DRAWING FOR 62. SEE DRAWING FOR 63. SEE DRAWING FOR 64. SEE DRAWING FOR 65. SEE DRAWING FOR 66. SEE DRAWING FOR 67. SEE DRAWING FOR 68. SEE DRAWING FOR 69. SEE DRAWING FOR 70. SEE DRAWING FOR 71. SEE DRAWING FOR 72. SEE DRAWING FOR 73. SEE DRAWING FOR 74. SEE DRAWING FOR 75. SEE DRAWING FOR 76. SEE DRAWING FOR 77. SEE DRAWING FOR 78. SEE DRAWING FOR 79. SEE DRAWING FOR 80. SEE DRAWING FOR 81. SEE DRAWING FOR 82. SEE DRAWING FOR 83. SEE DRAWING FOR 84. SEE DRAWING FOR 85. SEE DRAWING FOR 86. SEE DRAWING FOR 87. SEE DRAWING FOR 88. SEE DRAWING FOR 89. SEE DRAWING FOR 90. SEE DRAWING FOR 91. SEE DRAWING FOR 92. SEE DRAWING FOR 93. SEE DRAWING FOR 94. SEE DRAWING FOR 95. SEE DRAWING FOR 96. SEE DRAWING FOR 97. SEE DRAWING FOR 98. SEE DRAWING FOR 99. SEE DRAWING FOR 100. SEE DRAWING FOR 101. SEE DRAWING FOR 102. SEE DRAWING FOR 103. SEE DRAWING FOR 104. SEE DRAWING FOR 105. SEE DRAWING FOR 106. SEE DRAWING FOR 107. SEE DRAWING FOR 108. SEE DRAWING FOR 109. SEE DRAWING FOR 110. SEE DRAWING FOR 111. SEE DRAWING FOR 112. SEE DRAWING FOR 113. SEE DRAWING FOR 114. SEE DRAWING FOR 115. SEE DRAWING FOR 116. SEE DRAWING FOR 117. SEE DRAWING FOR 118. SEE DRAWING FOR 119. SEE DRAWING FOR 120. SEE DRAWING FOR 121. SEE DRAWING FOR 122. SEE DRAWING FOR 123. SEE DRAWING FOR 124. SEE DRAWING FOR 125. SEE DRAWING FOR 126. SEE DRAWING FOR 127. SEE DRAWING FOR 128. SEE DRAWING FOR 129. SEE DRAWING FOR 130. SEE DRAWING FOR 131. SEE DRAWING FOR 132. SEE DRAWING FOR 133. SEE DRAWING FOR 134. SEE DRAWING FOR 135. SEE DRAWING FOR 136. SEE DRAWING FOR 137. SEE DRAWING FOR 138. SEE DRAWING FOR 139. SEE DRAWING FOR 140. SEE DRAWING FOR 141. SEE DRAWING FOR 142. SEE DRAWING FOR 143. SEE DRAWING FOR 144. SEE DRAWING FOR 145. SEE DRAWING FOR 146. SEE DRAWING FOR 147. SEE DRAWING FOR 148. SEE DRAWING FOR 149. SEE DRAWING FOR 150. SEE DRAWING FOR 151. SEE DRAWING FOR 152. SEE DRAWING FOR 153. SEE DRAWING FOR 154. SEE DRAWING FOR 155. SEE DRAWING FOR 156. SEE DRAWING FOR 157. SEE DRAWING FOR 158. SEE DRAWING FOR 159. SEE DRAWING FOR 160. SEE DRAWING FOR 161. SEE DRAWING FOR 162. SEE DRAWING FOR 163. SEE DRAWING FOR 164. SEE DRAWING FOR 165. SEE DRAWING FOR 166. SEE DRAWING FOR 167. SEE DRAWING FOR 168. SEE DRAWING FOR 169. SEE DRAWING FOR 170. SEE DRAWING FOR 171. SEE DRAWING FOR 172. SEE DRAWING FOR 173. SEE DRAWING FOR 174. SEE DRAWING FOR 175. SEE DRAWING FOR 176. SEE DRAWING FOR 177. SEE DRAWING FOR 178. SEE DRAWING FOR 179. SEE DRAWING FOR 180. SEE DRAWING FOR 181. SEE DRAWING FOR 182. SEE DRAWING FOR 183. SEE DRAWING FOR 184. SEE DRAWING FOR 185. SEE DRAWING FOR 186. SEE DRAWING FOR 187. SEE DRAWING FOR 188. SEE DRAWING FOR 189. SEE DRAWING FOR 190. SEE DRAWING FOR 191. SEE DRAWING FOR 192. SEE DRAWING FOR 193. SEE DRAWING FOR 194. SEE DRAWING FOR 195. SEE DRAWING FOR 196. SEE DRAWING FOR 197. SEE DRAWING FOR 198. SEE DRAWING FOR 199. SEE DRAWING FOR 200. SEE DRAWING FOR 201. SEE DRAWING FOR 202. SEE DRAWING FOR 203. SEE DRAWING FOR 204. SEE DRAWING FOR 205. SEE DRAWING FOR 206. SEE DRAWING FOR 207. SEE DRAWING FOR 208. SEE DRAWING FOR 209. SEE DRAWING FOR 210. SEE DRAWING FOR 211. SEE DRAWING FOR 212. SEE DRAWING FOR 213. SEE DRAWING FOR 214. SEE DRAWING FOR 215. SEE DRAWING FOR 216. SEE DRAWING FOR 217. SEE DRAWING FOR 218. SEE DRAWING FOR 219. SEE DRAWING FOR 220. SEE DRAWING FOR 221. SEE DRAWING FOR 222. SEE DRAWING FOR 223. SEE DRAWING FOR 224. SEE DRAWING FOR 225. SEE DRAWING FOR 226. SEE DRAWING FOR 227. SEE DRAWING FOR 228. SEE DRAWING FOR 229. SEE DRAWING FOR 230. SEE DRAWING FOR 231. SEE DRAWING FOR 232. SEE DRAWING FOR 233. SEE DRAWING FOR 234. SEE DRAWING FOR 235. SEE DRAWING FOR 236. SEE DRAWING FOR 237. SEE DRAWING FOR 238. SEE DRAWING FOR 239. SEE DRAWING FOR 240. SEE DRAWING FOR 241. SEE DRAWING FOR 242. SEE DRAWING FOR 243. SEE DRAWING FOR 244. SEE DRAWING FOR 245. SEE DRAWING FOR 246. SEE DRAWING FOR 247. SEE DRAWING FOR 248. SEE DRAWING FOR 249. SEE DRAWING FOR 250. SEE DRAWING FOR 251. SEE DRAWING FOR 252. SEE DRAWING FOR 253. SEE DRAWING FOR 254. SEE DRAWING FOR 255. SEE DRAWING FOR 256. SEE DRAWING FOR 257. SEE DRAWING FOR 258. SEE DRAWING FOR 259. SEE DRAWING FOR 260. SEE DRAWING FOR 261. SEE DRAWING FOR 262. SEE DRAWING FOR 263. SEE DRAWING FOR 264. SEE DRAWING FOR 265. SEE DRAWING FOR 266. SEE DRAWING FOR 267. SEE DRAWING FOR 268. SEE DRAWING FOR 269. SEE DRAWING FOR 270. SEE DRAWING FOR 271. SEE DRAWING FOR 272. SEE DRAWING FOR 273. SEE DRAWING FOR 274. SEE DRAWING FOR 275. SEE DRAWING FOR 276. SEE DRAWING FOR 277. SEE DRAWING FOR 278. SEE DRAWING FOR 279. SEE DRAWING FOR 280. SEE DRAWING FOR 281. SEE DRAWING FOR 282. SEE DRAWING FOR 283. SEE DRAWING FOR 284. SEE DRAWING FOR 285. SEE DRAWING FOR 286. SEE DRAWING FOR 287. SEE DRAWING FOR 288. SEE DRAWING FOR 289. SEE DRAWING FOR 290. SEE DRAWING FOR 291. SEE DRAWING FOR 292. SEE DRAWING FOR 293. SEE DRAWING FOR 294. SEE DRAWING FOR 295. SEE DRAWING FOR 296. SEE DRAWING FOR 297. SEE DRAWING FOR 298. SEE DRAWING FOR 2	

RDS-PDR

8104060425

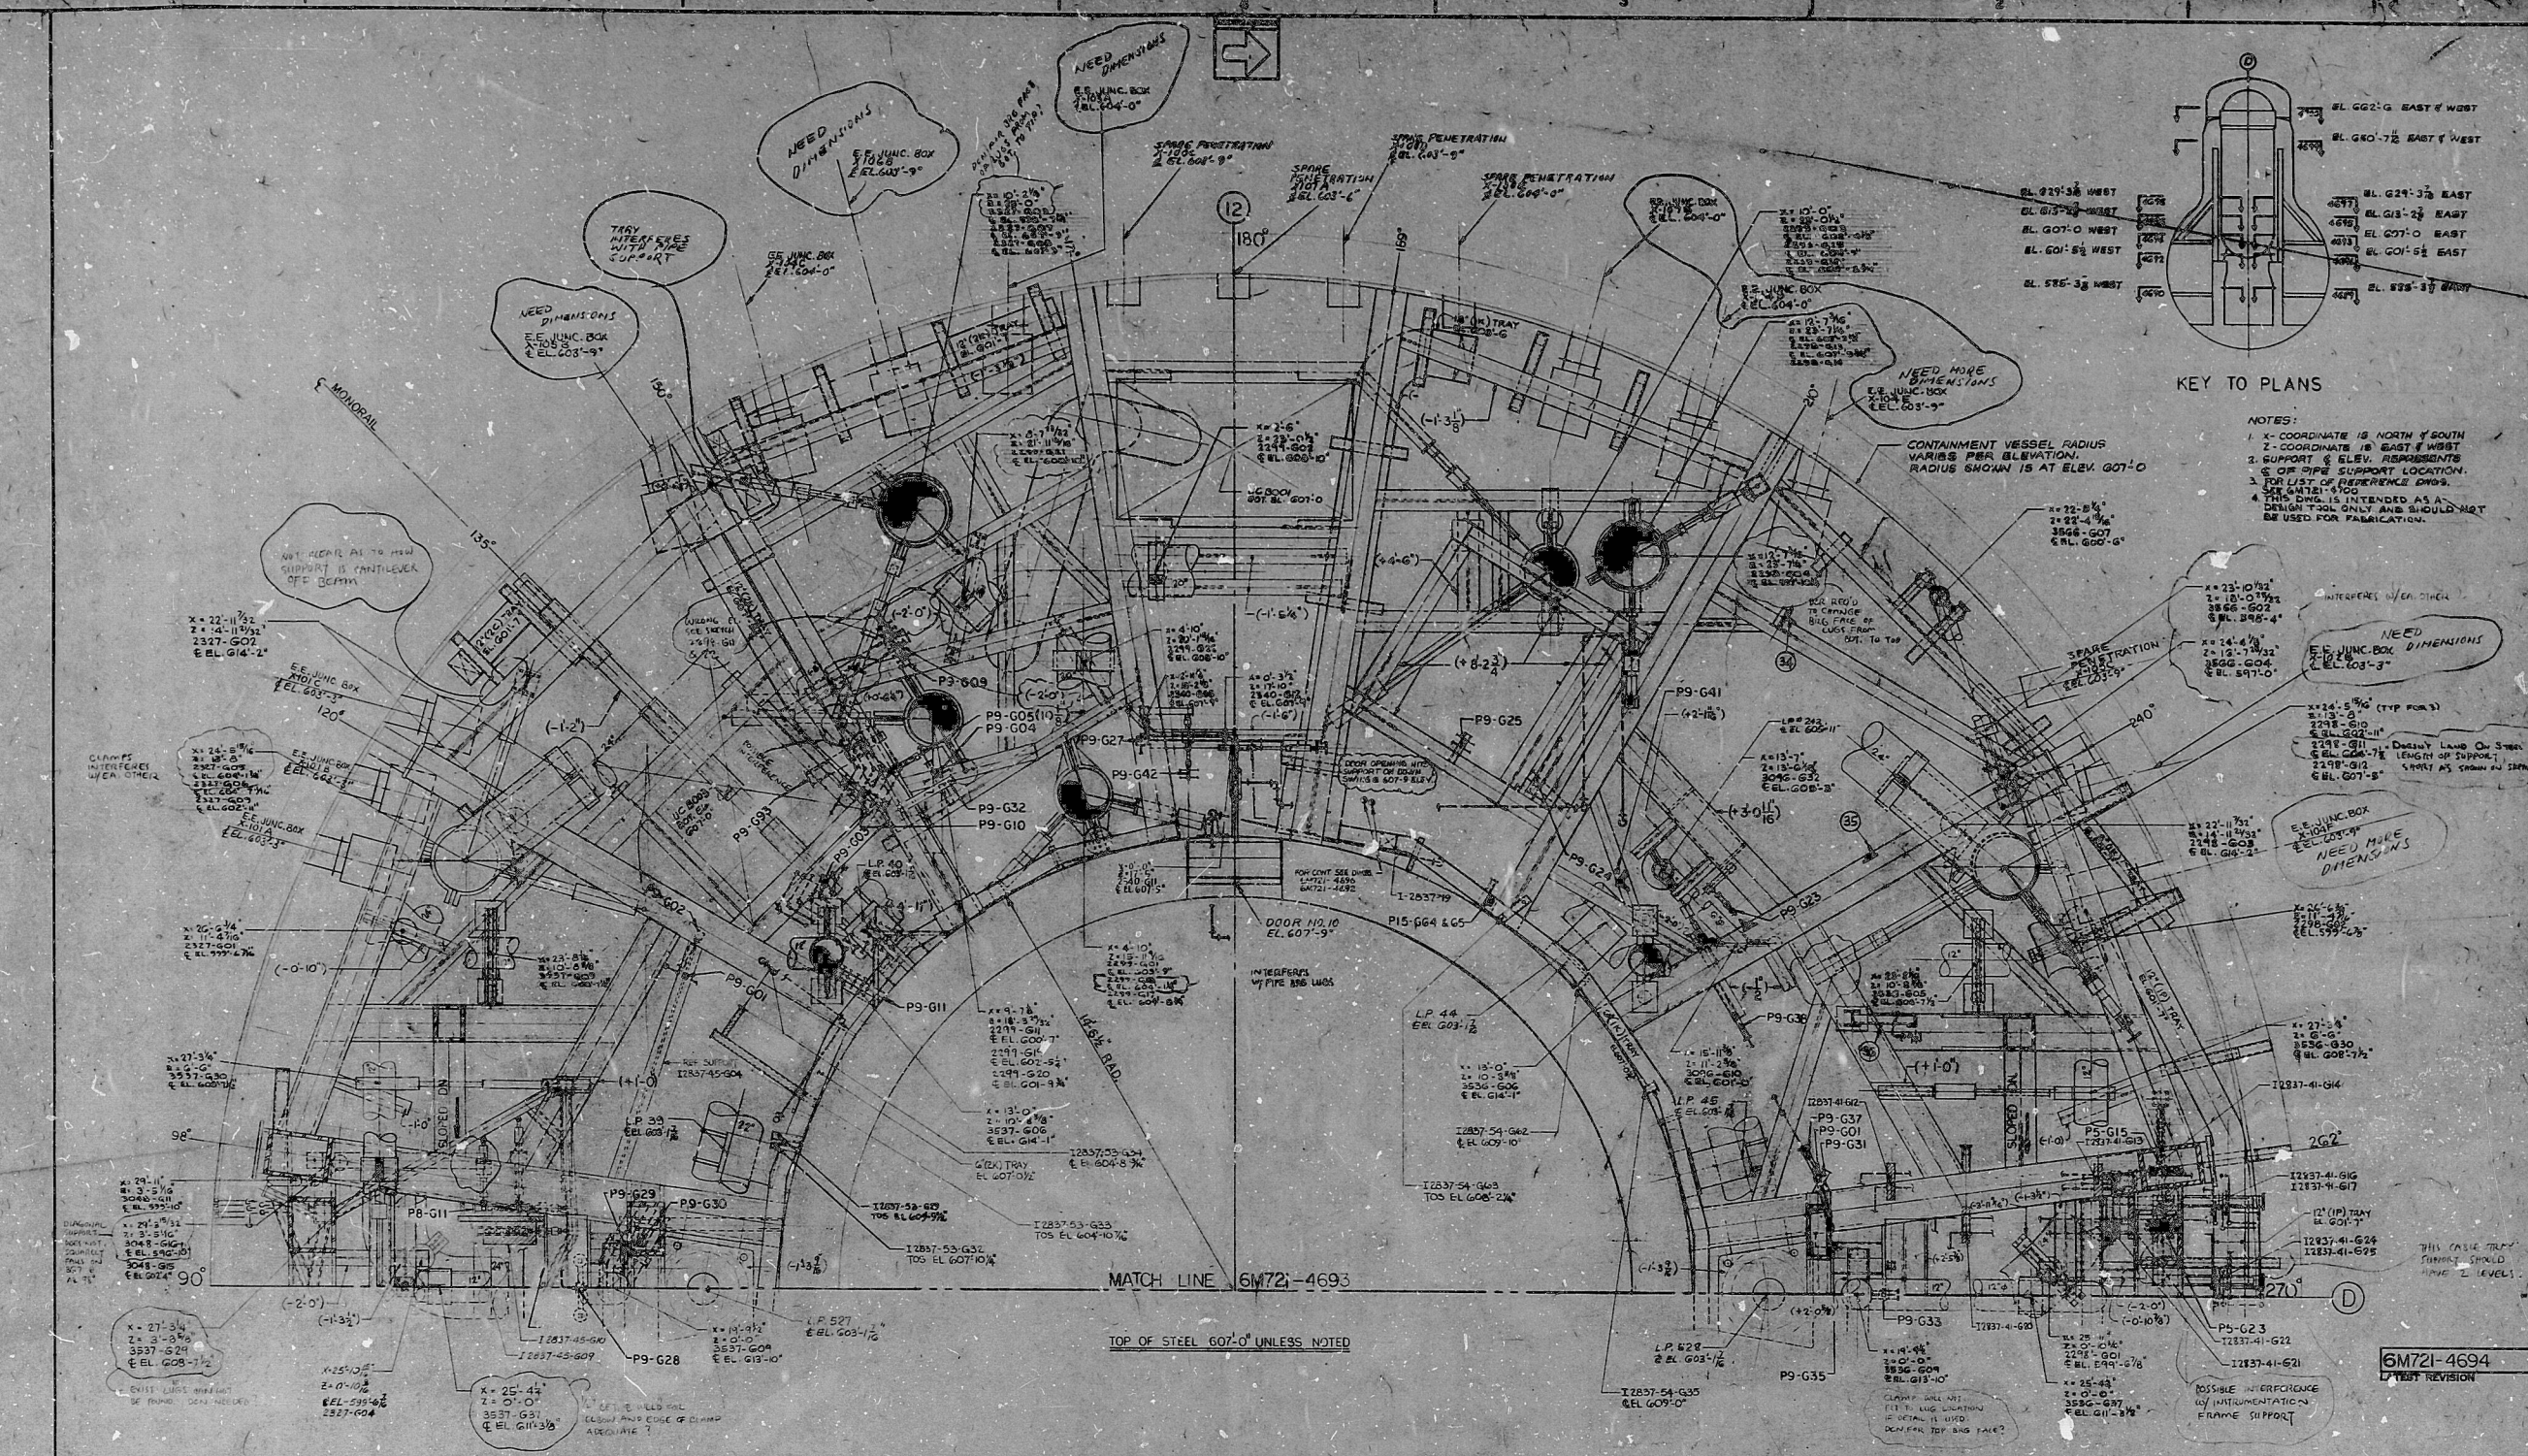