


This drawing and the design it covers is the property of the United States Government. It is loaned to the licensee for use in the production of the nuclear power plant. It is not to be reproduced, copied, loaned, or used in any way without the express written consent of the United States Government.

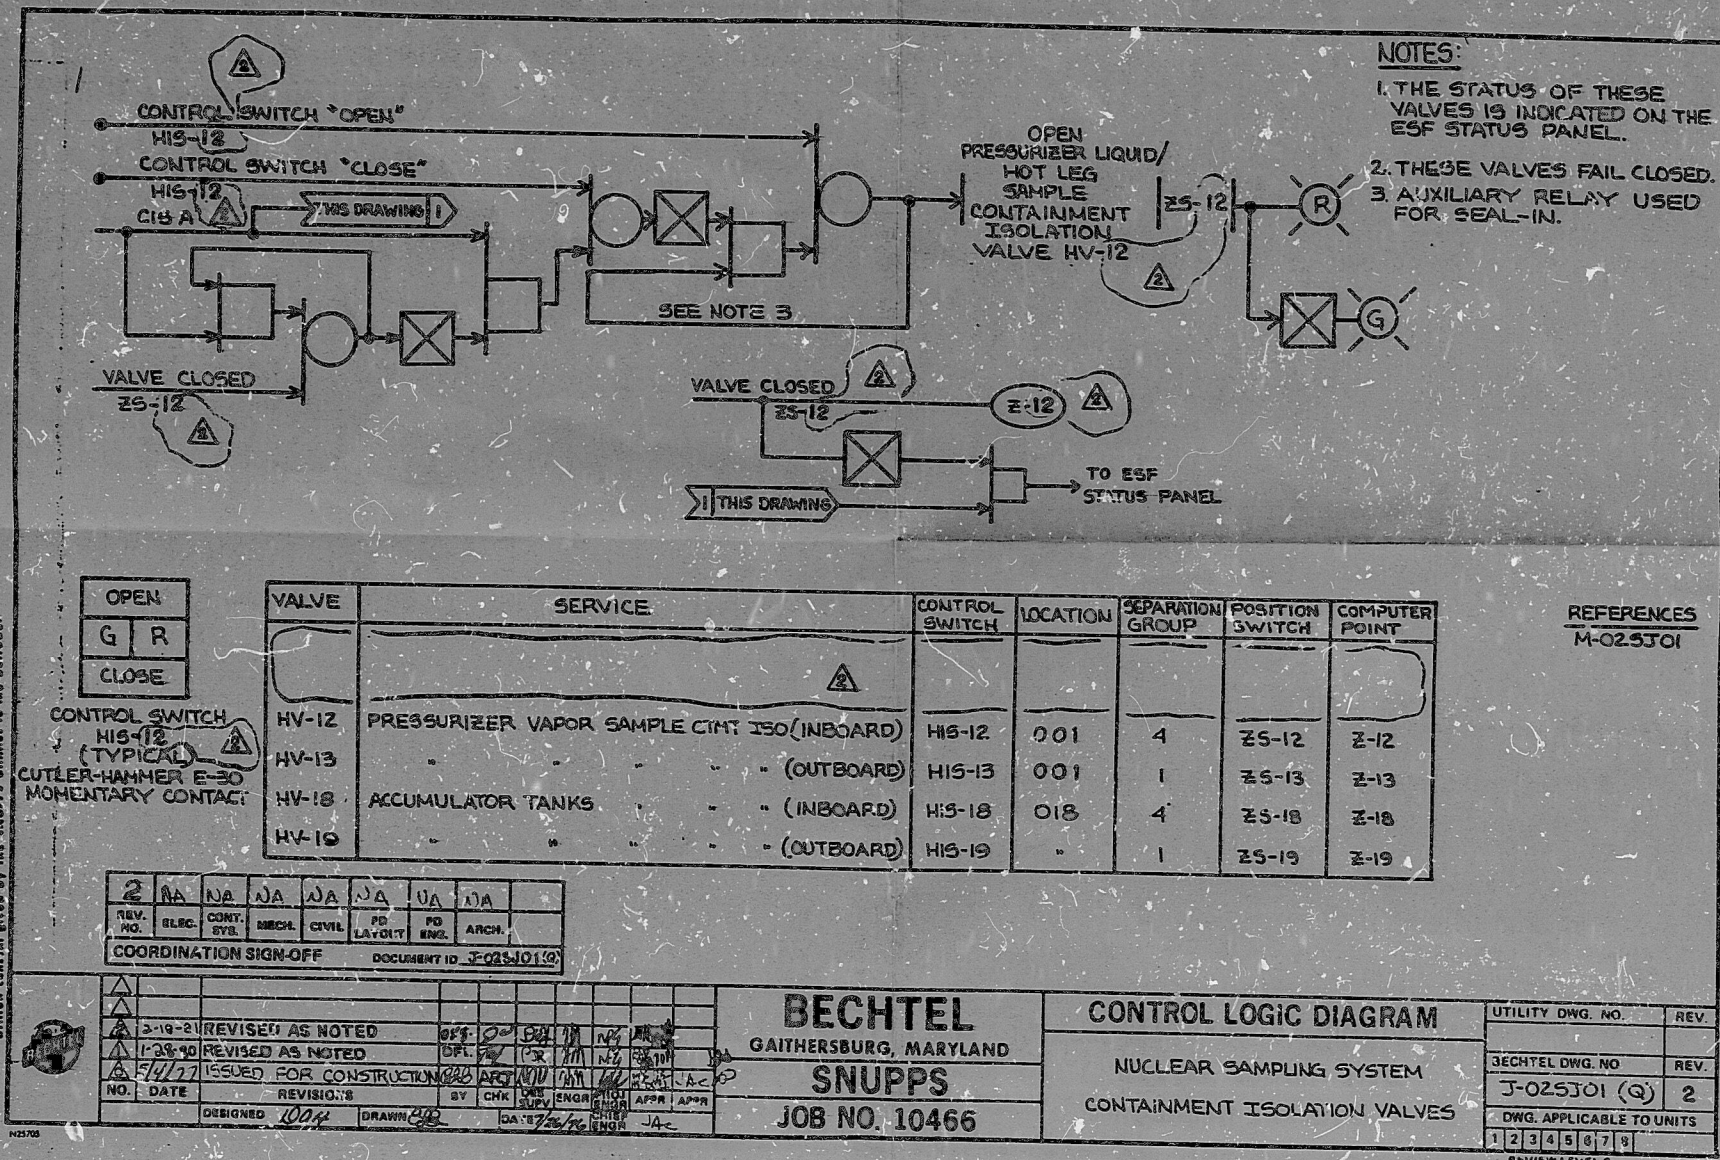

- NOTES:
1. THE STATUS OF THESE VALVES IS INDICATED ON THE ESF STATUS PANEL.
 2. THESE VALVES FAIL CLOSED.
 3. AUXILIARY RELAY USED FOR SEAL-IN.

2	NA	NA	NA	NA	NA	NA	NA
REV. NO.	ELC.	CONT.	MECH.	CIVIL	PD LAYOUT	ENG.	ARCH.
COORDINATION SIGN-OFF				DOCUMENT ID: J-025J01			
BECHTEL GAITHERSBURG, MARYLAND SNUPPS JOB NO. 10466				CONTROL LOGIC DIAGRAM NUCLEAR SAMPLING SYSTEM CONTAINMENT ISOLATION VALVES			
UTILITY DWG. NO. BECHTEL DWG. NO. J-025J01 (G) 2 DWG. APPLICABLE TO UNITS REVIEW LEVEL 2				REV. REV. 2			

I certify that the image contained on this frame was made in the normal and regular course of business, on the date stated below and that it is an accurate reproduction of the document(s) submitted to Micrographics. DATE 2-20-81 OPERATOR [Signature] SUPERVISOR [Signature]

16X

TI
APERTURE
CARD

PDR RIDS

8506200528

