



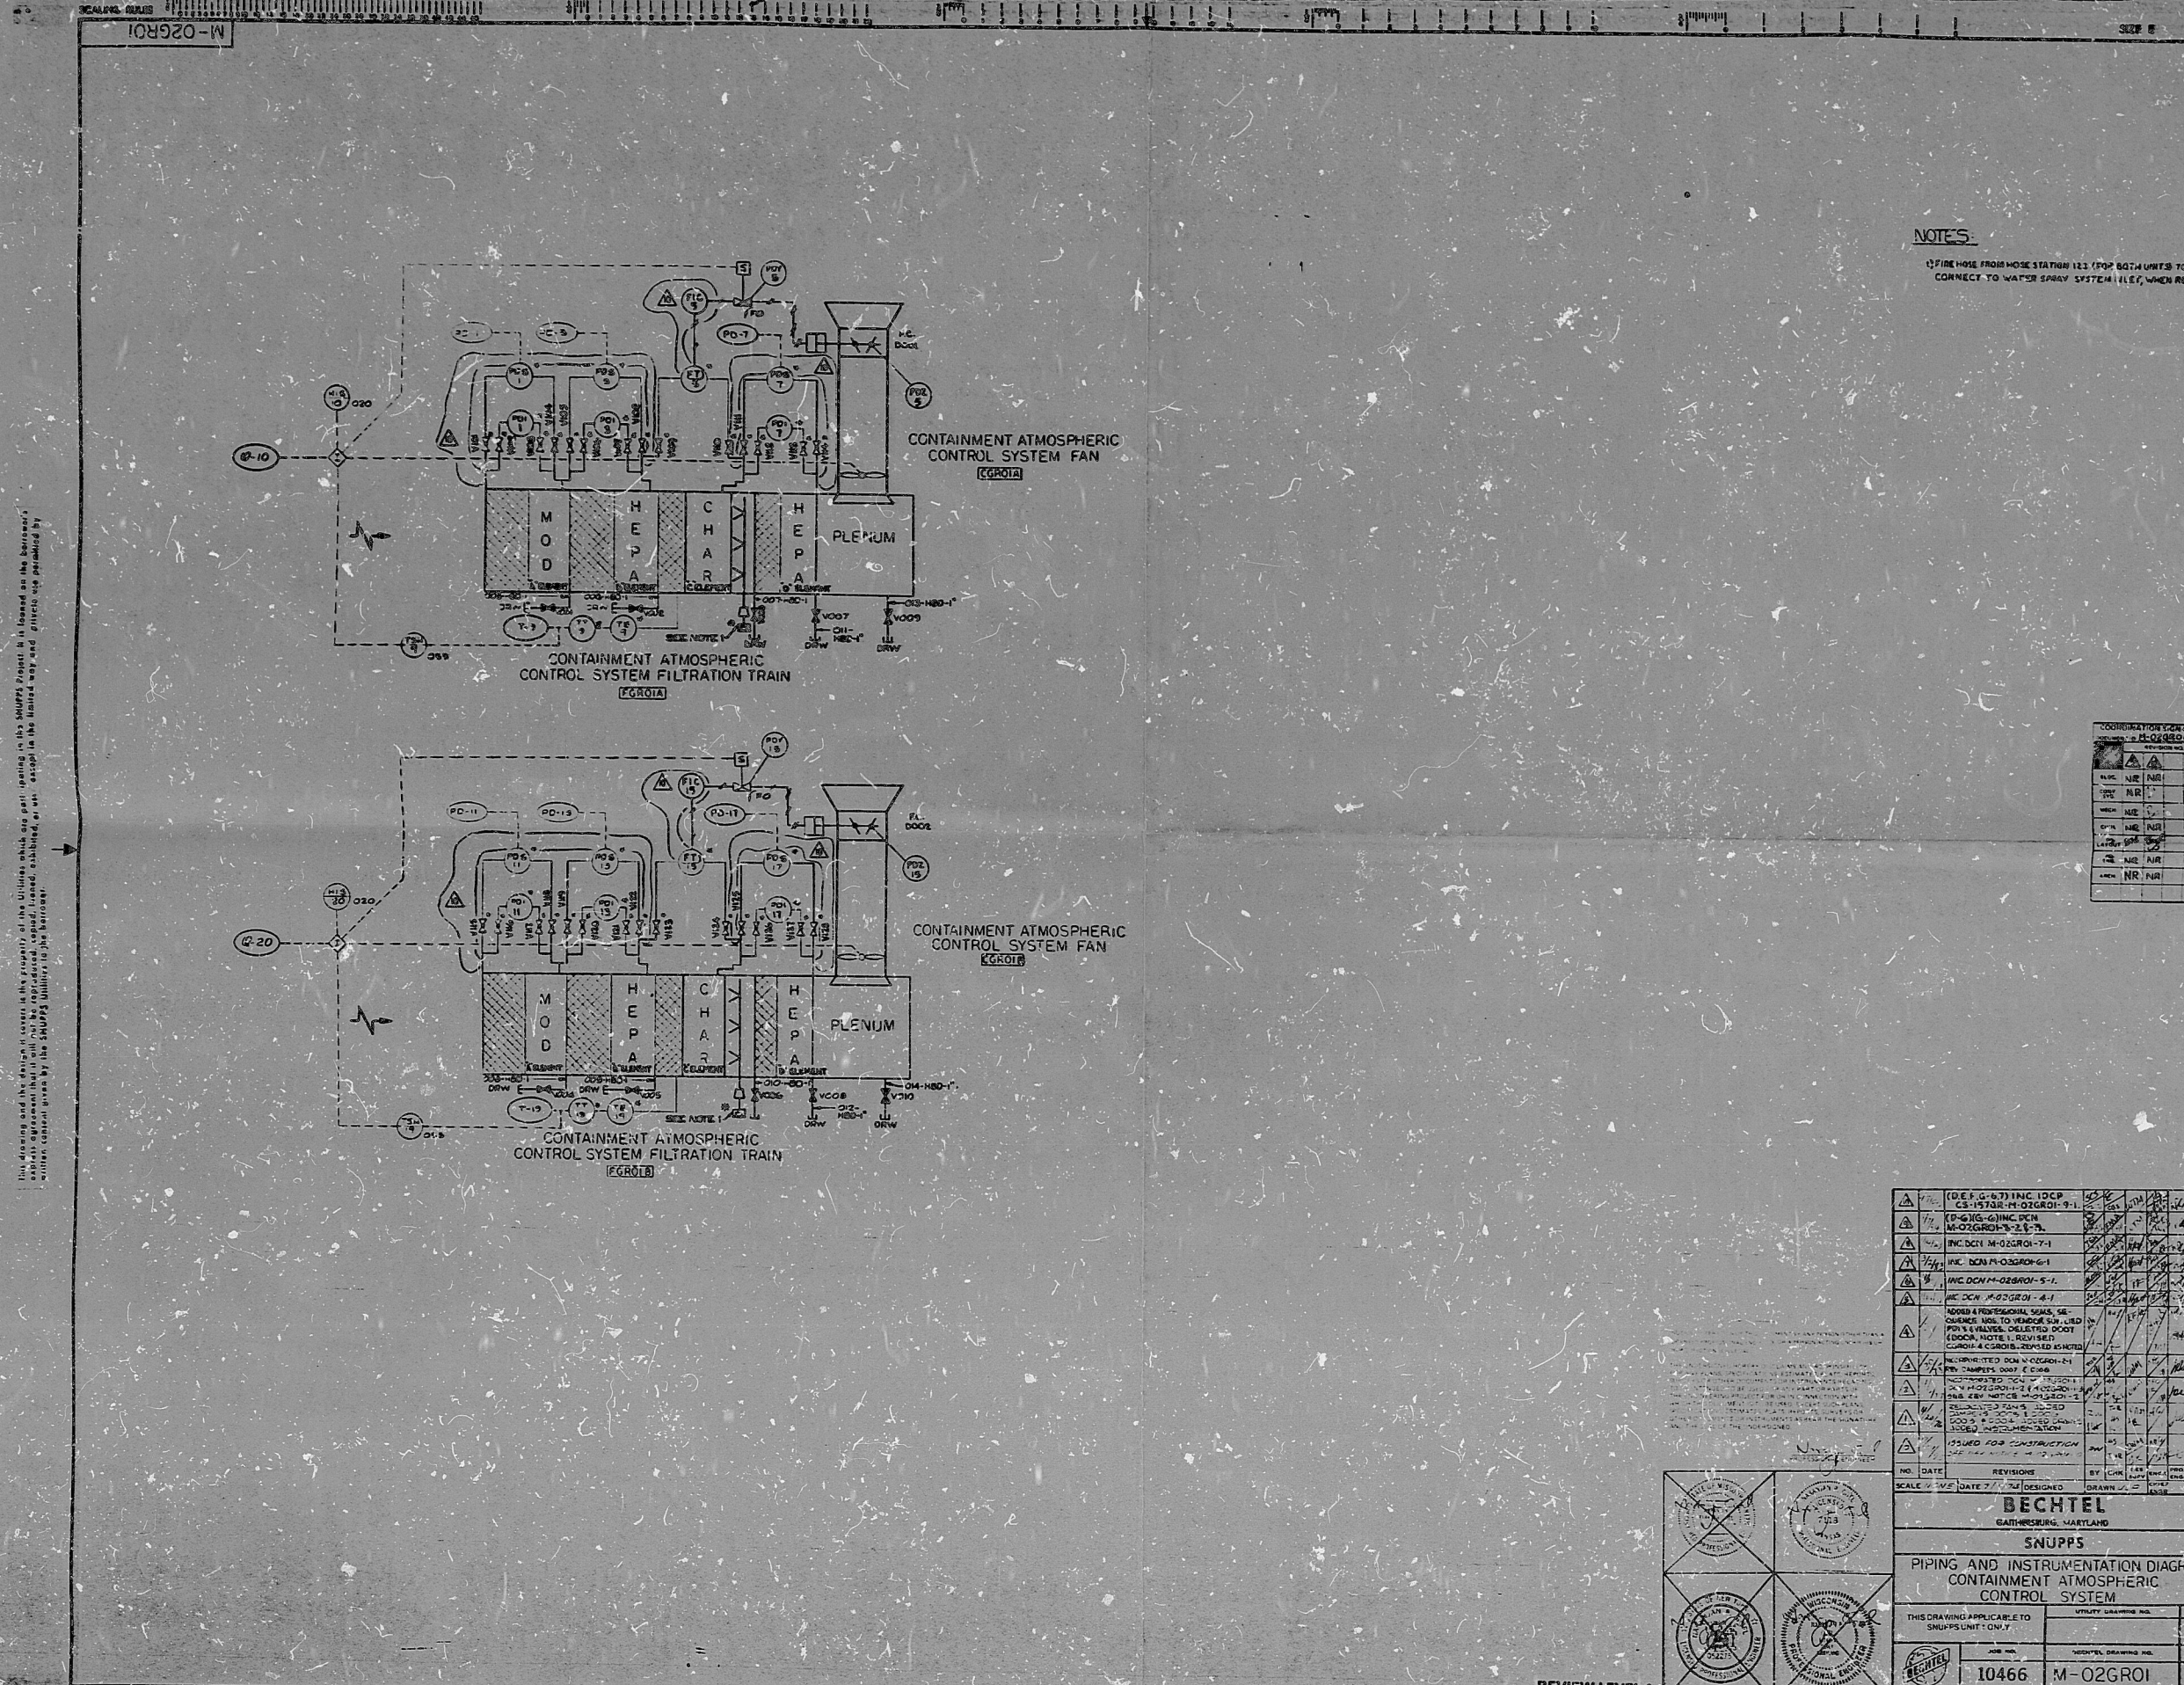

NOTES:
 1. FIRE HOSE FROM HOSE STATION 123 (POP BATH UNITS) TO CONNECT TO WATER SPRAY SYSTEM (IF), WHEN REQUIRED.

COORDINATION CHECKLIST	
NO.	DESCRIPTION
1	NR NR
2	NR NR
3	NR NR
4	NR NR
5	NR NR
6	NR NR
7	NR NR
8	NR NR
9	NR NR
10	NR NR

1	DESIGN (G-1) INC. 10CP	10/1/68	10/1/68	10/1/68
2	DESIGN (G-1) INC. 10CP	10/1/68	10/1/68	10/1/68
3	DESIGN (G-1) INC. 10CP	10/1/68	10/1/68	10/1/68
4	DESIGN (G-1) INC. 10CP	10/1/68	10/1/68	10/1/68
5	DESIGN (G-1) INC. 10CP	10/1/68	10/1/68	10/1/68
6	DESIGN (G-1) INC. 10CP	10/1/68	10/1/68	10/1/68
7	DESIGN (G-1) INC. 10CP	10/1/68	10/1/68	10/1/68
8	DESIGN (G-1) INC. 10CP	10/1/68	10/1/68	10/1/68
9	DESIGN (G-1) INC. 10CP	10/1/68	10/1/68	10/1/68
10	DESIGN (G-1) INC. 10CP	10/1/68	10/1/68	10/1/68

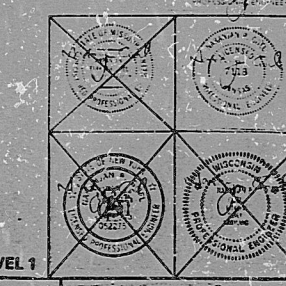

REVISIONS

NO.	DATE	DESCRIPTION	BY	CHKD.
1	10/1/68	DESIGNED	10/1/68	10/1/68

SCALE: 1/4" = 1'-0"

BECHTEL
 BATHURSTON, MARYLAND

SNUPPS

PIPING AND INSTRUMENTATION DIAGRAM
 CONTAINMENT ATMOSPHERIC
 CONTROL SYSTEM

THIS DRAWING APPLICABLE TO
 SNUPPS UNIT: 10466

DATE: 10/1/68

TI
 APERTURE
 CARD

PDR RIDS

8567010029

