


5614-M-3022 SH.3 REV.1

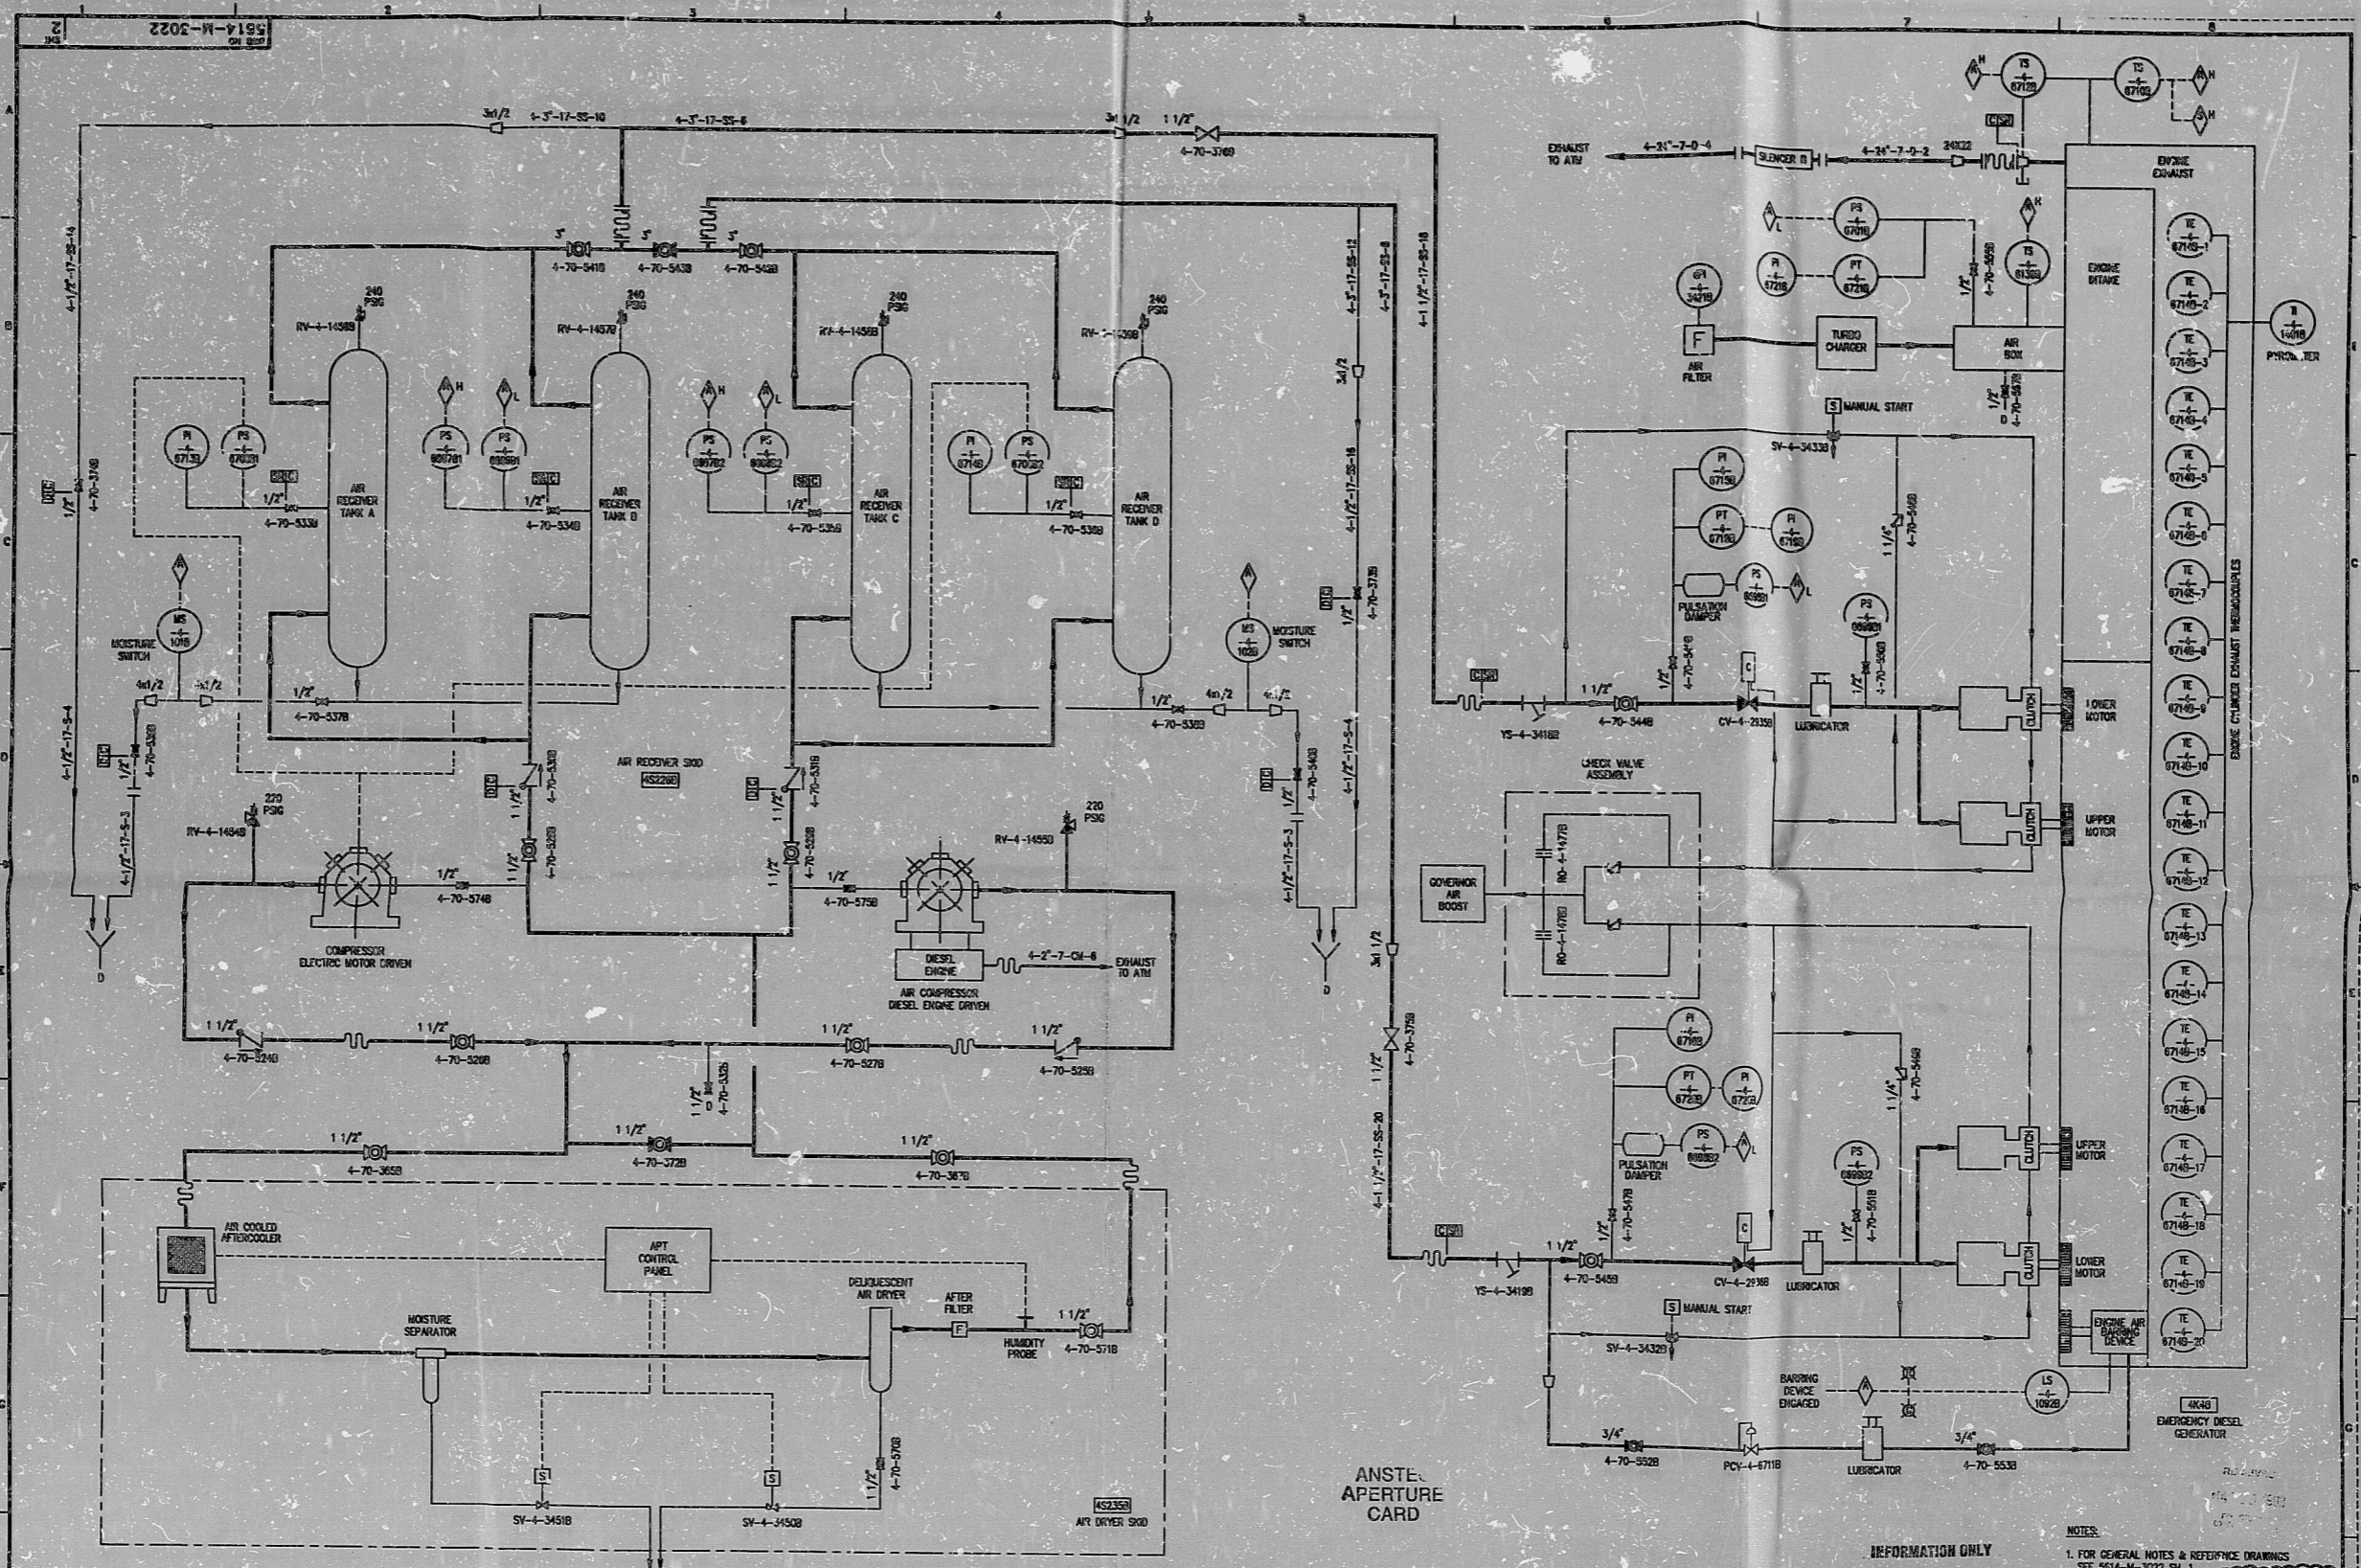

NOTE: THIS DWG IS MADE FROM:

FPL POD	5614-M-736 SH. 3	REV. 5
FPL POD	5614-M-736 SH. 4	REV. 0
FPL PAD	5614-M-16A-17 SH. 1B	REV. 1
FPL PAD	5614-M-16A-20 SH. 1B	REV. 0

REV	DATE	REVISION	BY	CH	APP	APP	REV	DATE
1	5-19-75	ISSUED AS-BUILT FOR DCR-TPM-93-129						
0	3-16-83	THIS DWG. CREATED PER THE P & ID RECONSTRUCTION PROJECT SCOPE AND ISSUED INTO THE FPL DWG SYSTEM PER DCR-TPM-93-026.						



TURKEY POINT NUCLEAR UNIT 4
P & ID

EMERGENCY DIESEL ENGINE AND OIL SYSTEM
EDG 4B AIR STARTING SYSTEM

STONE & WEBSTER ENGINEERING CORP.
FT. LAUDERDALE, FLORIDA

DRAWING NUMBER: 5614-M-3022
SHEET 2

POD
022
REV 1

NOTES:
1. FOR GENERAL NOTES & REFERENCE DRAWINGS SEE 5614-M-3022 SH. 1.

INFORMATION ONLY

POD

022
REV 1

U11M02273.DWG

9406210198

PDR RIDS

