


5614-M-3022 SH.4 REV.2

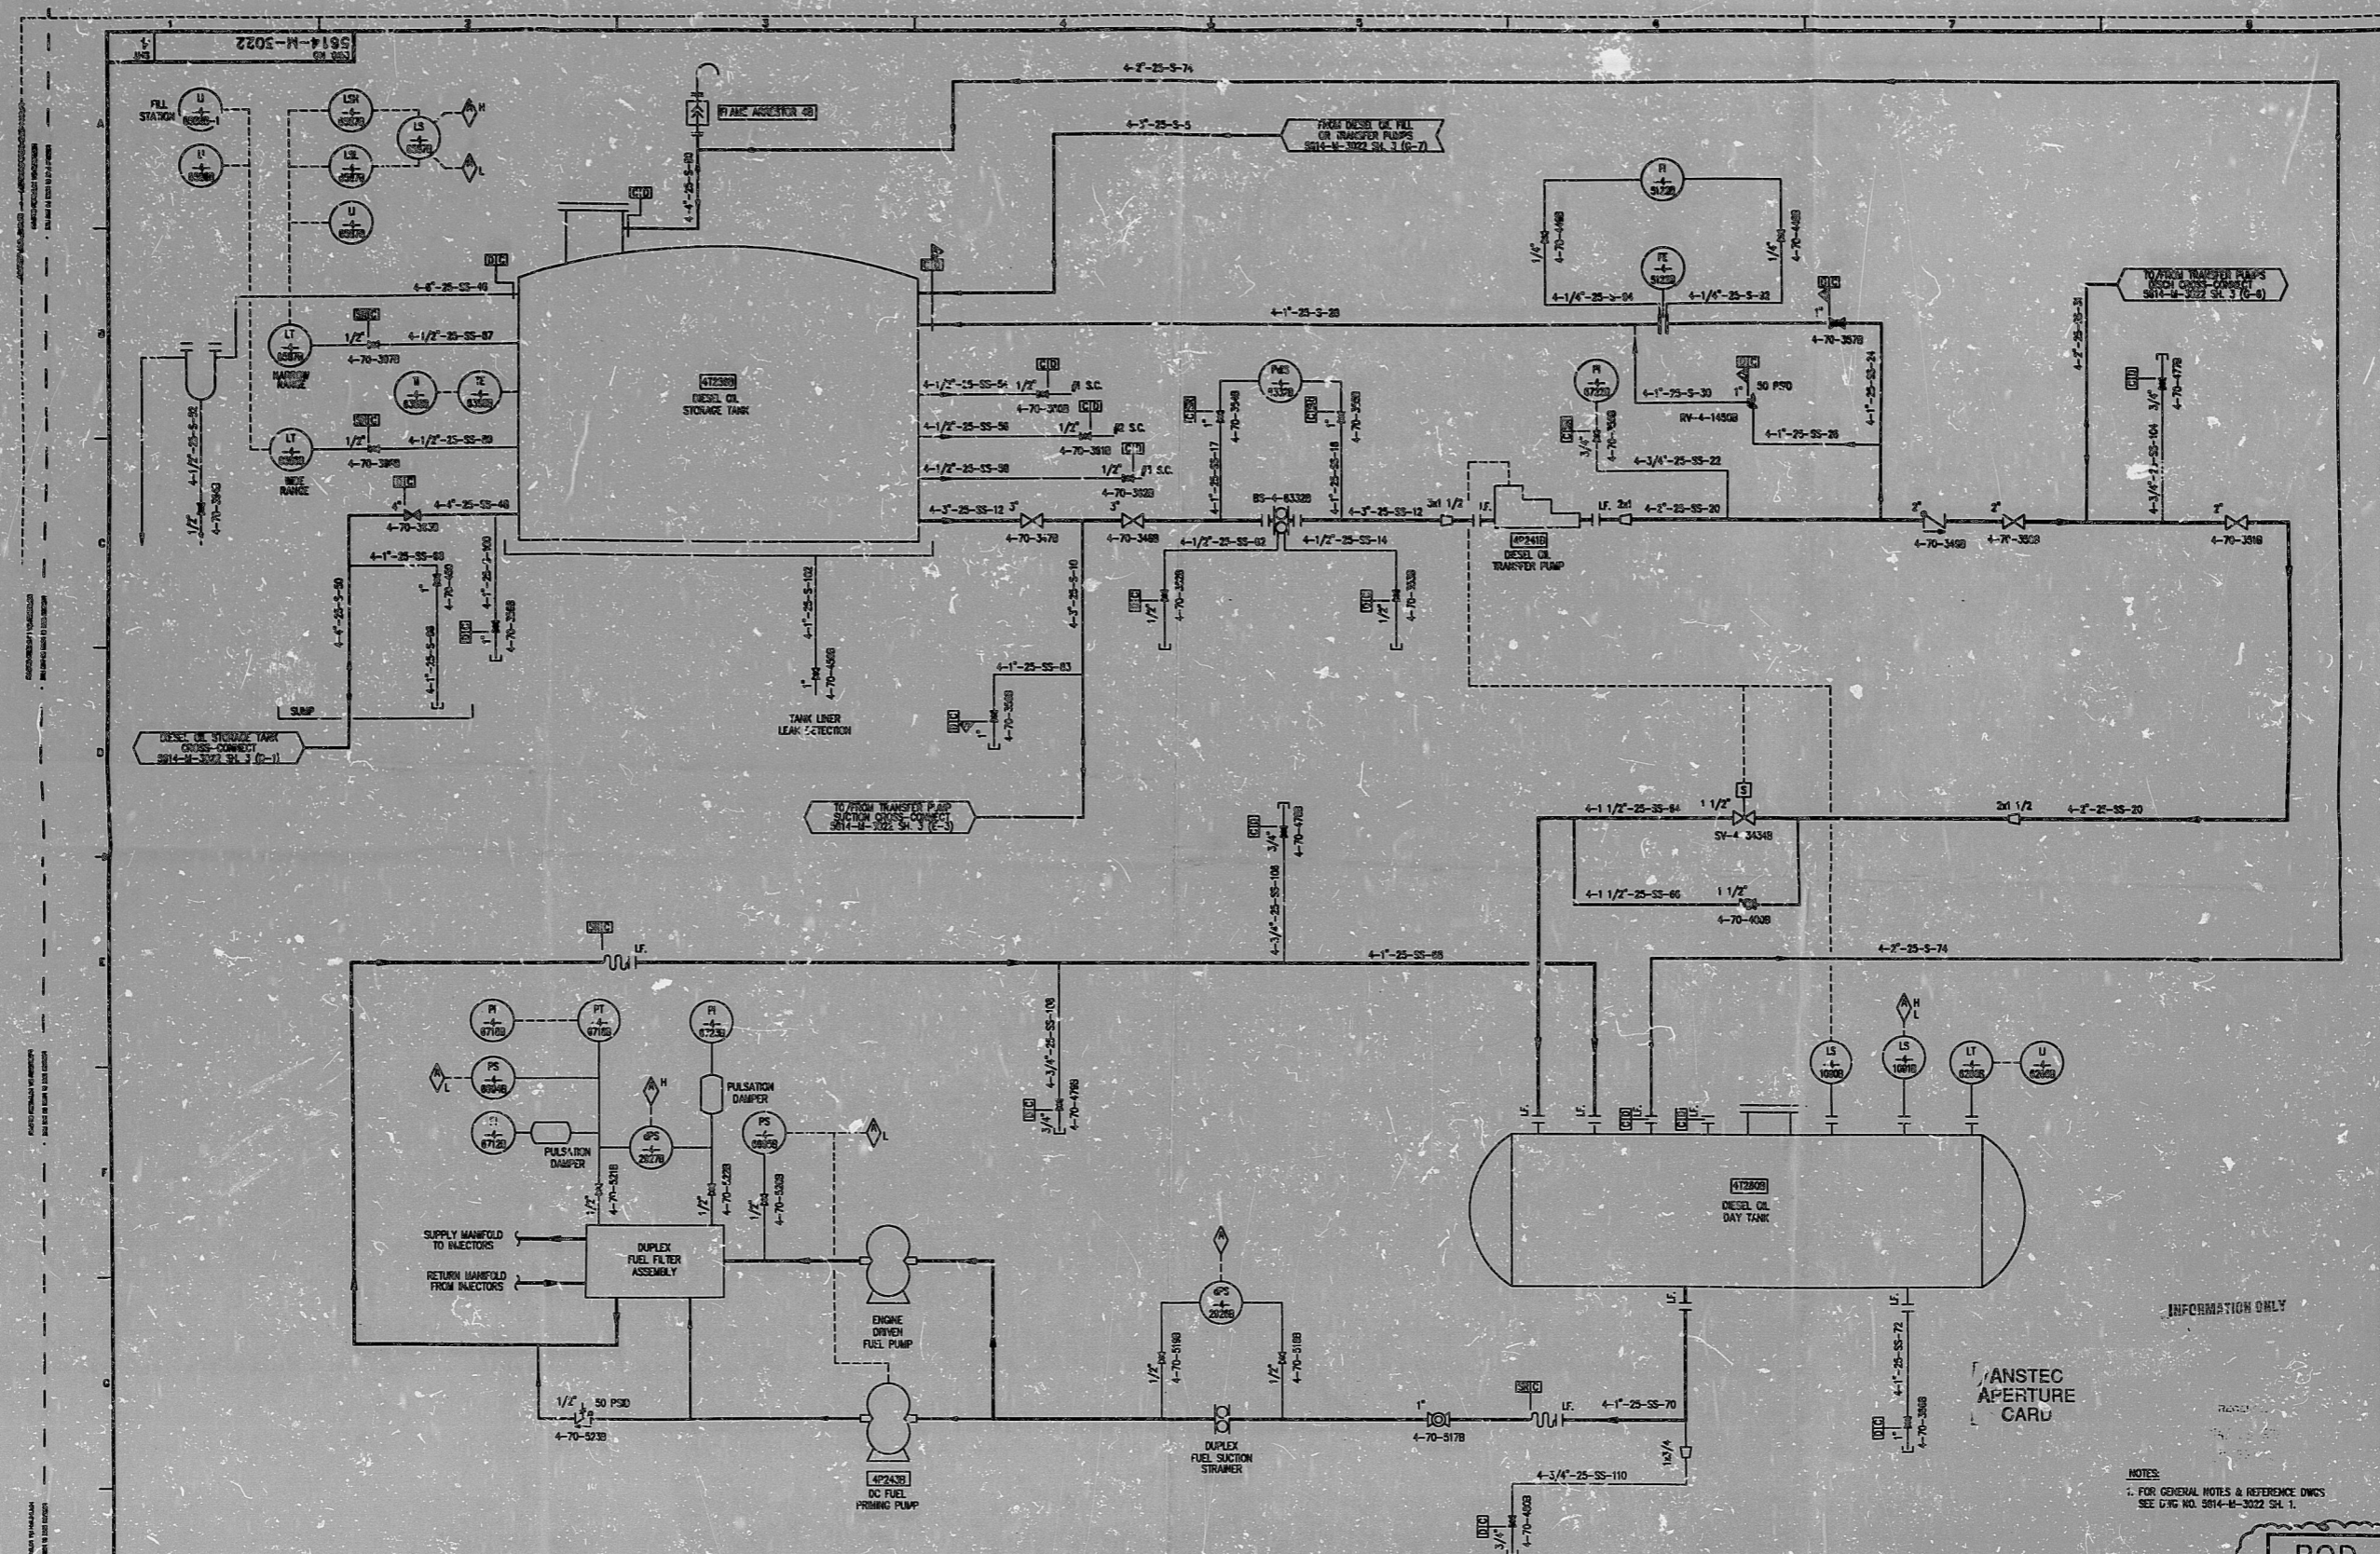

NOTE: THIS DWG IS MADE FROM:  
 FPL POD 5614-M-736 SH.1 REV. 2  
 FPL POD 5614-M-736 SH.3 REV. 5  
 FPL POD 5614-M-15A-14 SH.1B REV. 0

REV	DATE	REVISION	BY	CHK	APP	APP	REV	DATE	REVISION
2	5-19-92	ISSUED AS-BUILT FOR DCR-TM-93-129							
1	04-19-93	INCORPORATED CRN-M-5781 FOR PC/M 93-046							
0	3-18-93	THIS DWG CREATED PER THE P & ID RECONSTRUCTION PROJECT SCOPE AND ISSUED INTO THE FPL DWG SYSTEM PER DCR-TM-93-026							

TURKEY POINT NUCLEAR UNIT 4		POD	
P. & I. D.		STONE & WEBSTER ENGINEERING CORP. FT. LAUDERDALE, FLORIDA	
EMERGENCY DIESEL ENGINE AND OIL SYSTEM EDG 4B FUEL SYSTEM		DRAWING NUMBER	5614-M-3022
		SHEET	4
		SIZE	22
		REV	2
		DATE	01/05/95

NOTES:  
 1. FOR GENERAL NOTES & REFERENCE DWGS SEE DWG NO. 5614-M-3022 SH. 1.

INFORMATION ONLY

ANSTEC  
 APERTURE  
 CARU

9406210214

DDR RIDS

