


5614-M-3022 SH.3 REV.1



NOTE: THIS DWG IS MADE FROM:
 FPL PCD 5614-M-736 SH.1 REV.3
 FPL PCD 5614-M-736 SH.2 REV.5
 FPL PCD 5614-M-16A-14 SH.1A REV.0

REV	DATE	REVISION	BY	CH	APP	APP	REV	DATE	REVISION
1	3-18-81	ISSUED AS-BUILT FOR DCR-TPM-83-120	SM	MD	LSB	NAW			
0	3-18-81	THIS DWG CREATED PER THE P & ID RECONSTRUCTION PROJECT SCOPE AND ISSUED INTO THE FPL DWG SYSTEM PER DCR-TPM-83-026.	SM	MD	LSB	NAW			

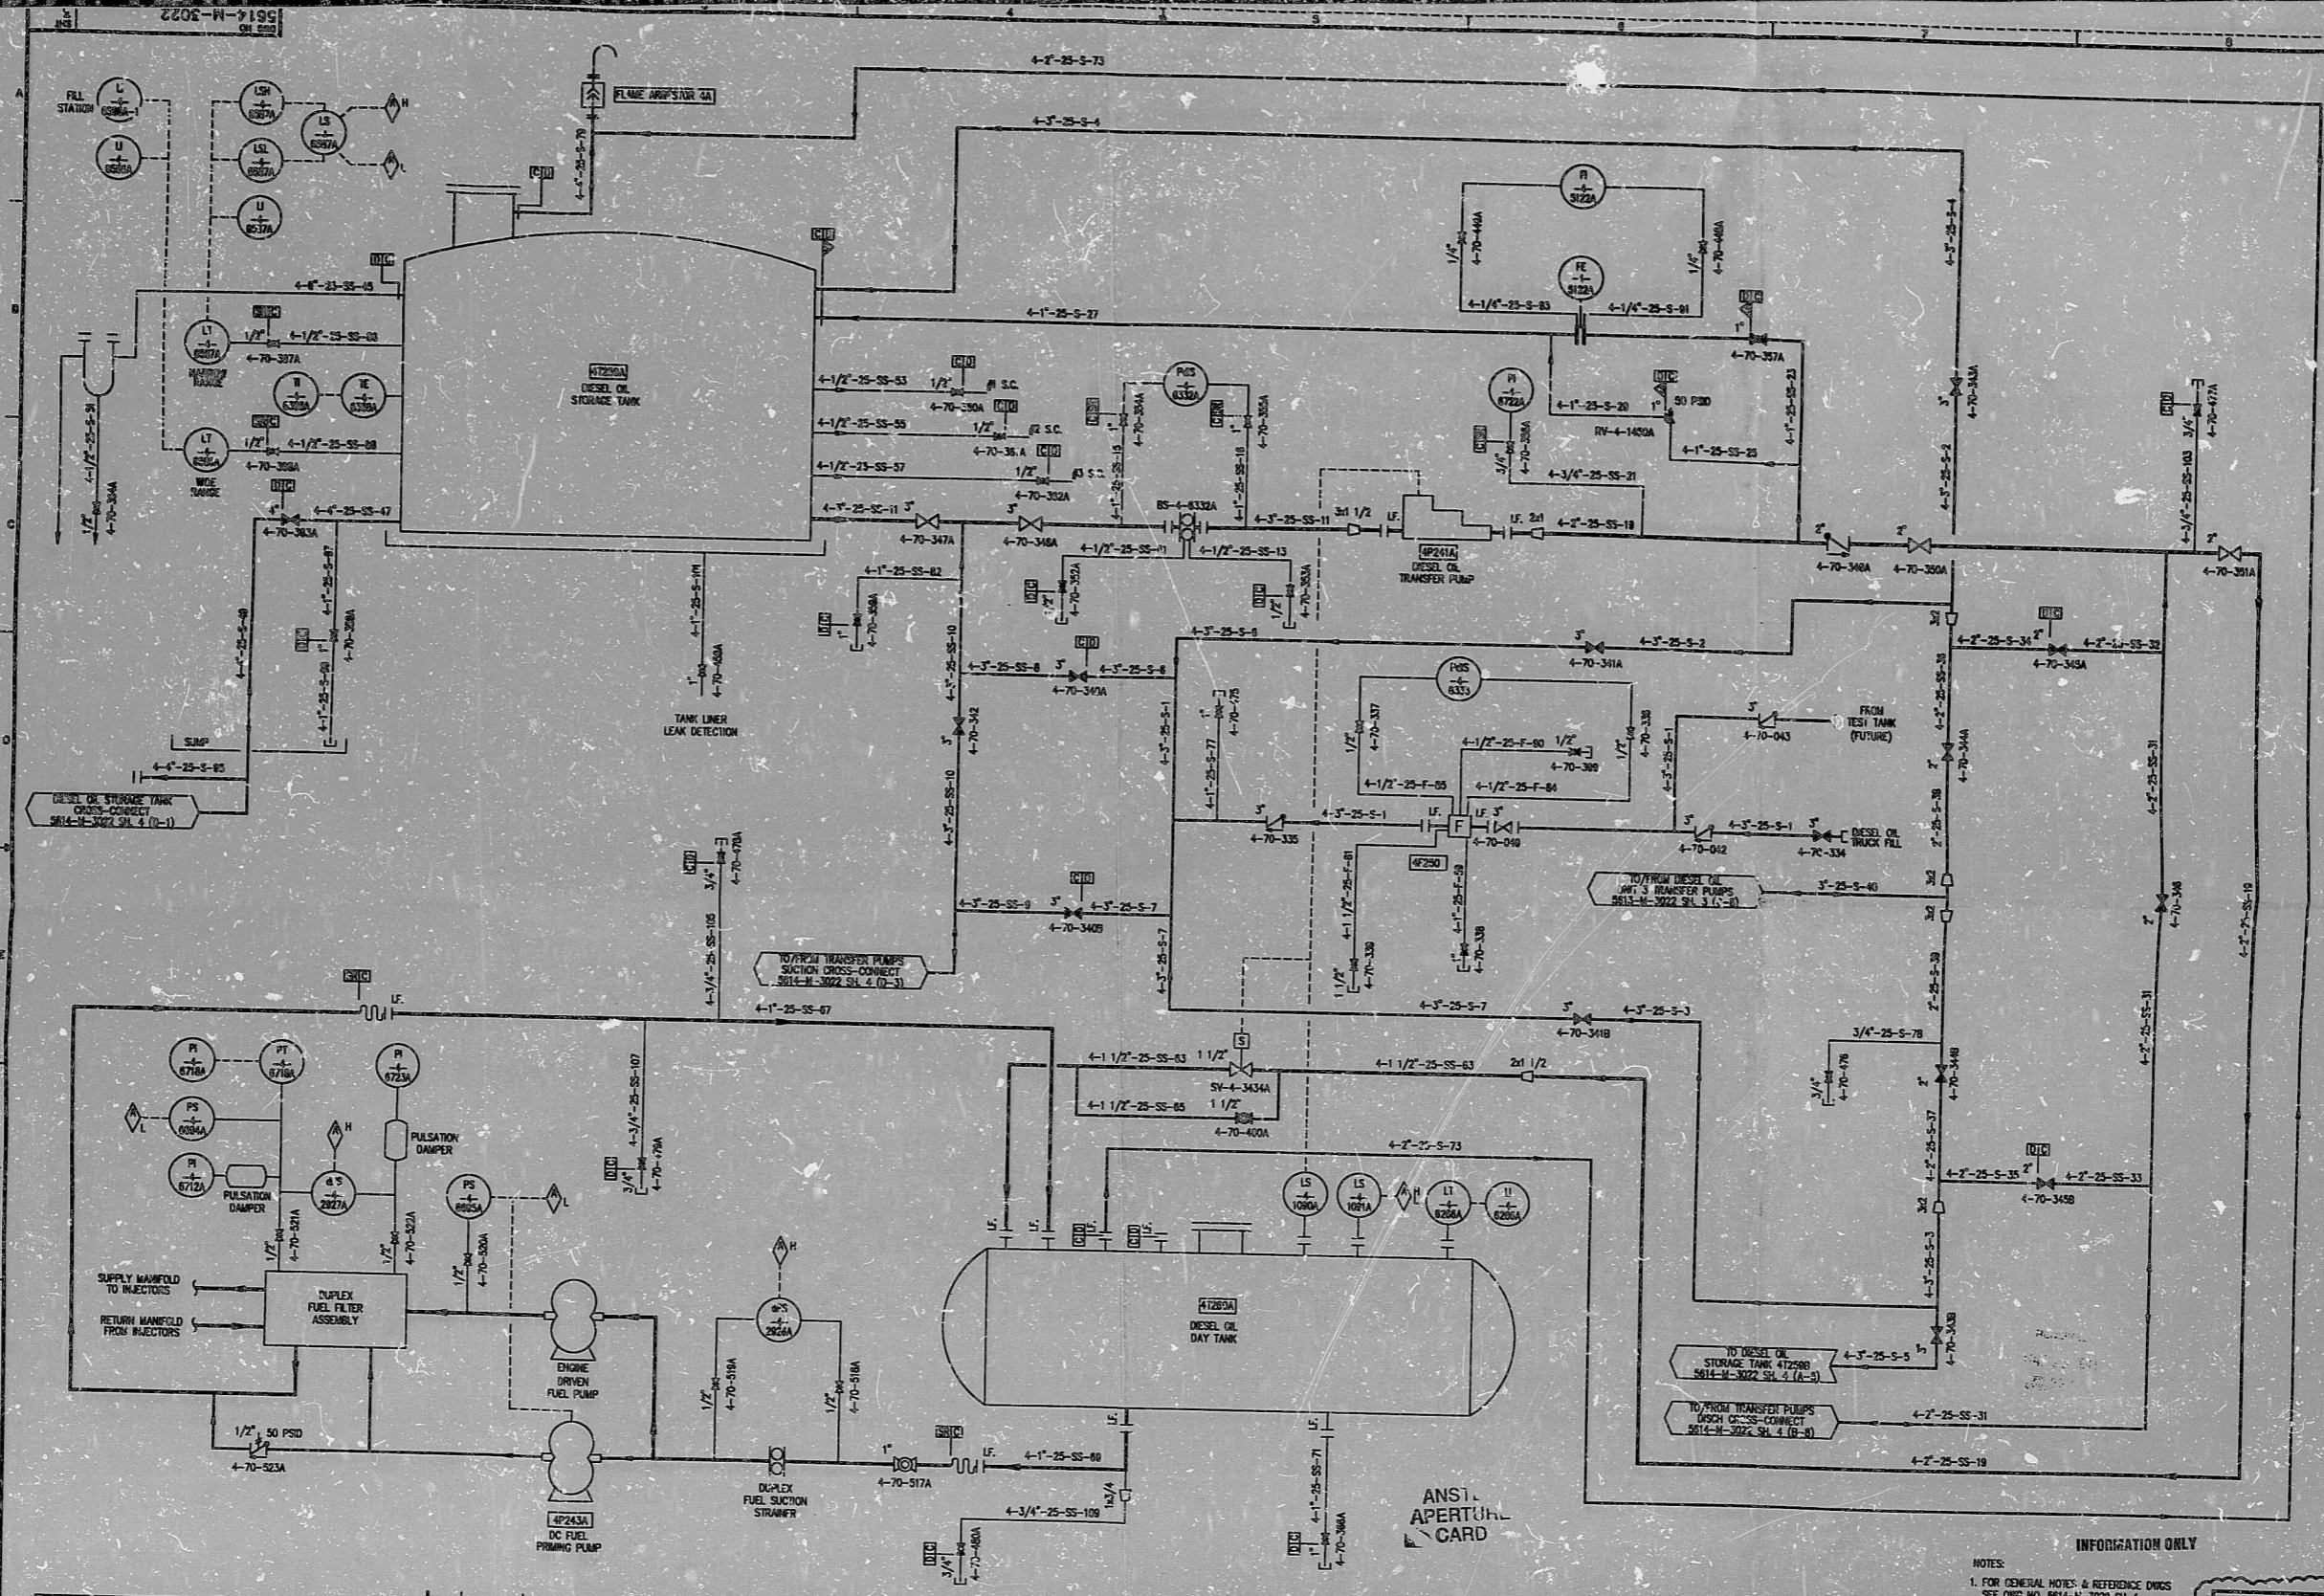

TURKEY POINT NUCLEAR UNIT 4
 P & ID
 EMERGENCY DIESEL ENGINE AND OIL SYSTEM EDG 4A FUEL SYSTEM

STONE & WEBSTER ENGINEERING CORP.
 FT. LAUDERDALE, FLORIDA

DRAWING NUMBER: 5614-M-3022
 SHEET 3

SYN: 022
 REV: 1

UTMKS274.DWG

NOTES:
 1. FOR GENERAL NOTES & REFERENCE DWGS SEE DWG NO. 5614-M-3022 SH.1.

PCD

9406220396

PDR RIDS

