


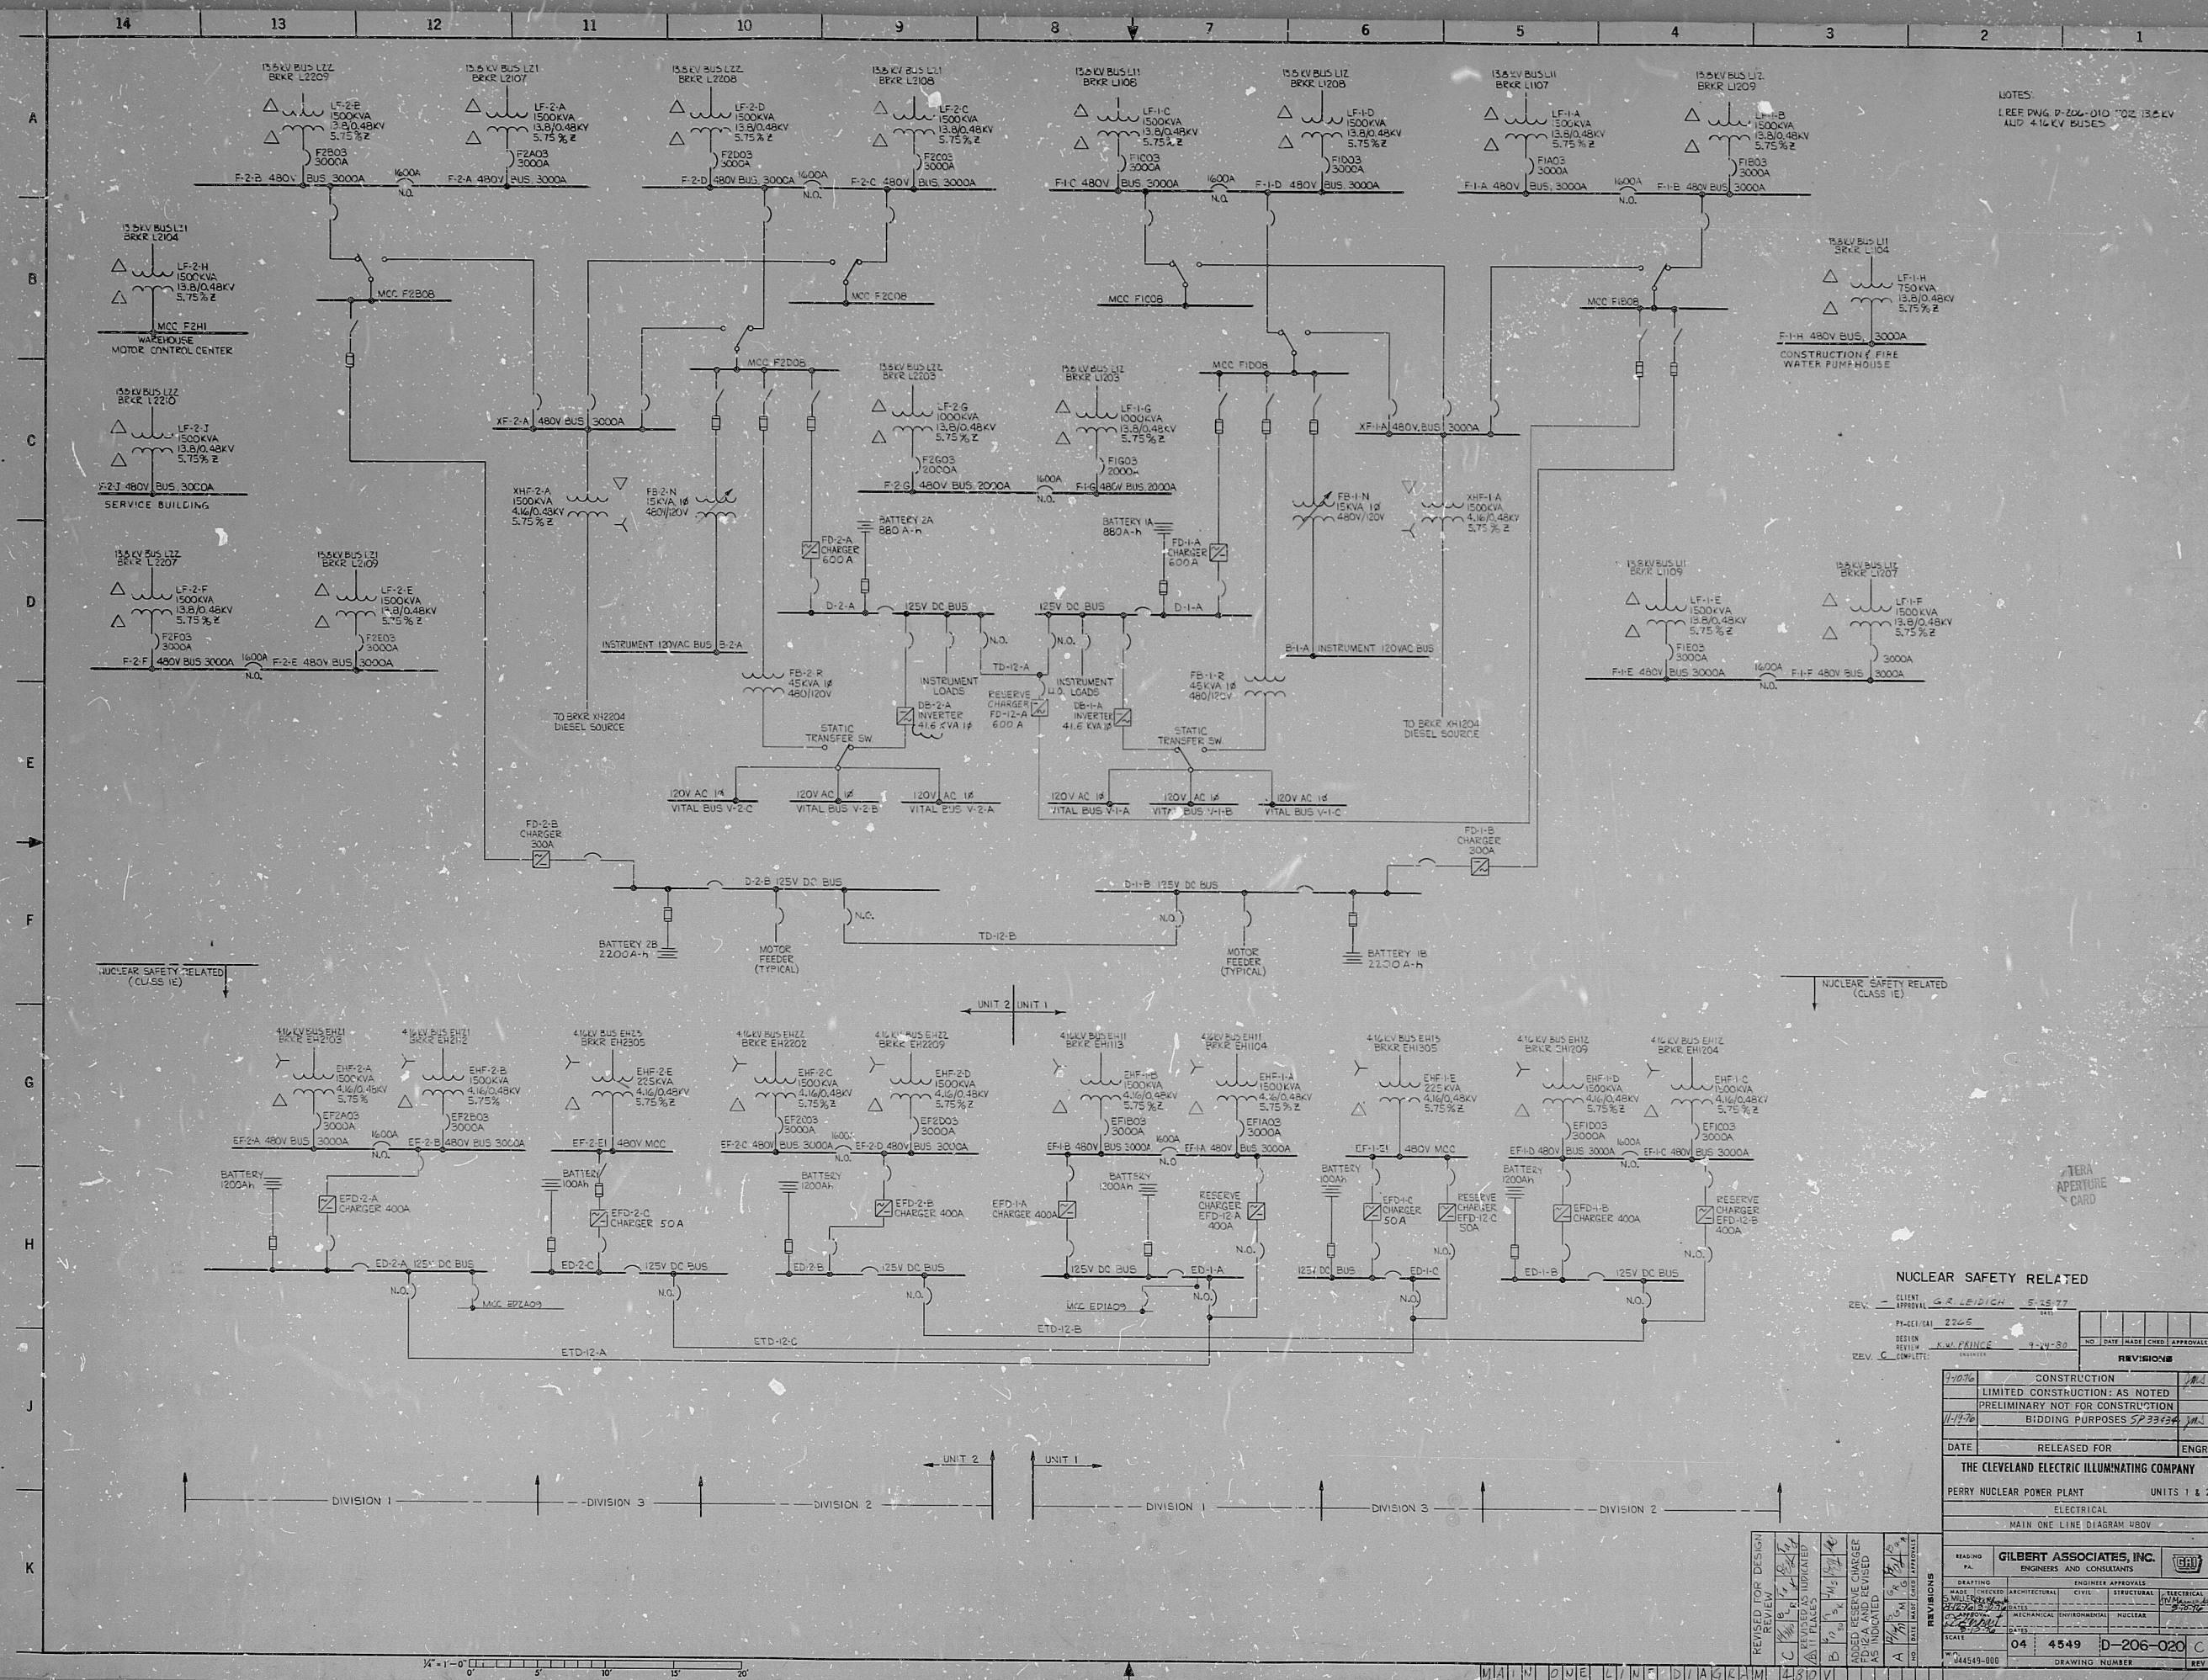

NOTES:
1. SEE DWG. D-206-010 FOR 13.8KV AND 4.16KV BUSES

NUCLEAR SAFETY RELATED

REV.	CLIENT	DATE	BY	CHKD	APPROVAL
1	GR LEBRON	5-15-77			
2	2745				
3	K.W. PRINCE	9-24-80			
4					

DATE	RELEASED FOR	ENGR
11-17-76		
THE CLEVELAND ELECTRIC ILLUMINATING COMPANY		
PERRY NUCLEAR POWER PLANT		
ELECTRICAL		
MAIN ONE LINE DIAGRAM 480V		

REVISIONS	REASON	DATE	BY	CHKD	APPROVAL
1	FOR DESIGN	5-15-77			
2	FOR CONSTRUCTION	11-17-76			
3	FOR REVISION	9-24-80			
4	FOR REVISION				
5	FOR REVISION				
6	FOR REVISION				
7	FOR REVISION				
8	FOR REVISION				
9	FOR REVISION				
10	FOR REVISION				

GILBERT ASSOCIATES, INC.
ENGINEERS AND CONSULTANTS

SCALE: 1"=100'

DWG. NO. 4549 D-206-020 C

DATE: 04-19-80

8104100379

