


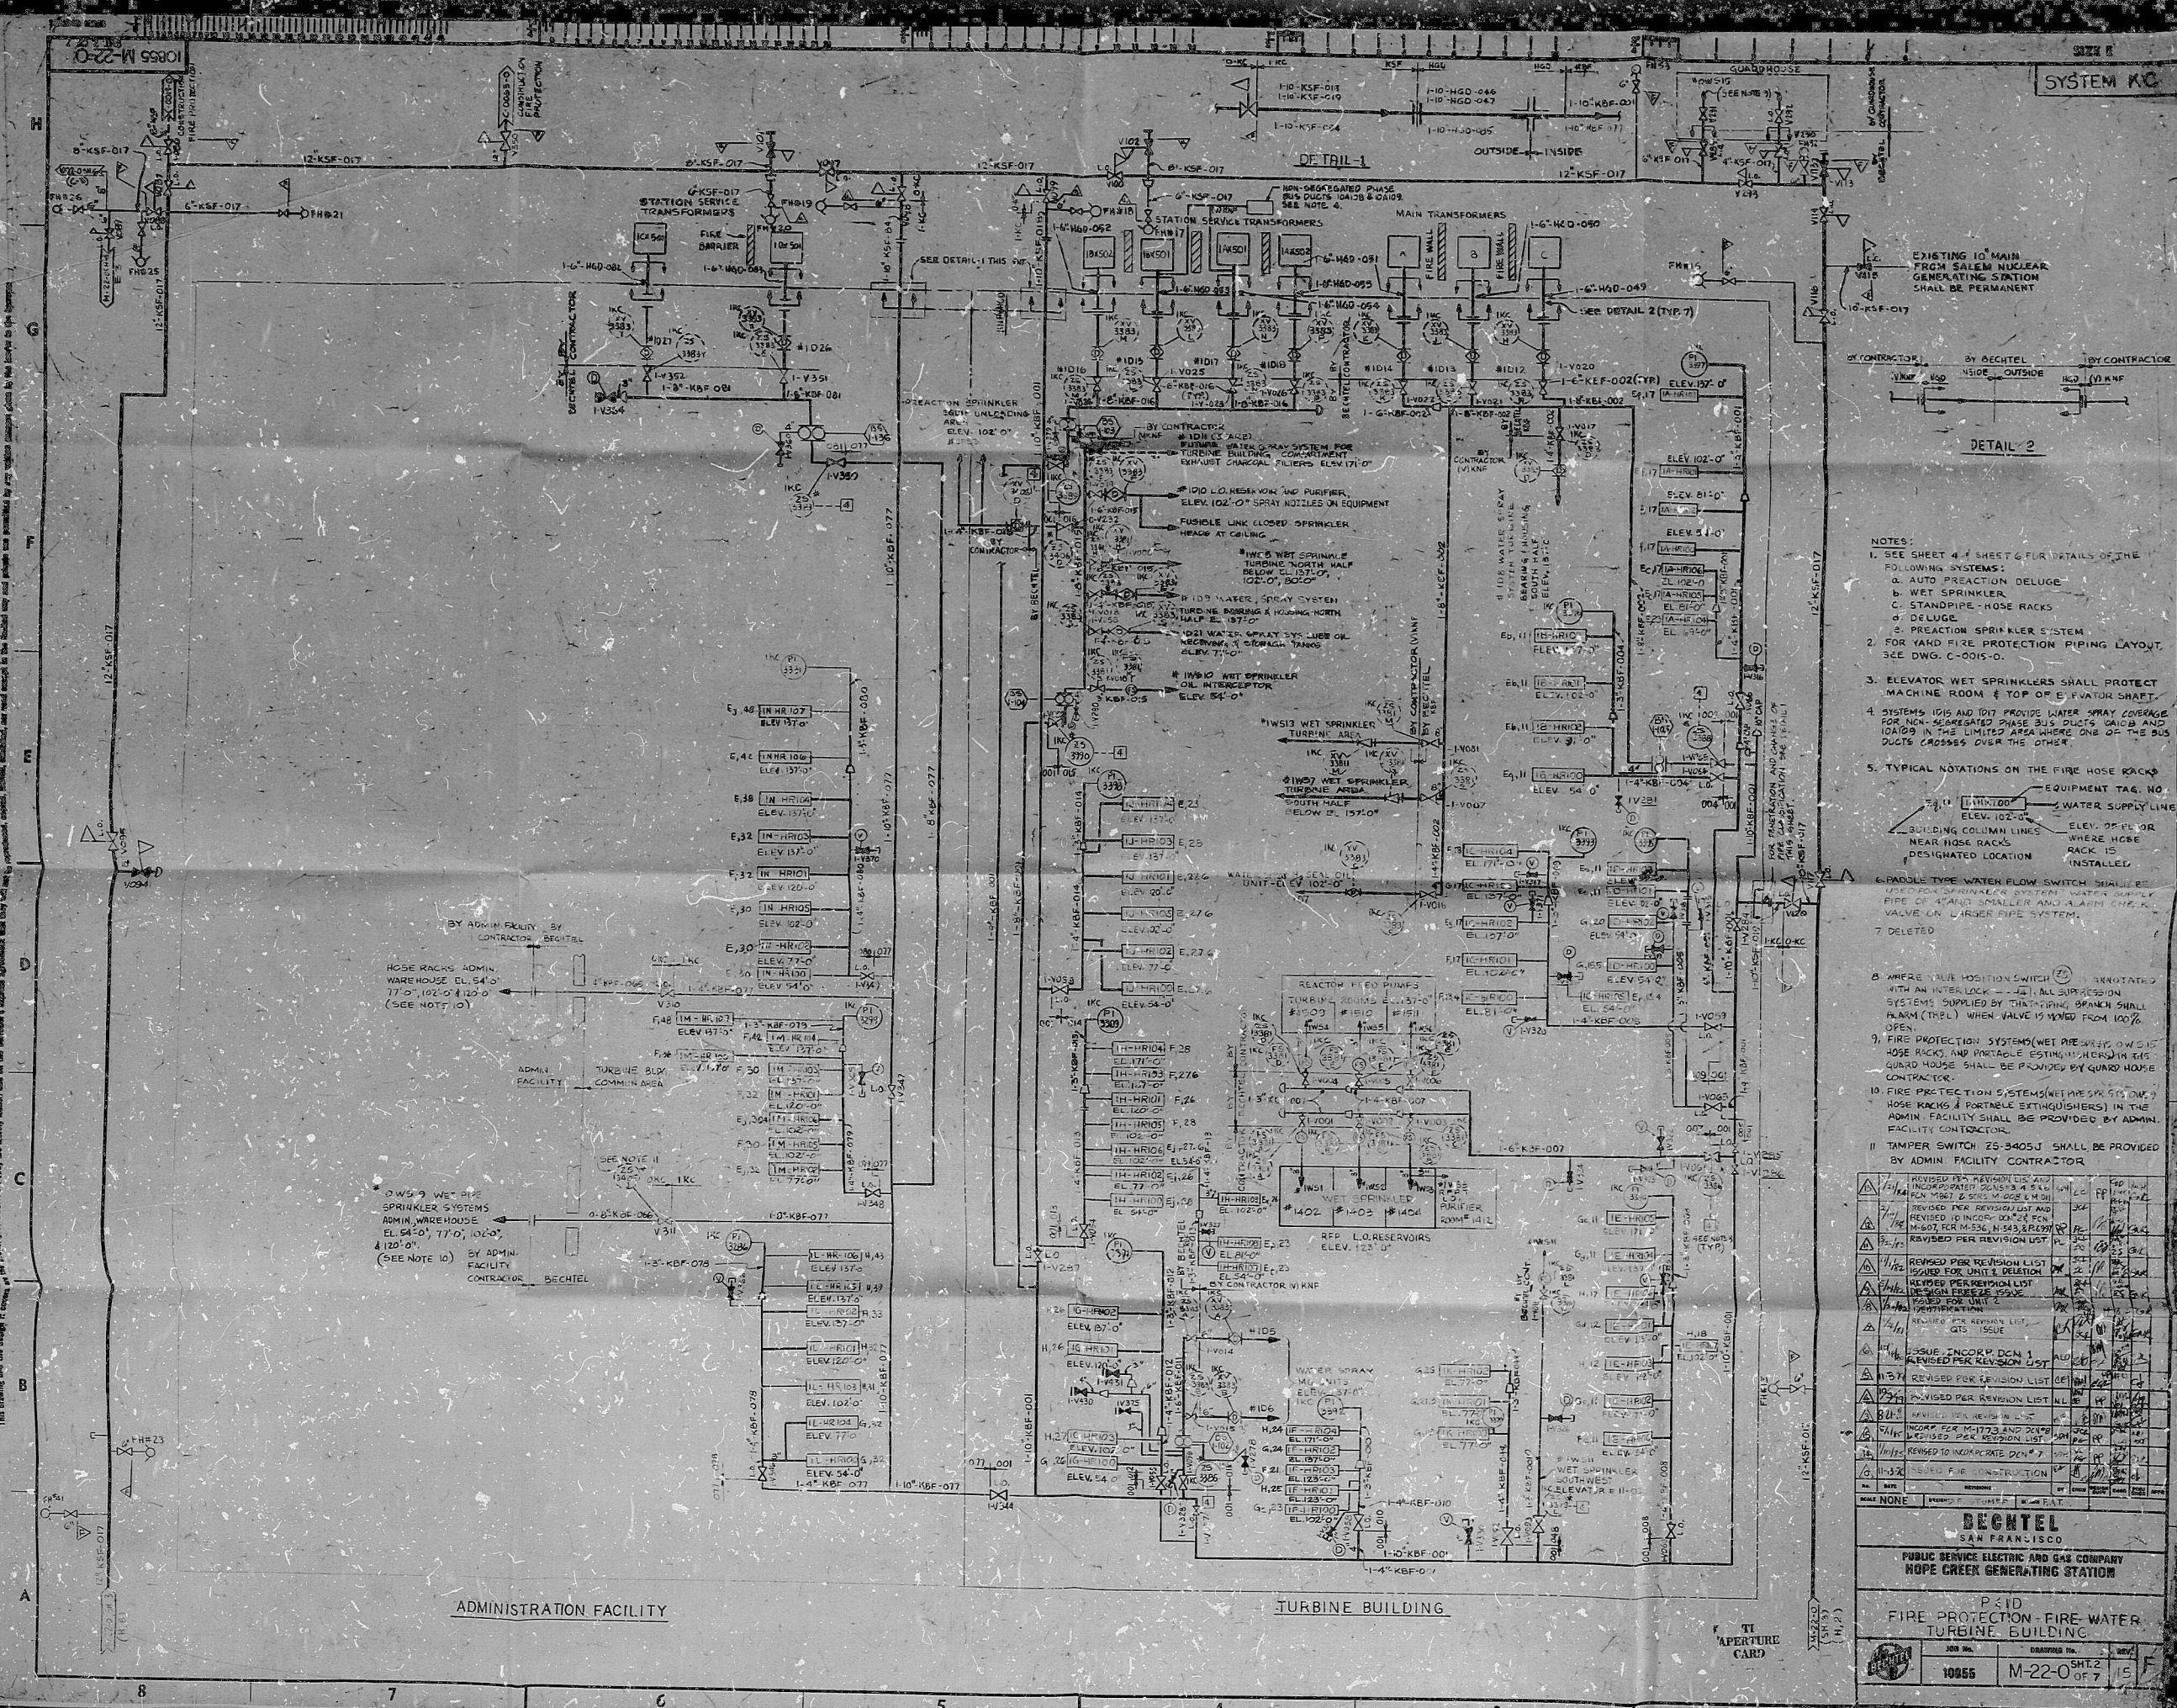

- NOTES:
- SEE SHEET 4-1 SHEET 6 FOR DETAILS OF THE FOLLOWING SYSTEMS:
A. AUTO PREACTION DELUGE
B. WET SPRINKLER
C. STANDPIPE HOSE RACKS
D. DELUGE
E. PREACTION SPRINKLER SYSTEM
 - FOR HARD FIRE PROTECTION PIPING LAYOUT, SEE DWG. C-2015-0.
 - ELEVATOR WET SPRINKLERS SHALL PROTECT MACHINE ROOM & TOP OF ELEVATOR SHAFT.
 - SYSTEMS 1015 AND 1017 PROVIDE WATER SPRAY COVERAGE FOR NON-SEPARATED PHASE BUS DUCTS 10A10 AND 10A09 IN THE LIMITED AREA WHERE ONE OF THE BUS DUCTS CROSSES OVER THE OTHER.
 - TYPICAL NOTATIONS ON THE FIRE HOSE RACKS:
EQUIPMENT TAG NO.
WATER SUPPLY LINE
ELEV. OF FLOOR
WHERE HOSE RACK IS INSTALLED
DESIGNATED LOCATION
 6. PADLOCK TYPE WATER FLOW SWITCH SHALL BE USED FOR SPRINKLER SYSTEM. WATER SUPPLY PIPE OF 1/2" OR SMALLER AND A 1/2" ALARM CHECK VALVE ON LARGER PIPE SYSTEM.
 7. DELETED
 8. WHERE VALVE POSITION SWITCH IS INDICATED WITH AN INTERLOCK, ALL SUPPRESSION SYSTEMS SUPPLIED BY CHARTING BRANCH SHALL BE OPEN WHEN VALVE IS MOVED FROM 100% OPEN.
 9. FIRE PROTECTION SYSTEMS (WET PREACTION, WET HOSE RACKS, AND PORTABLE EXTINGUISHERS) IN THE GUARD HOUSE SHALL BE PROVIDED BY GUARD HOUSE CONTRACTOR.
 10. FIRE PROTECTION SYSTEMS (WET PREACTION, WET HOSE RACKS & PORTABLE EXTINGUISHERS) IN THE ADMIN. FACILITY SHALL BE PROVIDED BY ADMIN. FACILITY CONTRACTOR.
 11. TAMPER SWITCH 25-3405J SHALL BE PROVIDED BY ADMIN. FACILITY CONTRACTOR.

NO.	DATE	REVISION	BY	CHKD.	APPD.
1	10/15/55	REVISED PER REVISION LIST AND INCORPORATED DCM 1	...	...	...
2	10/15/55	REVISED PER REVISION LIST AND INCORPORATED DCM 1	...	...	...
3	10/15/55	REVISED PER REVISION LIST AND INCORPORATED DCM 1	...	...	...
4	10/15/55	REVISED PER REVISION LIST AND INCORPORATED DCM 1	...	...	...
5	10/15/55	REVISED PER REVISION LIST AND INCORPORATED DCM 1	...	...	...
6	10/15/55	REVISED PER REVISION LIST AND INCORPORATED DCM 1	...	...	...
7	10/15/55	REVISED PER REVISION LIST AND INCORPORATED DCM 1	...	...	...
8	10/15/55	REVISED PER REVISION LIST AND INCORPORATED DCM 1	...	...	...
9	10/15/55	REVISED PER REVISION LIST AND INCORPORATED DCM 1	...	...	...
10	10/15/55	REVISED PER REVISION LIST AND INCORPORATED DCM 1	...	...	...
11	10/15/55	REVISED PER REVISION LIST AND INCORPORATED DCM 1	...	...	...
12	10/15/55	REVISED PER REVISION LIST AND INCORPORATED DCM 1	...	...	...
13	10/15/55	REVISED PER REVISION LIST AND INCORPORATED DCM 1	...	...	...
14	10/15/55	REVISED PER REVISION LIST AND INCORPORATED DCM 1	...	...	...
15	10/15/55	REVISED PER REVISION LIST AND INCORPORATED DCM 1	...	...	...
16	10/15/55	REVISED PER REVISION LIST AND INCORPORATED DCM 1	...	...	...
17	10/15/55	REVISED PER REVISION LIST AND INCORPORATED DCM 1	...	...	...
18	10/15/55	REVISED PER REVISION LIST AND INCORPORATED DCM 1	...	...	...
19	10/15/55	REVISED PER REVISION LIST AND INCORPORATED DCM 1	...	...	...
20	10/15/55	REVISED PER REVISION LIST AND INCORPORATED DCM 1	...	...	...
21	10/15/55	REVISED PER REVISION LIST AND INCORPORATED DCM 1	...	...	...
22	10/15/55	REVISED PER REVISION LIST AND INCORPORATED DCM 1	...	...	...
23	10/15/55	REVISED PER REVISION LIST AND INCORPORATED DCM 1	...	...	...
24	10/15/55	REVISED PER REVISION LIST AND INCORPORATED DCM 1	...	...	...
25	10/15/55	REVISED PER REVISION LIST AND INCORPORATED DCM 1	...	...	...
26	10/15/55	REVISED PER REVISION LIST AND INCORPORATED DCM 1	...	...	...
27	10/15/55	REVISED PER REVISION LIST AND INCORPORATED DCM 1	...	...	...
28	10/15/55	REVISED PER REVISION LIST AND INCORPORATED DCM 1	...	...	...
29	10/15/55	REVISED PER REVISION LIST AND INCORPORATED DCM 1	...	...	...
30	10/15/55	REVISED PER REVISION LIST AND INCORPORATED DCM 1	...	...	...
31	10/15/55	REVISED PER REVISION LIST AND INCORPORATED DCM 1	...	...	...

DECTEL
SAN FRANCISCO
PUBLIC SERVICE ELECTRIC AND GAS COMPANY
HOPE CREEK GENERATING STATION

P-10
FIRE PROTECTION-FIRE WATER
TURBINE BUILDING

JOB NO. 10855
DRAWING NO. M-22-0
SHEET 2 OF 7

PDR RIDS

8507290656

