



ELEVATION B-B
SCALE 1" = 20'-0"

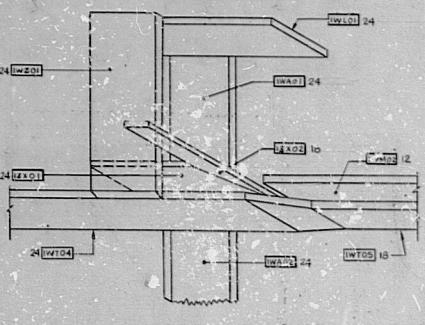

ISOMETRIC VIEW SECTION T-T
SCALE: 1" = 2'-0"

NOTE: VIEW FACING OUTSIDE FROM BELOW AND RIGHT.

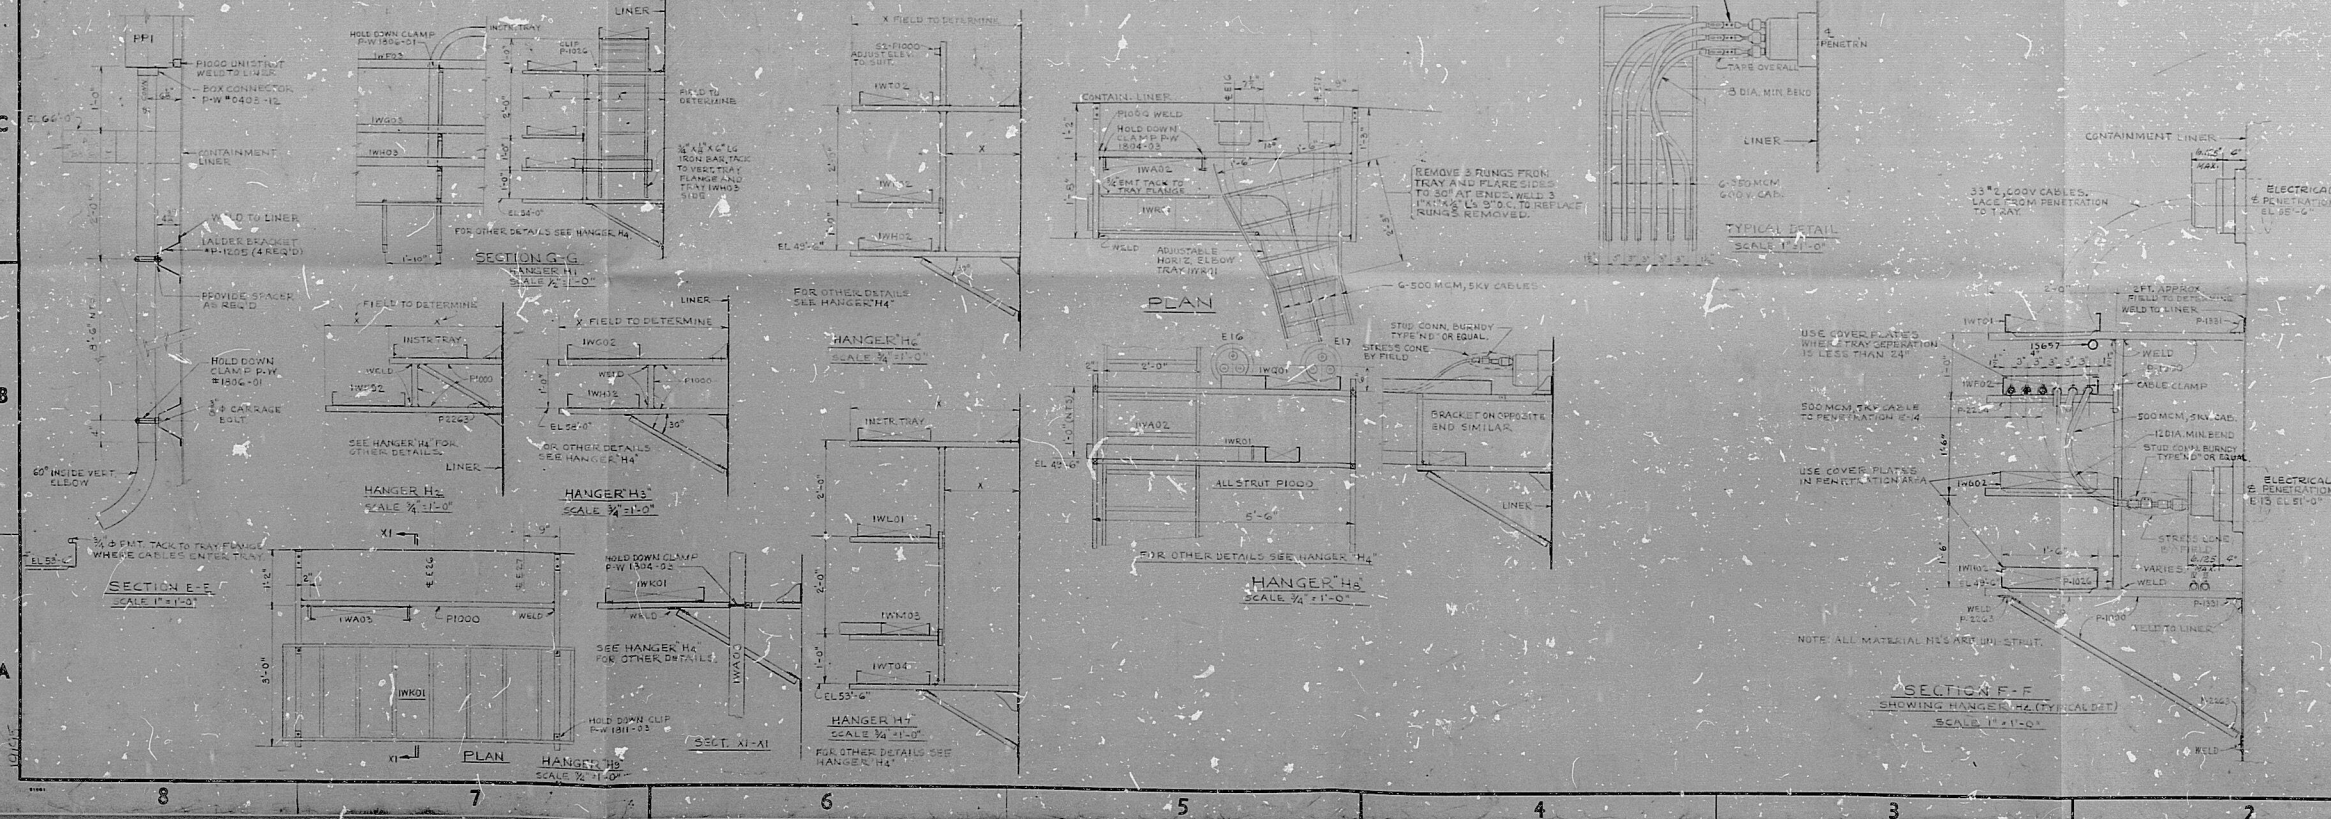

PLAN
SCALE 1/4" = 1'-0"

SECTION F-F
SHOWING HANGER H4 (TYPICAL)
SCALE 1/4" = 1'-0"

NOTES
1. FOR GENERAL NOTES AND REFERENCE DWGS SEE DWG. 6118-B-E-132.
2. JUNCTION BOXES TO BE LOCATED AS CLOSELY TO ASSOCIATED PENETRATIONS AS POSSIBLE.

REVISIONS

NO.	DATE	DESCRIPTION	BY	CHKD.	APPD.
1		ISSUED FOR CONSTRUCTION			
2		INCREASED TRAY SECTIONS TO FIT THROUGH 24" ASB TRAYS			
3		SECTION T-T, NOTE 2 INDICATED INST. TRAYS, CHANGED SIZE OF JB'S			
4		REMOVED INSTRUMENTS AND CONDIT. AS SHOWN			
5		REVISED AS SHOWN, DELETED INST. 5			
6		REVISED AS SHOWN, DELETED INSTR. 4			
7		REVISED AS SHOWN, DELETED INSTR. 3			
8		REVISED AS SHOWN, DELETED INSTR. 2			
9		REVISED AS SHOWN, DELETED INSTR. 1			
10		REVISED AS SHOWN, DELETED INSTR. 1			

BECHTEL
SAN FRANCISCO

WESTINGHOUSE ELECTRIC CORPORATION
ATOMIC POWER DIVISION

WISCONSIN MICHIGAN POWER COMPANY
POINT BEACH NUCLEAR PLANT UNIT No. 1

ELECTRICAL LAYOUT
ELEVATIONS INSIDE CONTAINMENT

6118 E-144 SH1

RIDS

8210050286

