


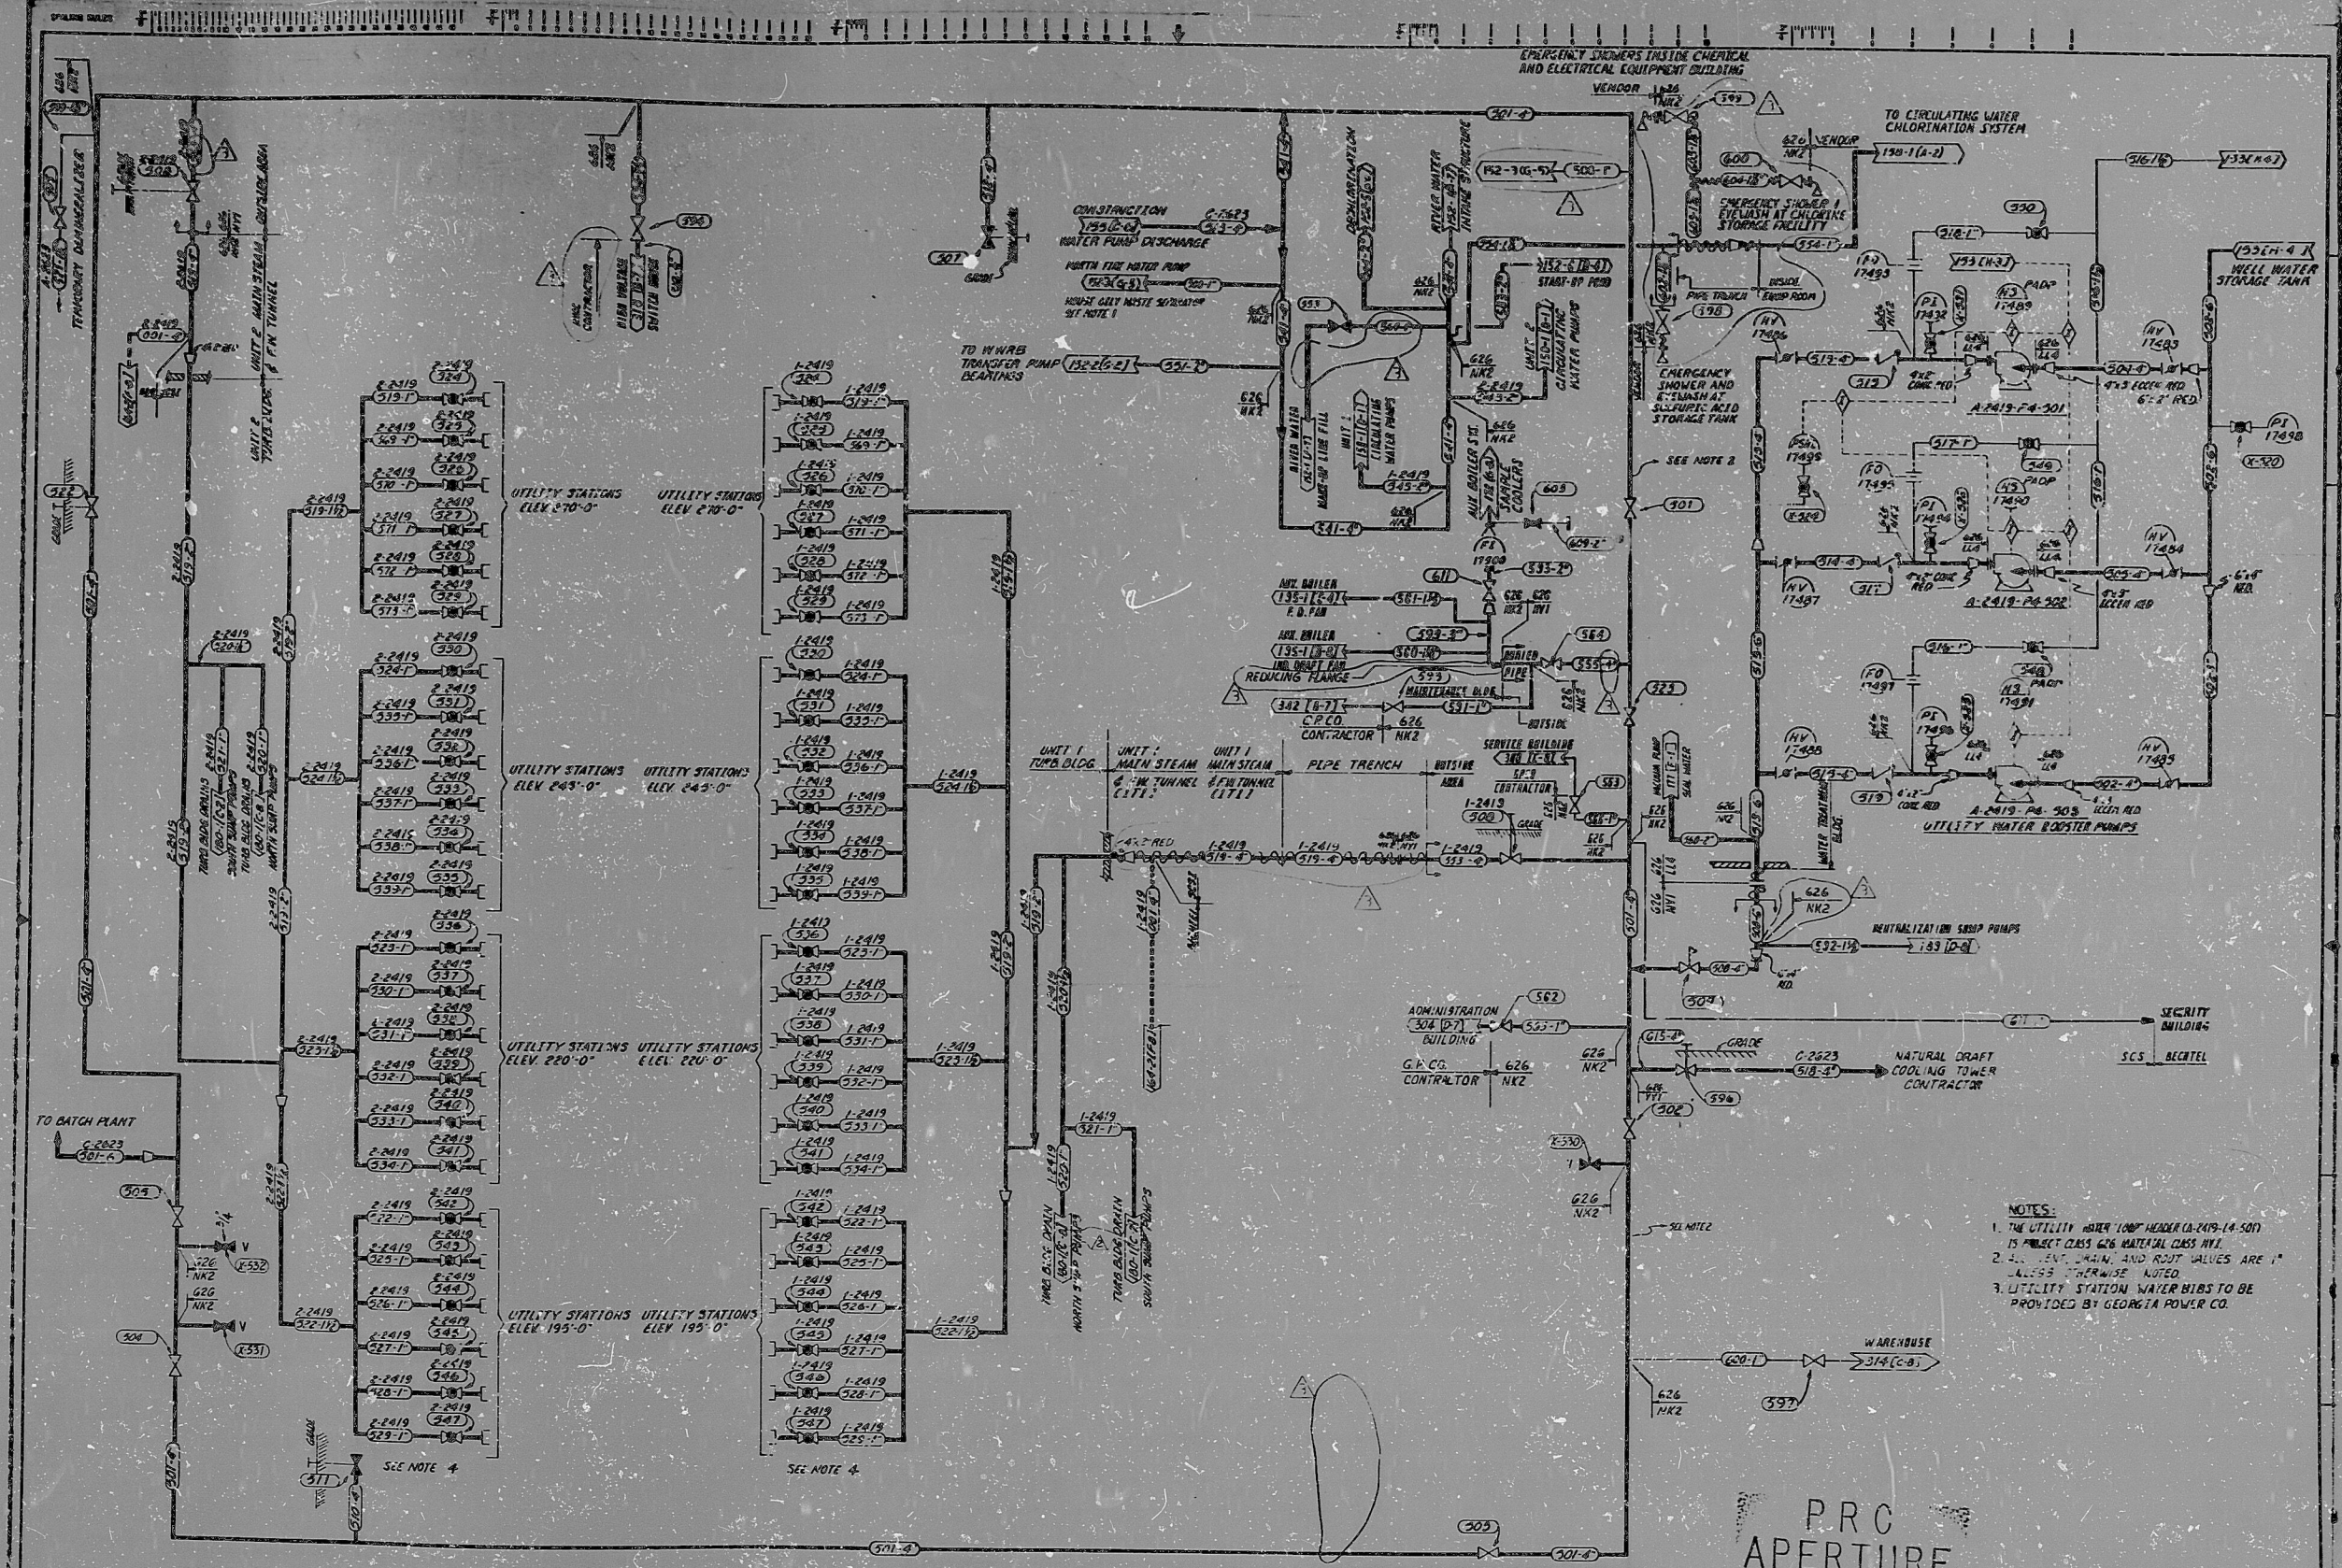

- NOTES:
1. THE UTILITY WATER LOOP HEADER (A-2419-14-501) IS SUBJECT CLASS 626 MATERIAL CLASS AVE.
 2. ALL 1/2", 3/4", 1" AND 1 1/2" VALVES ARE 1" CLASS 626, OTHERWISE NOTED.
 3. UTILITY STATION WATER HIBS TO BE PROVIDED BY GEORGIA POWER CO.

P.R.C.
APERTURE
CARD

REVISIONS										REVISIONS									
NO.	DATE	DR.	CHK.	SUPV.	EGS	CHK.	P.L.	Q.A.E.	TD.	NO.	DATE	DR.	CHK.	SUPV.	EGS	CHK.	P.L.	Q.A.E.	TD.
1										1									
2										2									
3										3									
4										4									
5										5									
6										6									
7										7									

Southern Company Services, Inc. res
BECHTEL
 LOS ANGELES
 GEORGIA POWER COMPANY
 ALVIN W. VOGTLE NUCLEAR PLANT
 P&ID DIAGRAM
 UTILITY WATER SYSTEM
 SYSTEM NO. 2419
 SCALE: 1/8" = 1'-0"
 DATE: 10/20/83
 DRAWING NO: AX40B164-1
 SHEET NO: 3

RIDS

8309260286

