




DECATUR GEORGIA POWER COMPANY ALVIN W. VOSTLE NUCLEAR PLANT ADMINISTRATION BUILDING CHILLED WATER SYSTEM P&ID SYSTEM 120	
SHEET NO. 1 OF 1	DRAWING NO. AXNDJ004

NO.	DATE	BY	CHKD.	APP'D.	REVISION
1	10/1/73	J. B. [unclear]	[unclear]	[unclear]	ISSUED FOR CONSTRUCTION

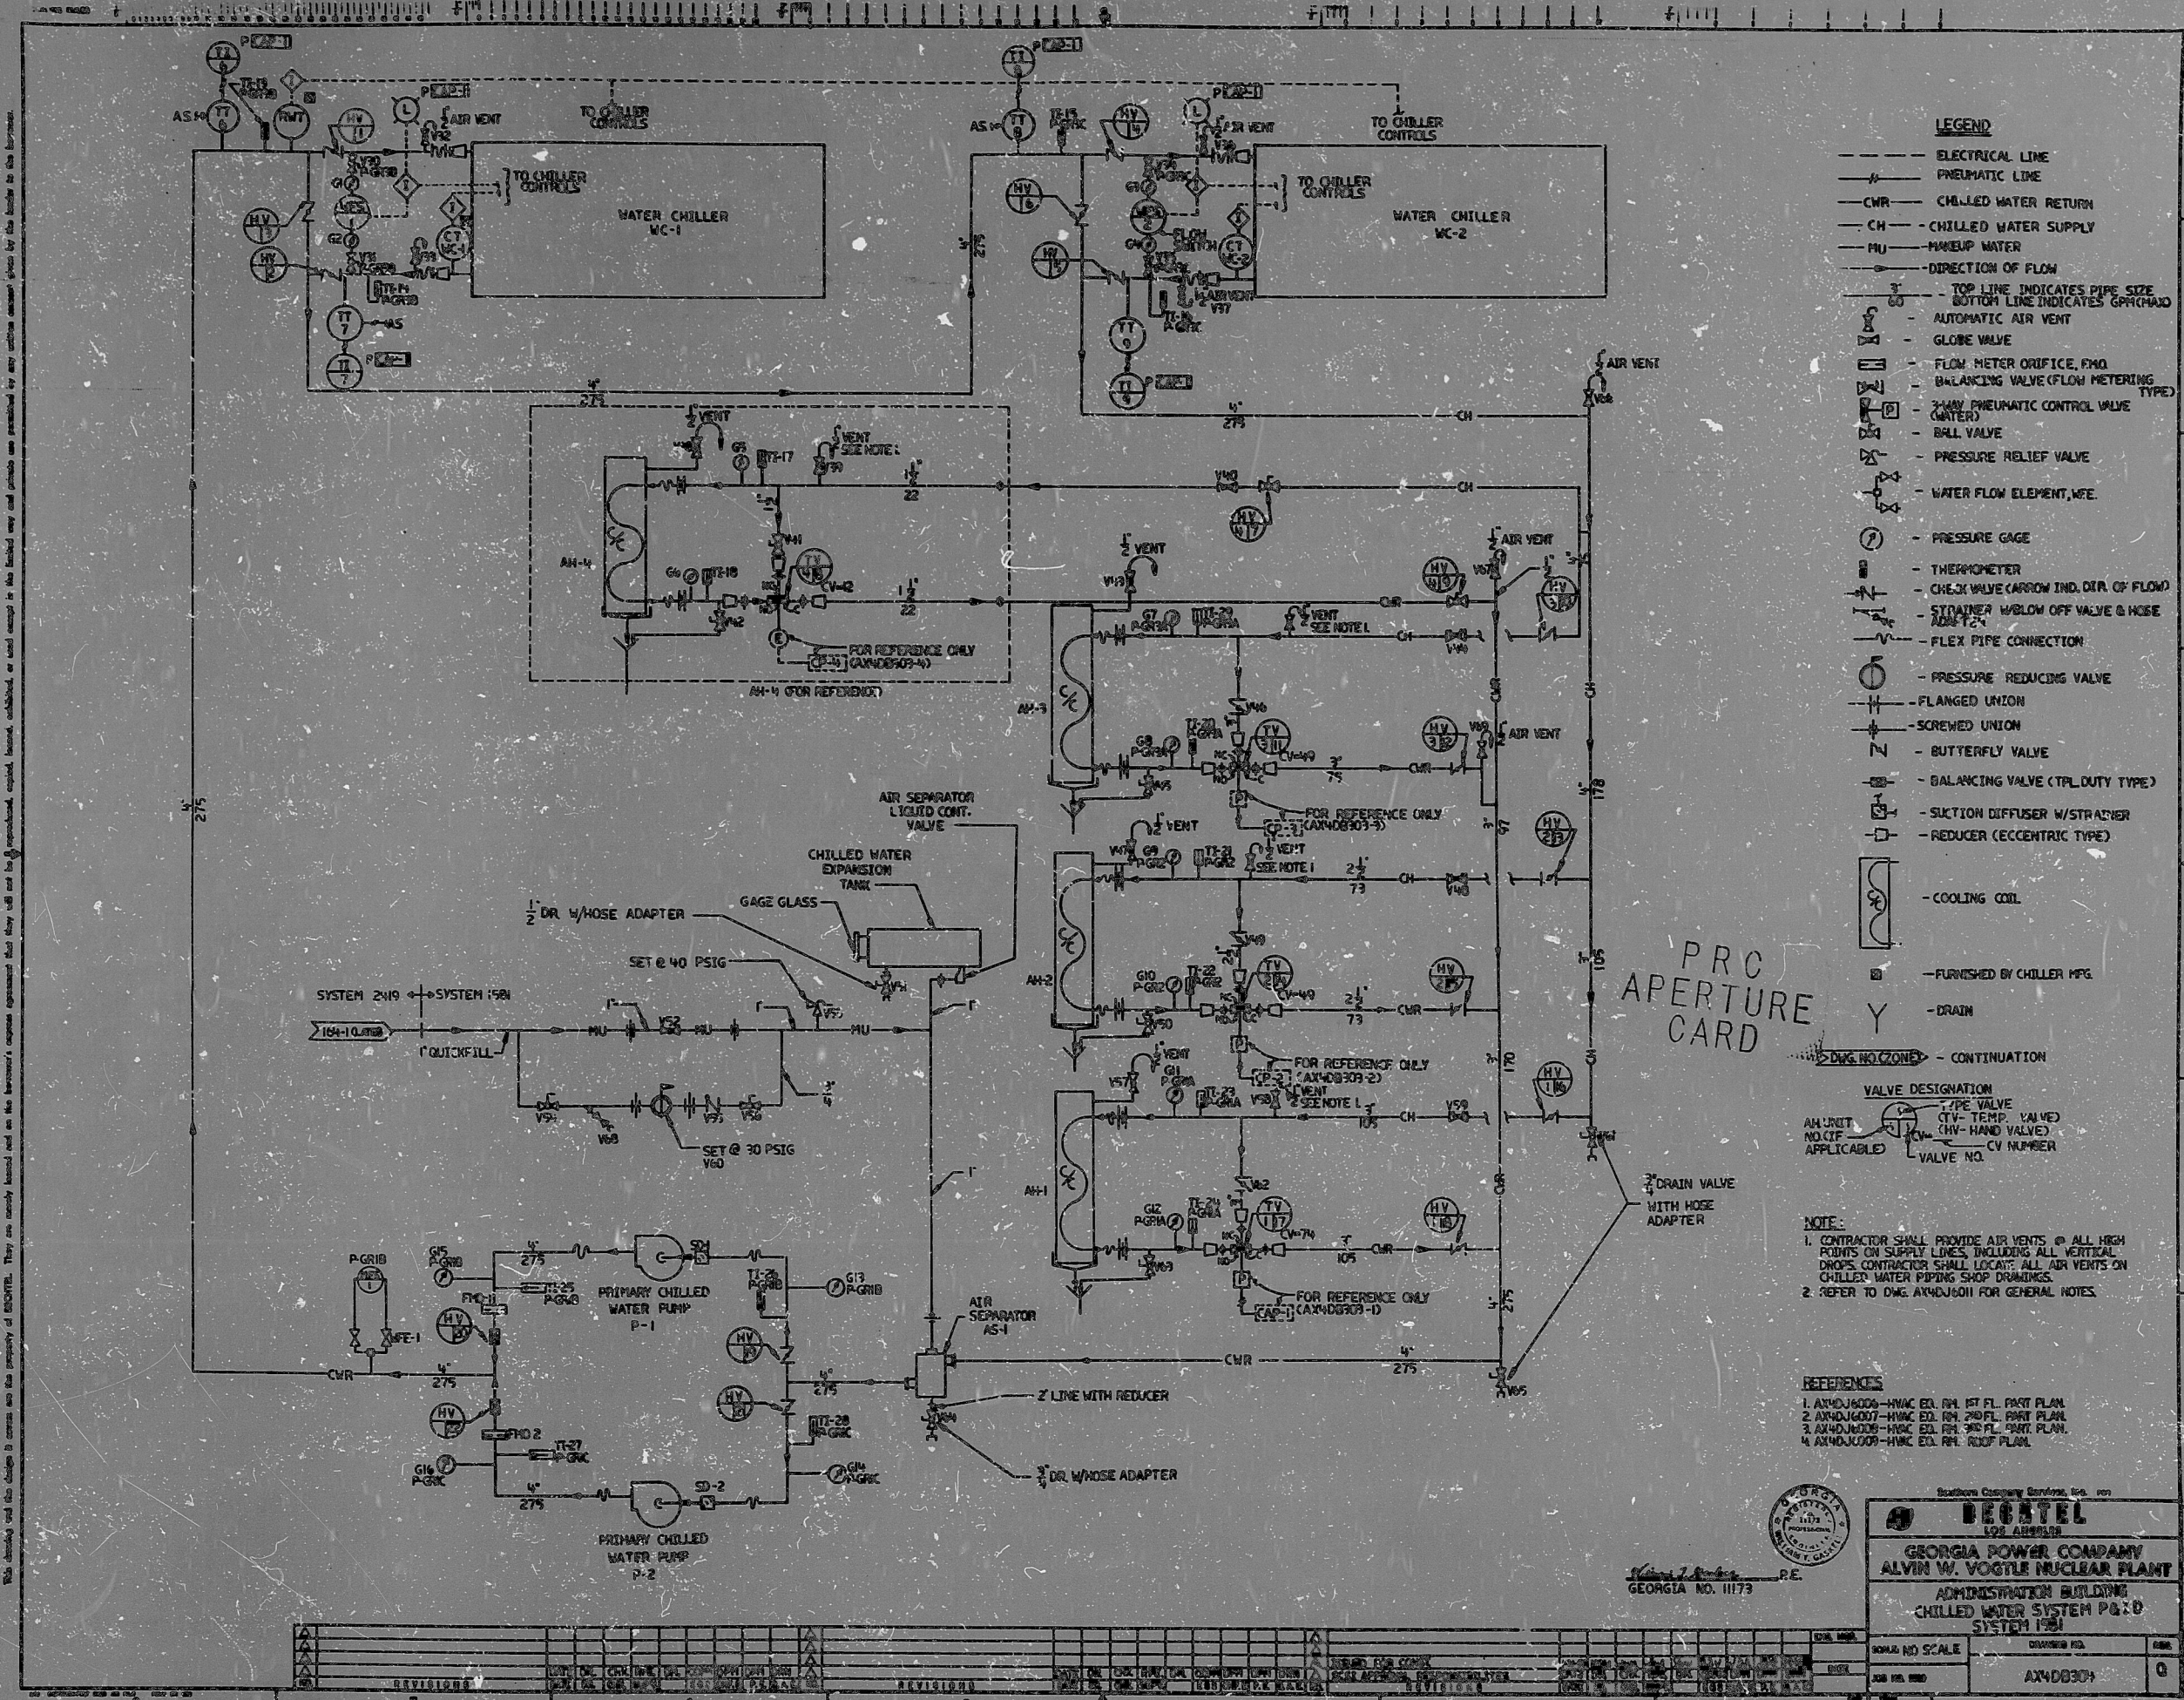