

NOTES:
FOR SUPPORT INFORMATION SEE REFERENCE P&ID DWGS

REFERENCE DWGS:

- PHDS
- 11825-FH-198-19
- SUPPORT LOCATION DWGS
- NAK-FP-11A, NAK-FP-11B
- YELLOW ISOMETRICS
- 1172-SYS-19, SHT. 1 OF 6
- COOL SHEETS
- F-10, F-14, F-85, F-254, F-74, F-77, F-79,
- F-84, F-154, F-85, F-82
- MSK-127A, MSK-127B


No.	Date	Revisions	By	Checked	Rev.
1	8/21/65	COMPLETION OF 1965	WJG	WJG	1
2	8/21/65	REVISIONS TO 1965	WJG	WJG	2
3	1/16/66	REVISIONS TO 1965	WJG	WJG	3
4	1/16/66	REVISIONS TO 1965	WJG	WJG	4
5	1/16/66	REVISIONS TO 1965	WJG	WJG	5

GENERAL PHYSICS CORPORATION
COLUMBIA, MARYLAND

POWER AUTHORITY OF THE STATE OF NEW YORK
JAMES A. FITZPATRICK
NUCLEAR POWER PLANT
PIPING ISOMETRIC

SYSTEM No.	Contract No.	Drawing No.	Rev.
IS-SYS-29	NYO-74-	41E0009	SH 2 OF 3

THIS DRAWING CONTAINS LINES
24" SHP-902-1D, 24" SHP-101-1D
24" SHP-902-1C, 24" SHP-101-C
6" SHP-902-50, 6" SHP-902-5R
6" SHP-902-55, 6" SHP-902-5T
6" SHP-902-53, 6" SHP-902-5

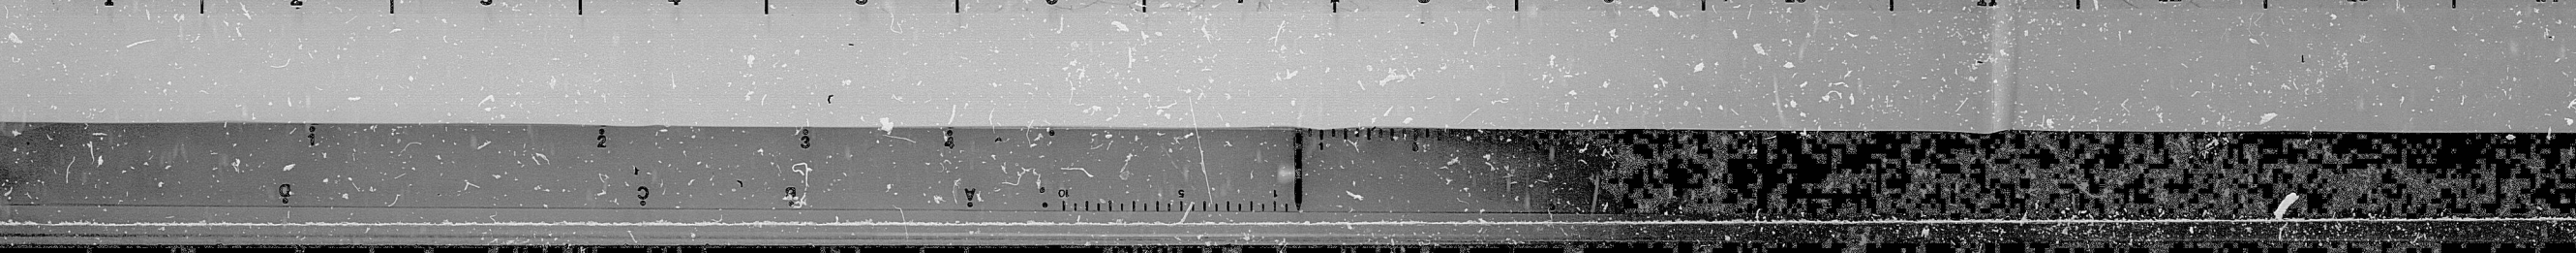

PDR

8510290573

