


38
 22
 17
 11
 58
 8.5"
 11"
 17"
 22"
 8.5"
 11"
 17"
 22"
 8.5"
 11"
 17"
 22"

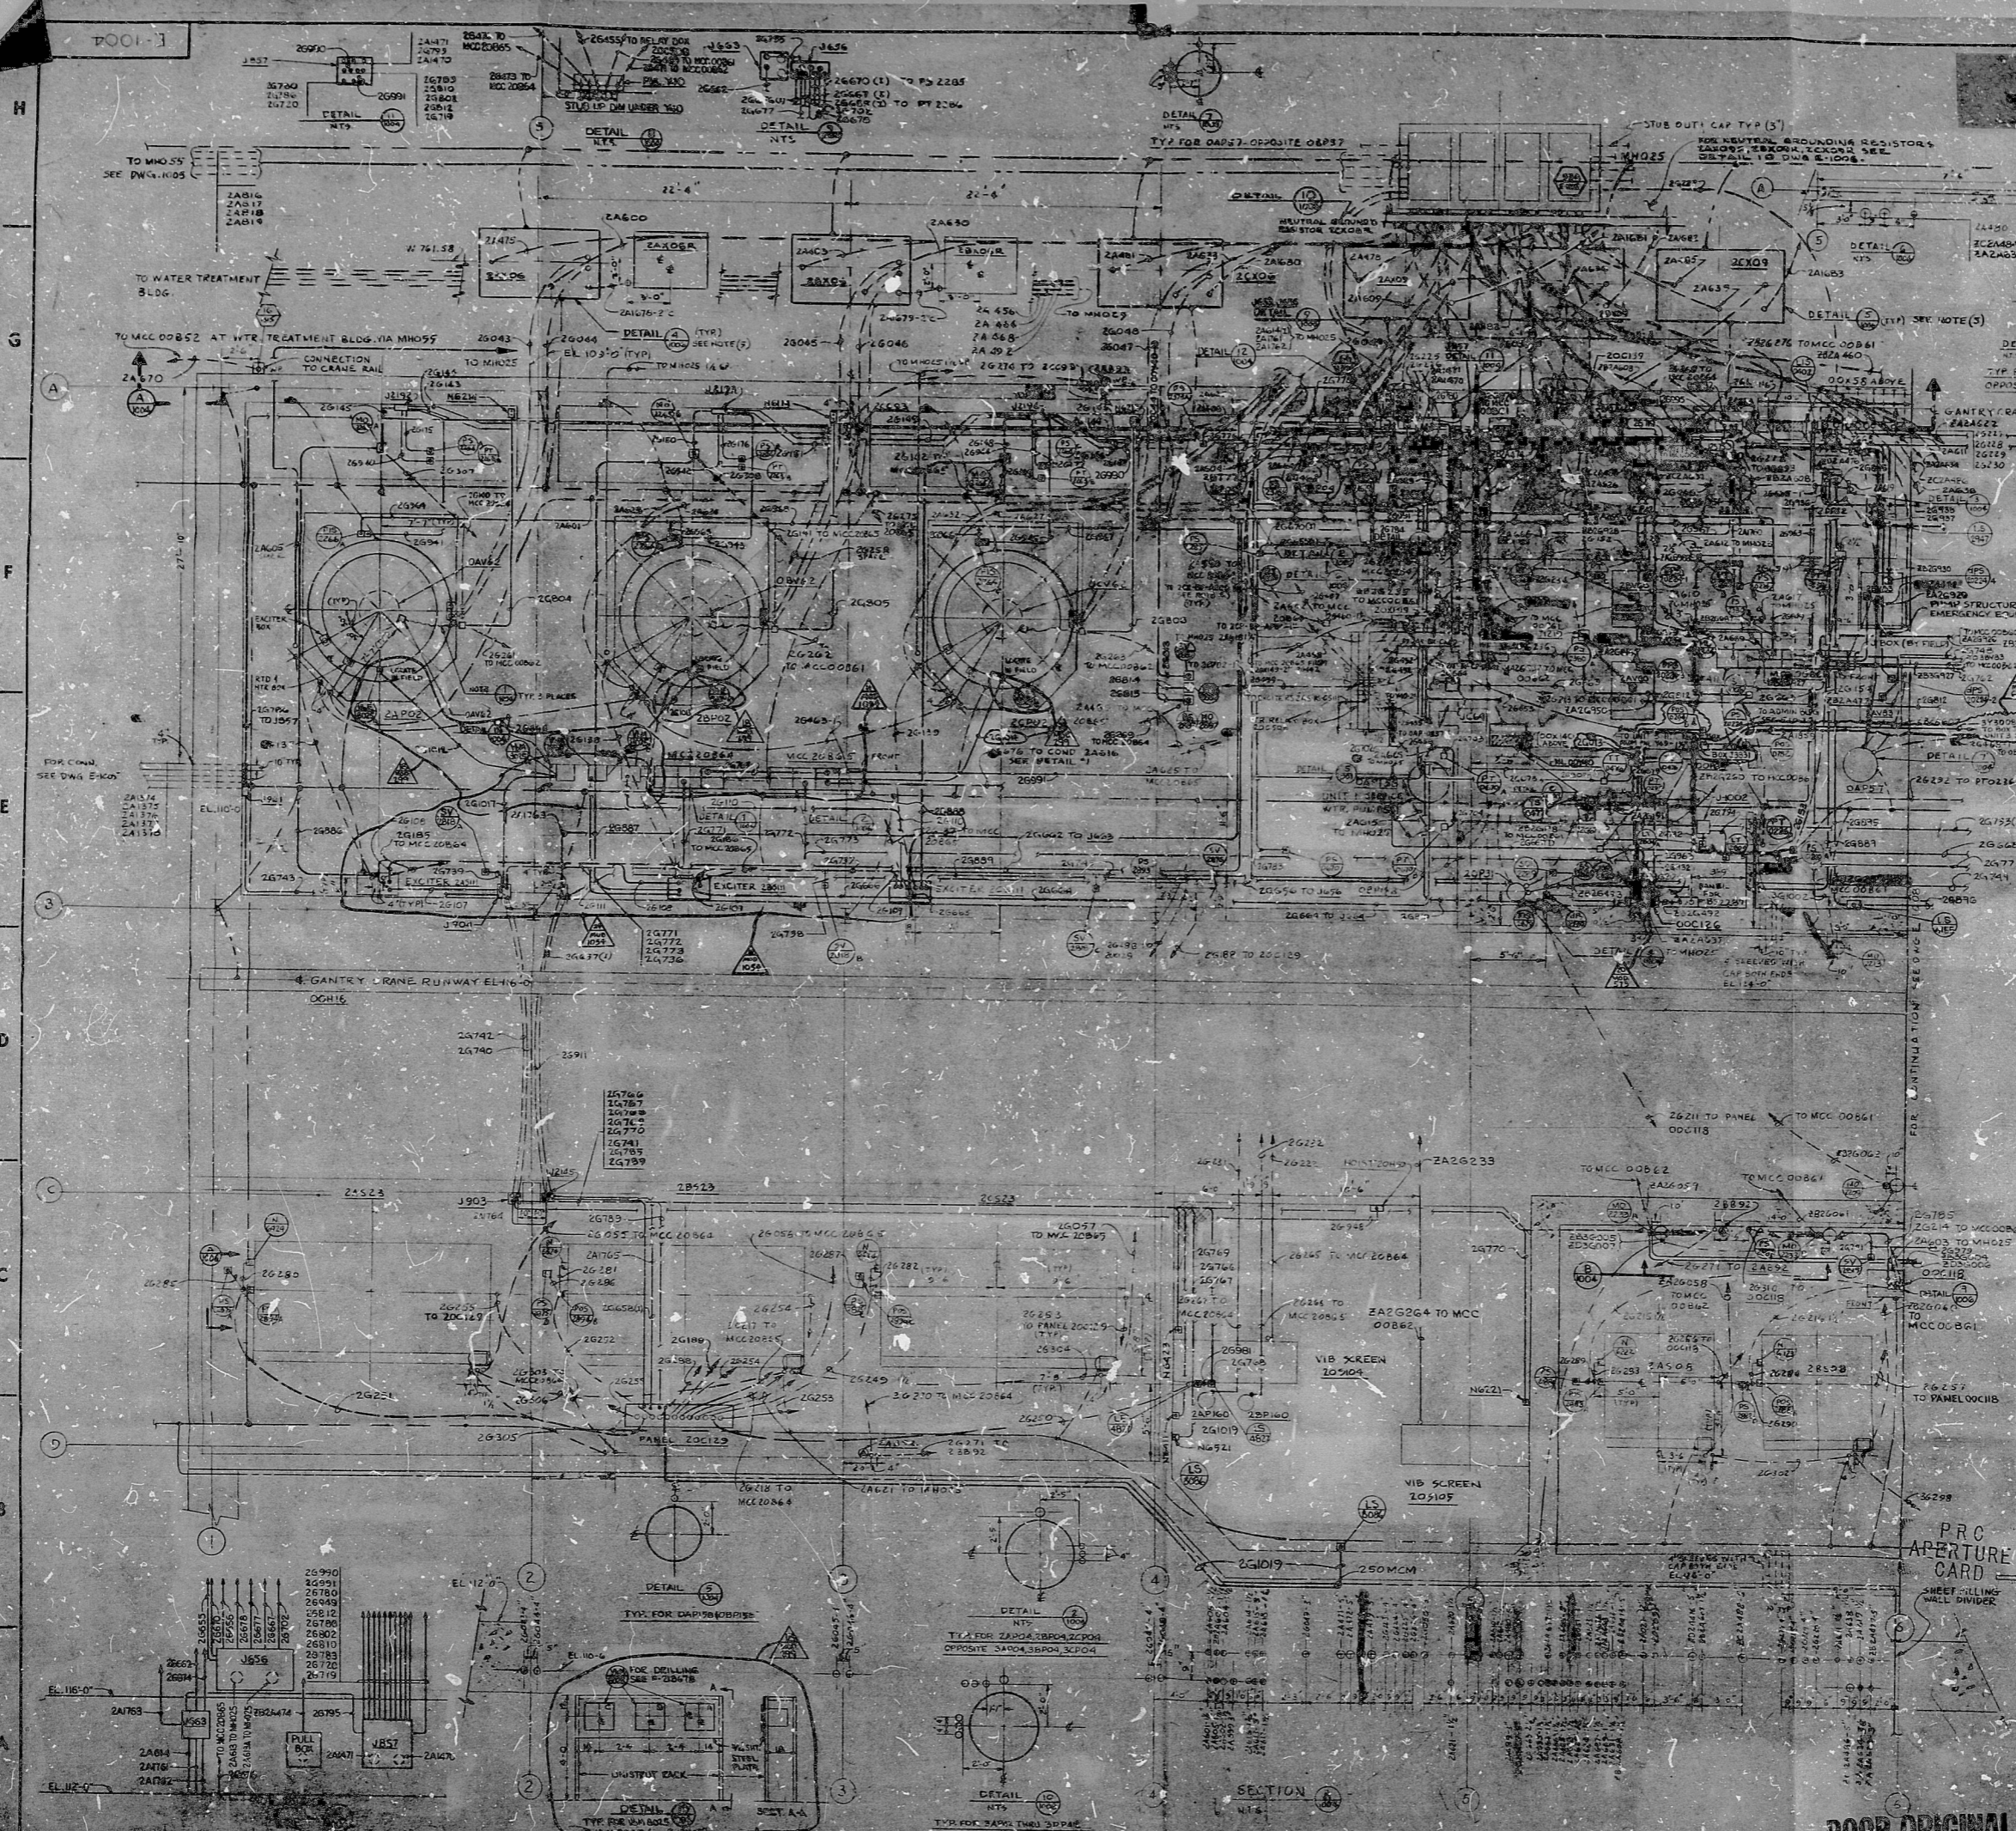

- NOTES:**
1. VENT FANS MOUNTED ON TOP OF HATCH COVER EL. 130'-6" SHALL BE 450V OUTLET WITH FLEX CORD FROM PAN TO 450V OUTLET. TYP. FOR 450V. DWG. 20012.
 2. FOR 250V LOADS. SEE DWG. F-1305.
 3. ALL EMBEDDED CONDUIT ENTERING PUMP STRUCTURE THROUGH EMERGENCY EQUIPMENT RM. SHALL BE SEALED WATER TIGHT.
 4. STUB-UP DETAILS AT TRANSFORMERS LATER.
 5. FOR DETAILS OF TRANSFORMERS & GROUND RESISTORS SEE DWG. E-1006 PART 4, 5 & 10.

| NO. | REVISION | DESCRIPTION | DATE | BY | CHKD. |
|-----|----------|-------------------------|------|----|-------|
| 1 | | ISSUED FOR CONSTRUCTION | | | |
| 2 | | ISSUED FOR CONSTRUCTION | | | |
| 3 | | ISSUED FOR CONSTRUCTION | | | |
| 4 | | ISSUED FOR CONSTRUCTION | | | |
| 5 | | ISSUED FOR CONSTRUCTION | | | |
| 6 | | ISSUED FOR CONSTRUCTION | | | |
| 7 | | ISSUED FOR CONSTRUCTION | | | |
| 8 | | ISSUED FOR CONSTRUCTION | | | |
| 9 | | ISSUED FOR CONSTRUCTION | | | |
| 10 | | ISSUED FOR CONSTRUCTION | | | |
| 11 | | ISSUED FOR CONSTRUCTION | | | |
| 12 | | ISSUED FOR CONSTRUCTION | | | |
| 13 | | ISSUED FOR CONSTRUCTION | | | |
| 14 | | ISSUED FOR CONSTRUCTION | | | |
| 15 | | ISSUED FOR CONSTRUCTION | | | |
| 16 | | ISSUED FOR CONSTRUCTION | | | |
| 17 | | ISSUED FOR CONSTRUCTION | | | |
| 18 | | ISSUED FOR CONSTRUCTION | | | |
| 19 | | ISSUED FOR CONSTRUCTION | | | |
| 20 | | ISSUED FOR CONSTRUCTION | | | |
| 21 | | ISSUED FOR CONSTRUCTION | | | |
| 22 | | ISSUED FOR CONSTRUCTION | | | |
| 23 | | ISSUED FOR CONSTRUCTION | | | |
| 24 | | ISSUED FOR CONSTRUCTION | | | |

SECRET
 REACH BOTTOM ATOMIC POWER STATION UNITS No. 2 & 3
 ELECTRICAL INDEX E-22004
RACEWAY & GROUNDING LAYOUT
PUMP STRUCTURE UNIT 2
 SHEET NO. 6200 E-1004 24
 8102-10365

POOR ORIGINAL

RWS

8210270365

