


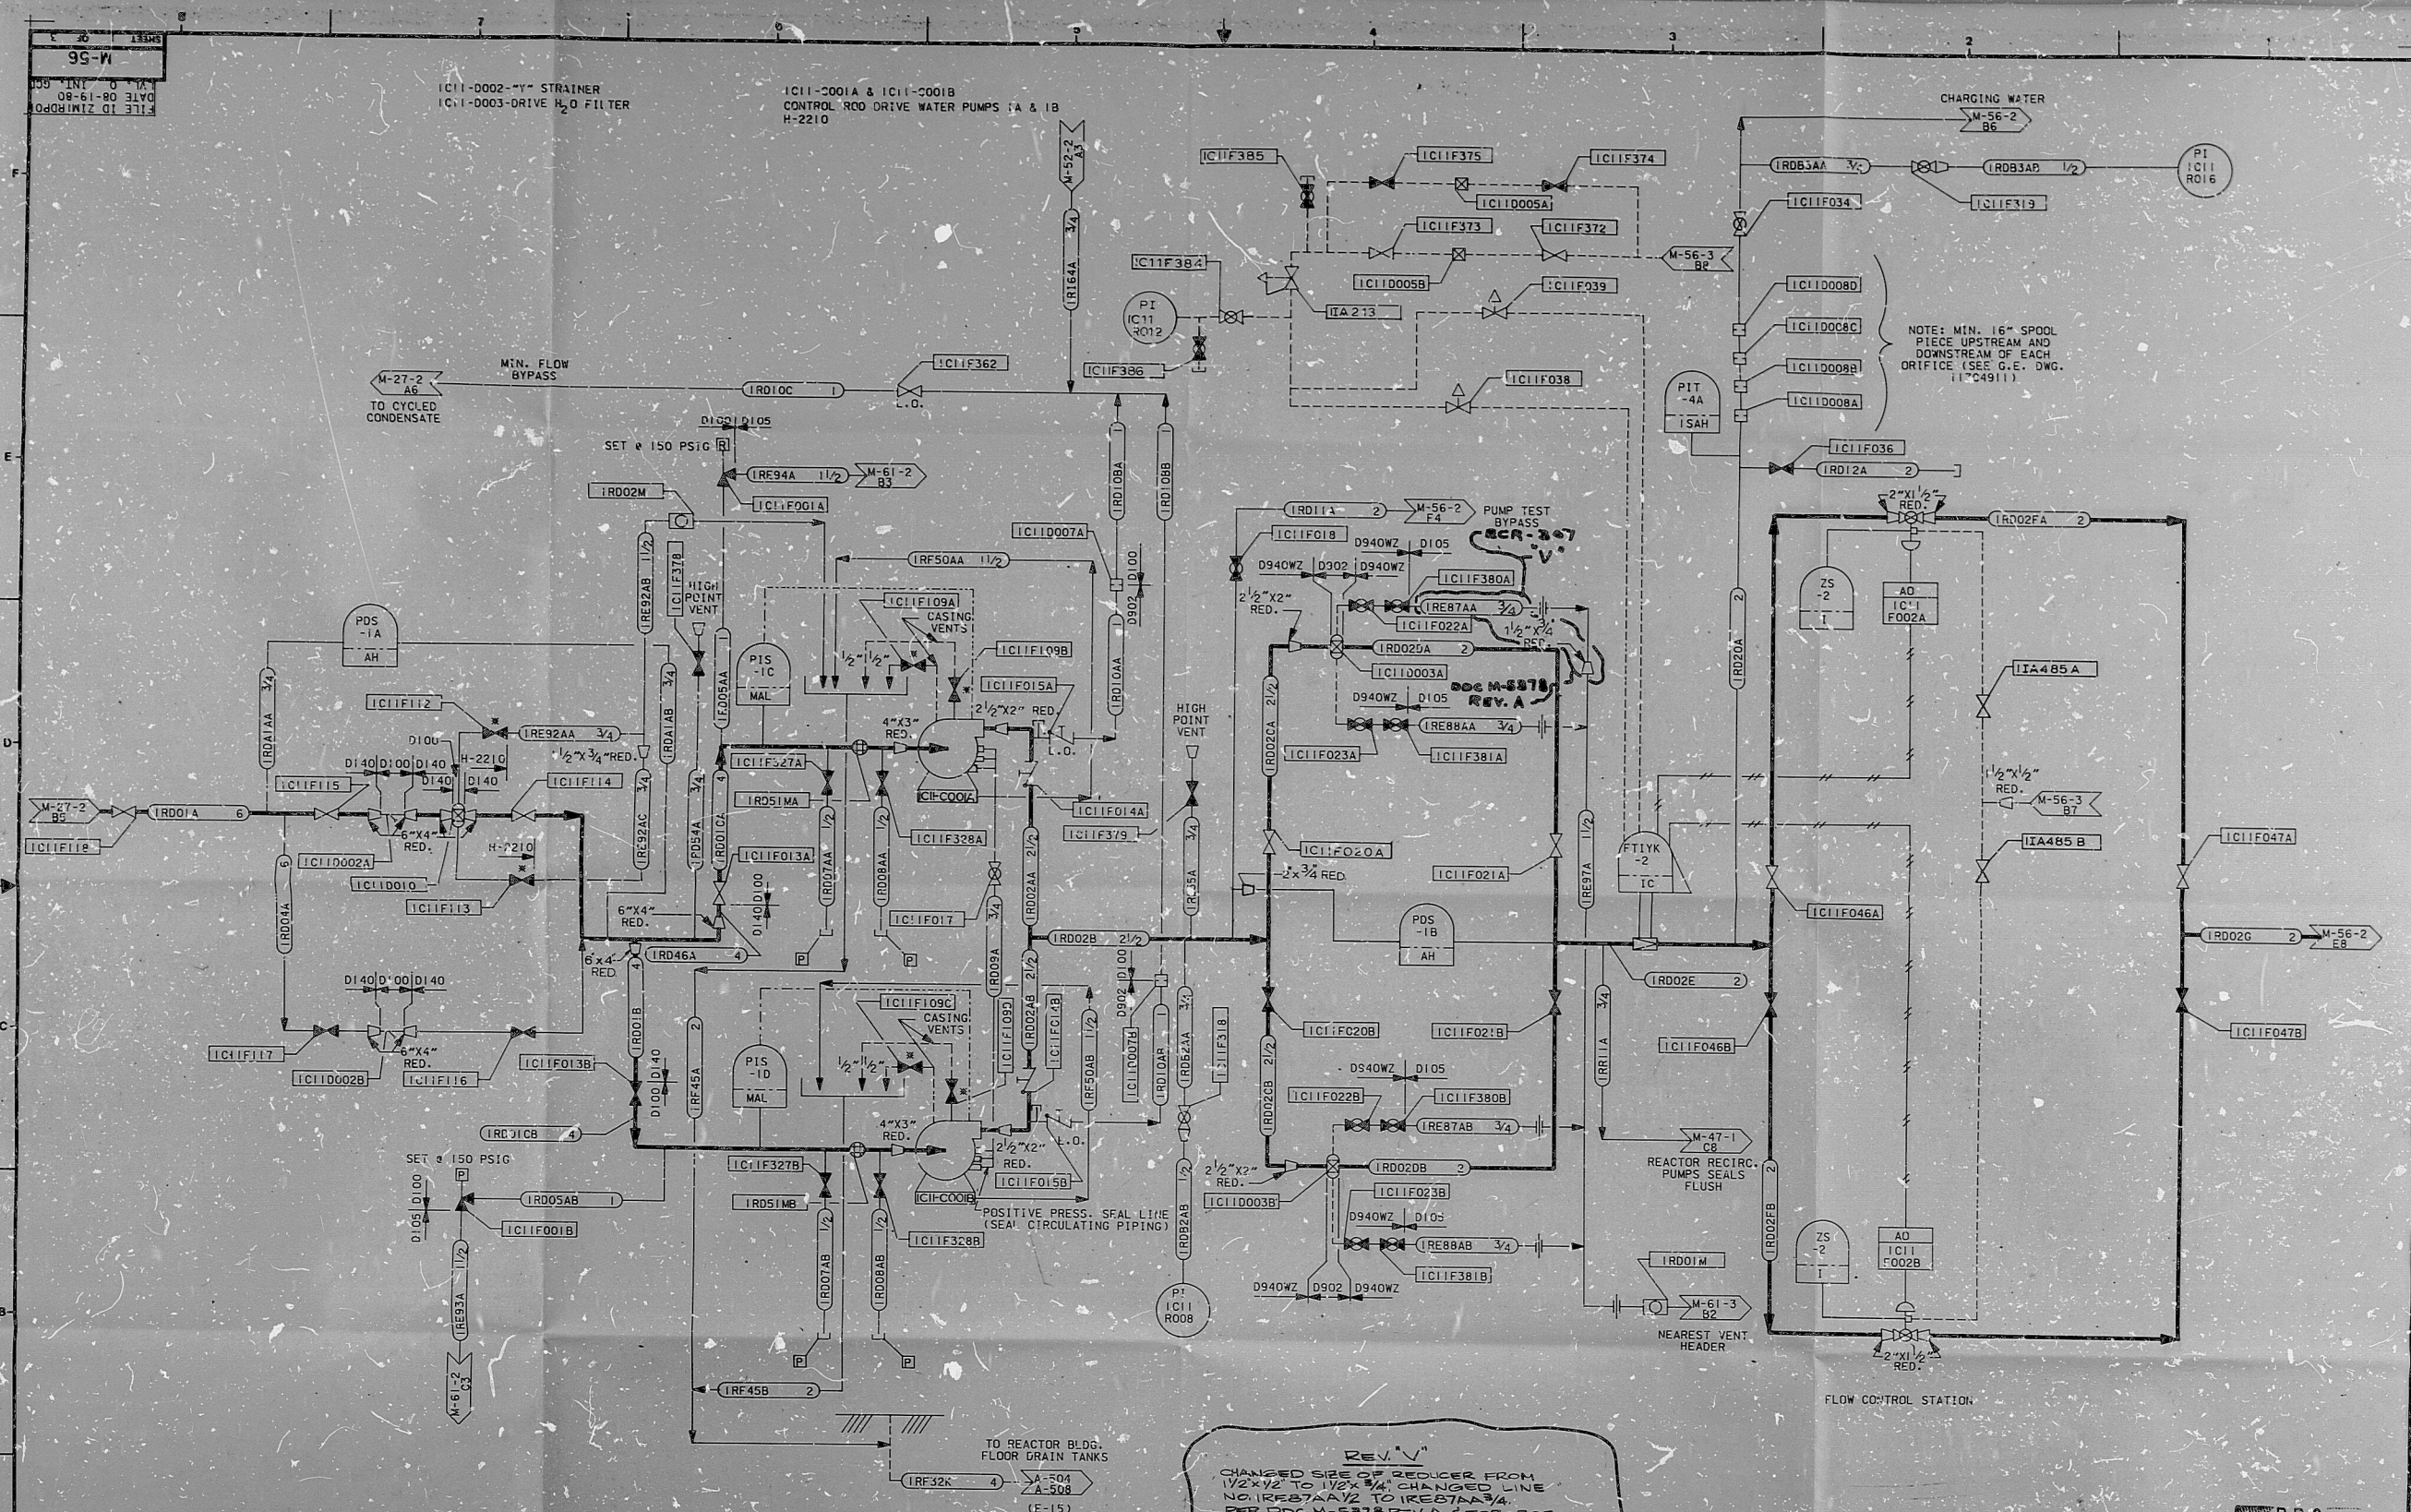

REV. V
CHANGED SIZE OF REDUCER FROM 1/2"x1/2" TO 1/4"x1/4" CHANGED LINE NO. IRE87AA1/2 TO IRE87AA3/4 PER DOC M-5373 REV. A & ECR-307 FOR FILE RECORD RELEASE PER MT-2000

ESSENTIAL COMPONENTS INCLUDED

NOTE:
THE P & ID/C & I DETAILS FOR THE C & I FUNCTION SYMBOLS ARE SHOWN ON DRAWING M-756 UNLESS OTHERWISE NOTED. SHEET NUMBER & DETAIL REFERENCE ARE SHOWN IN THE FUNCTION SYMBOL.

PRC
APERTURE
CARD

REV.	DATE	FIELD	PREPARED	REVIEWED	APPROVED	PURPOSE	FILM	REV.	DATE	FIELD	PREPARED	REVIEWED	APPROVED	PURPOSE	FILM
1	10-2-60		A. H. Jensen			REDRAWN FOR FILE RECORD RELEASE PER MT-5236									
2	10-2-60		A. H. Jensen			SEE NOTE FOR REVISION									
3	10-2-60		A. H. Jensen			SEE NOTE FOR REVISION									
4	10-2-60		A. H. Jensen			SEE NOTE FOR REVISION									
5	10-2-60		A. H. Jensen			SEE NOTE FOR REVISION									
6	10-2-60		A. H. Jensen			SEE NOTE FOR REVISION									
7	10-2-60		A. H. Jensen			SEE NOTE FOR REVISION									
8	10-2-60		A. H. Jensen			SEE NOTE FOR REVISION									
9	10-2-60		A. H. Jensen			SEE NOTE FOR REVISION									
10	10-2-60		A. H. Jensen			SEE NOTE FOR REVISION									

P & ID
CONTROL ROD DRIVE
HYDRAULIC (RD)
M. H. ZIMMER NUCLEAR POWER STATION UNIT 1
THE CINCINNATI GAS & ELECTRIC CO.
COLUMBUS & SOUTHWEST OHIO ELECTRIC CO.
THE DAYTON POWER & LIGHT CO.

DRAWING NO. M-56
SHEET 1 OF 3

SARGENT & LUNDY
ENGINEERS
CHICAGO

Rids

821208 0097

