

34

34

22

22

17

17

11

11

8.5

8.5

8.5

8.5

11

11


17

17

22

22

34

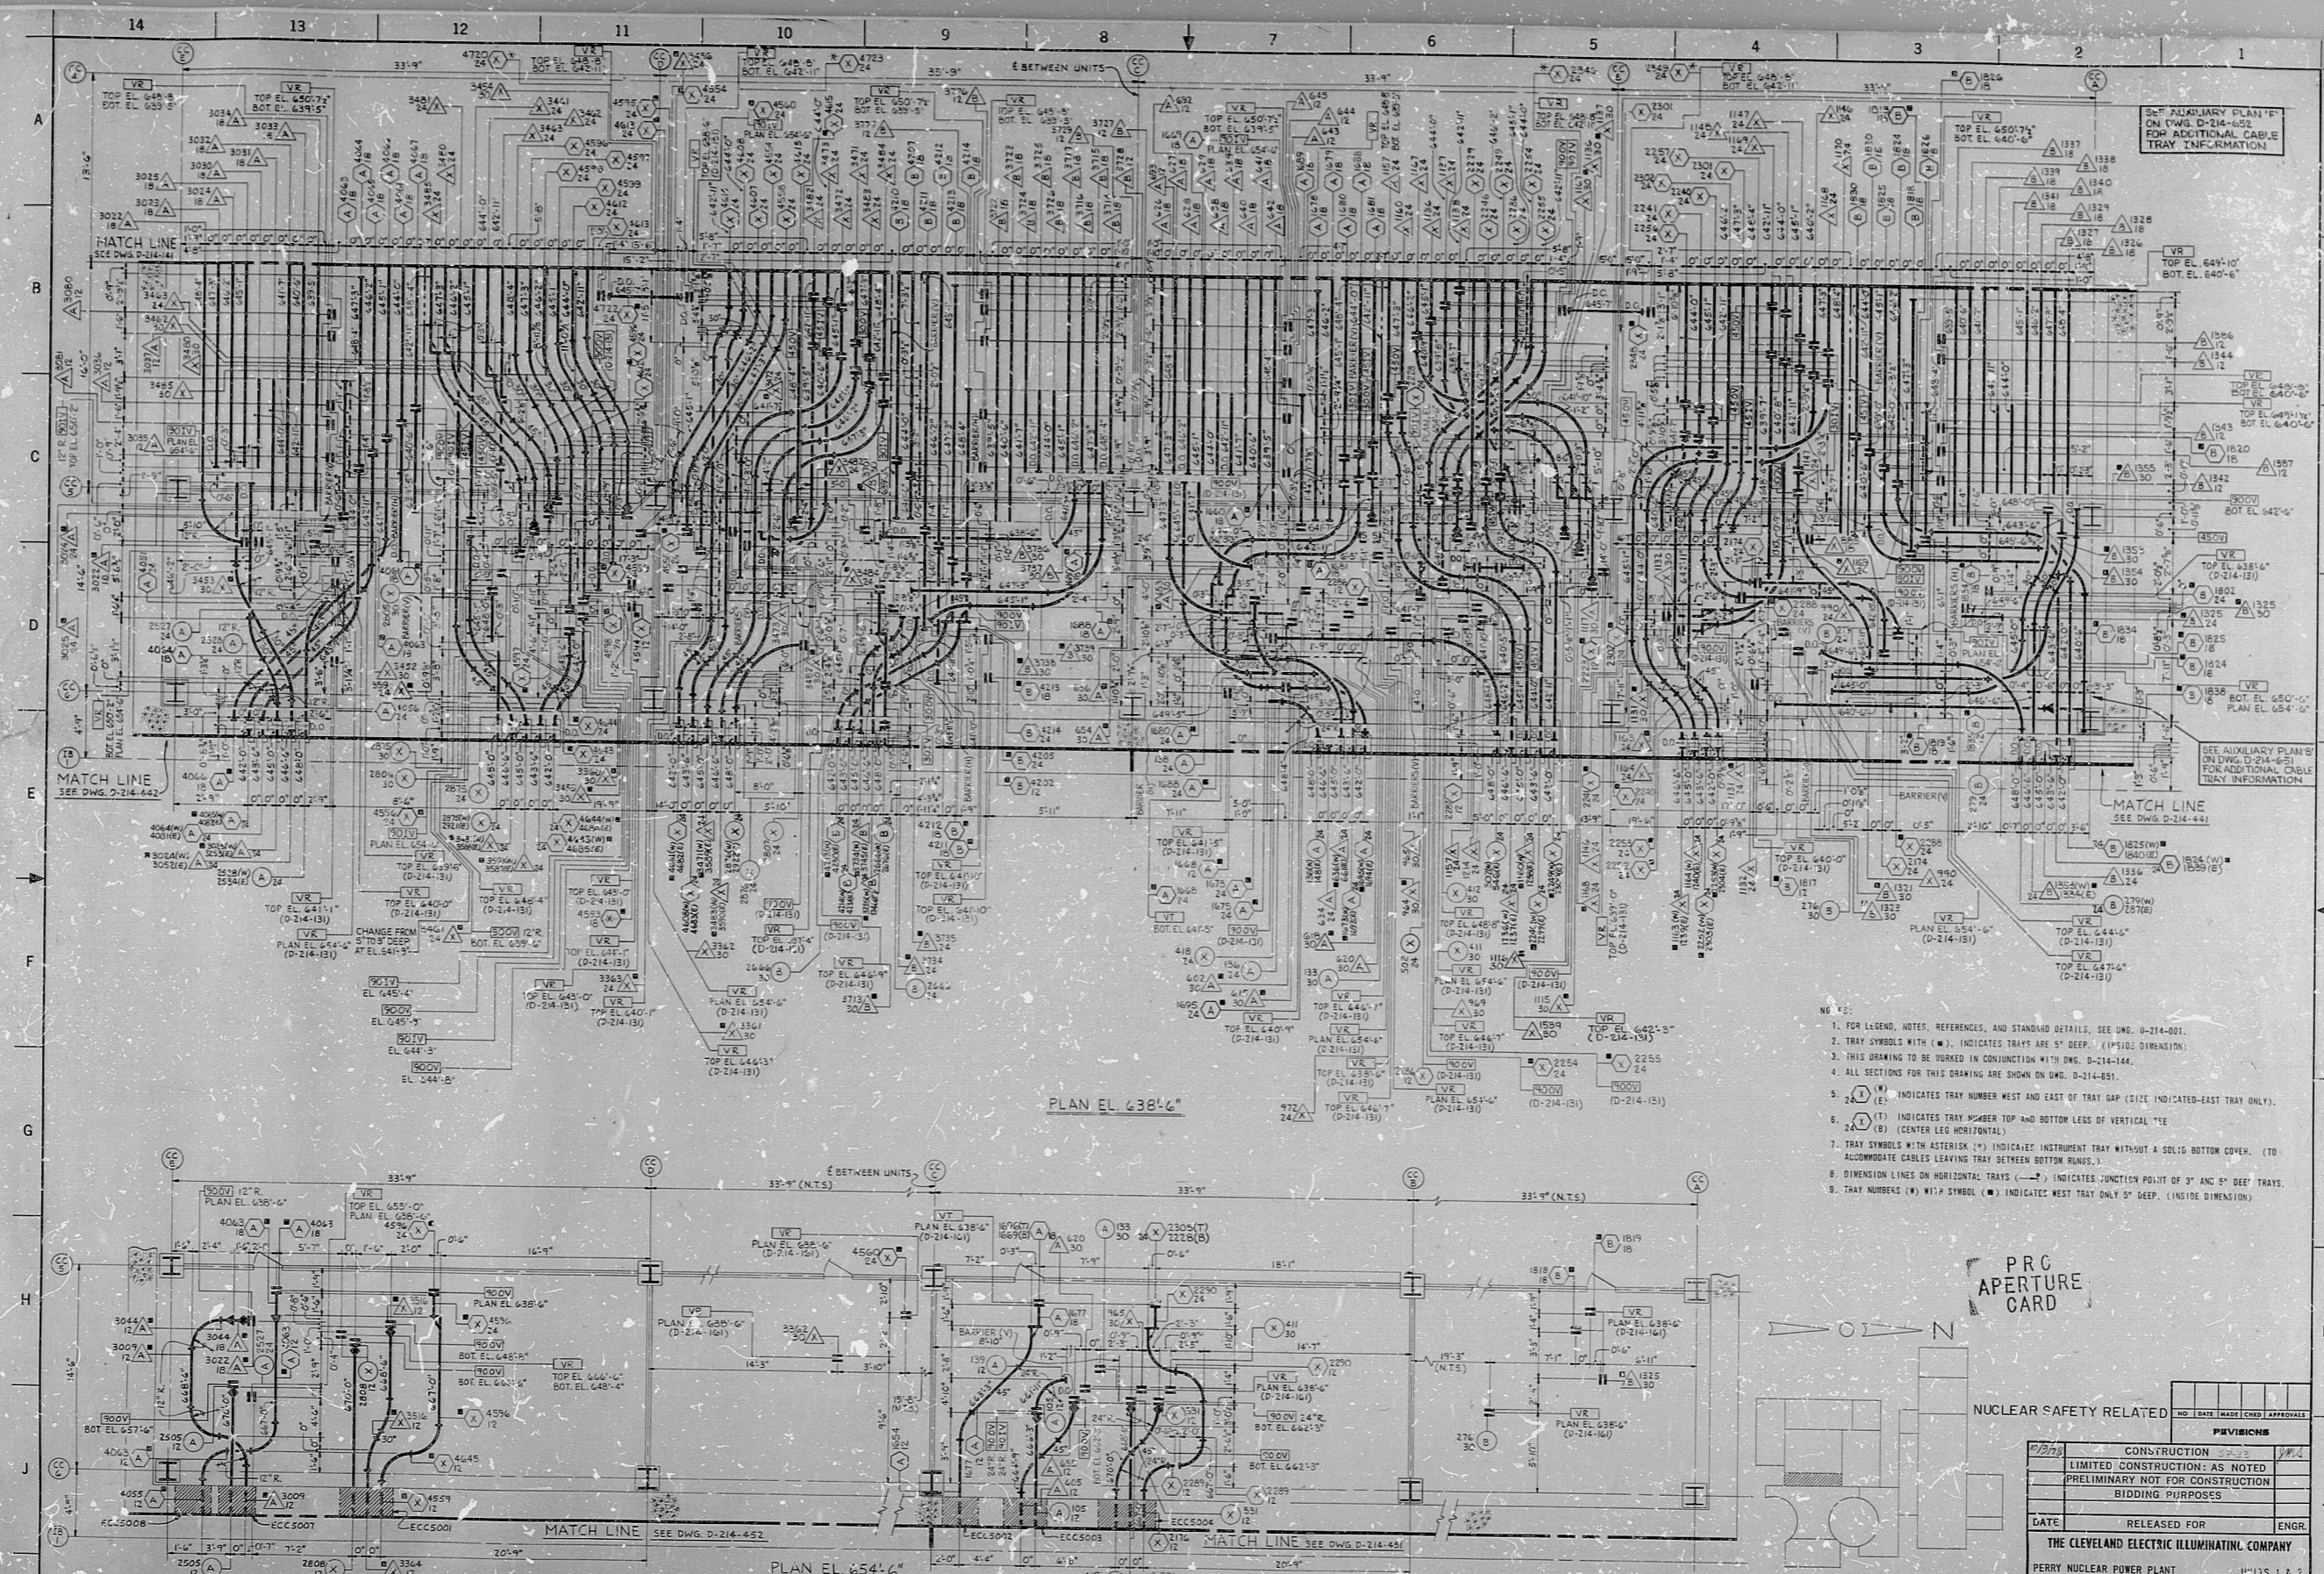

- NOTES:
- FOR LEGEND, NOTES, REFERENCES, AND STANDARD DETAILS, SEE DWG. 0-214-001.
 - TRAY SYMBOLS WITH (M), INDICATES TRAYS ARE 5" DEEP. (INSIDE DIMENSION).
 - THIS DRAWING TO BE WORKED IN CONJUNCTION WITH DWG. D-214-444.
 - ALL SECTIONS FOR THIS DRAWING ARE SHOWN ON DWG. D-214-651.
 - (M) INDICATES TRAY NUMBER WEST AND EAST OF TRAY GAP (SIZE INDICATED-EAST TRAY ONLY).
 - (1) INDICATES TRAY NUMBER TOP AND BOTTOM LEGS OF VERTICAL "E".
 - (B) (CENTER LEG HORIZONTAL).
 - TRAY SYMBOLS WITH ASTERISK (*) INDICATE INSTRUMENT TRAY WITHOUT A SOLID BOTTOM COVER. (TO ACCOMMODATE CABLES LEAVING TRAY BETWEEN BOTTOM RUNS).
 - DIMENSION LINES ON HORIZONTAL TRAYS (—) INDICATE JUNCTION POINT OF 3" AND 6" DEEP TRAYS.
 - TRAY NUMBERS (M) WITH SYMBOL (M) INDICATES WEST TRAY ONLY 5" DEEP. (INSIDE DIMENSION).

PRC
APERTURE
CARD

NUCLEAR SAFETY RELATED

NO.	DATE	BY	CHKD.	APPROVALS
1				
2				
3				
4				
5				
6				
7				
8				
9				
10				
11				
12				
13				
14				
15				
16				
17				
18				
19				
20				

CONSTRUCTION: AS NOTED
LIMITED CONSTRUCTION: AS NOTED
PRELIMINARY NOT FOR CONSTRUCTION
BIDDING PURPOSES

DATE: RELEASED FOR ENGR.

THE CLEVELAND ELECTRIC ILLUMINATING COMPANY

PERRY NUCLEAR POWER PLANT U-17S 1 & 2

ELECTRICAL
CABLE TRAY LAYOUT
CENTRAL COMPLEX - CABLE CHASE - EL. 638.6'-0" AND EL. 641.0'-0"

DESIGNED BY: GILBERT ASSOCIATES, INC.
ENGINEER AND CONSULTANTS

SCALE: 1/4" = 1'-0"

NO. 04 4549 D-214-143 K
DRAWING NUMBER

NO.	DATE	BY	CHKD.	APPROVALS
1				
2				
3				
4				
5				
6				
7				
8				
9				
10				
11				
12				
13				
14				
15				
16				
17				
18				
19				
20				

82,208 0230

RIDS

