
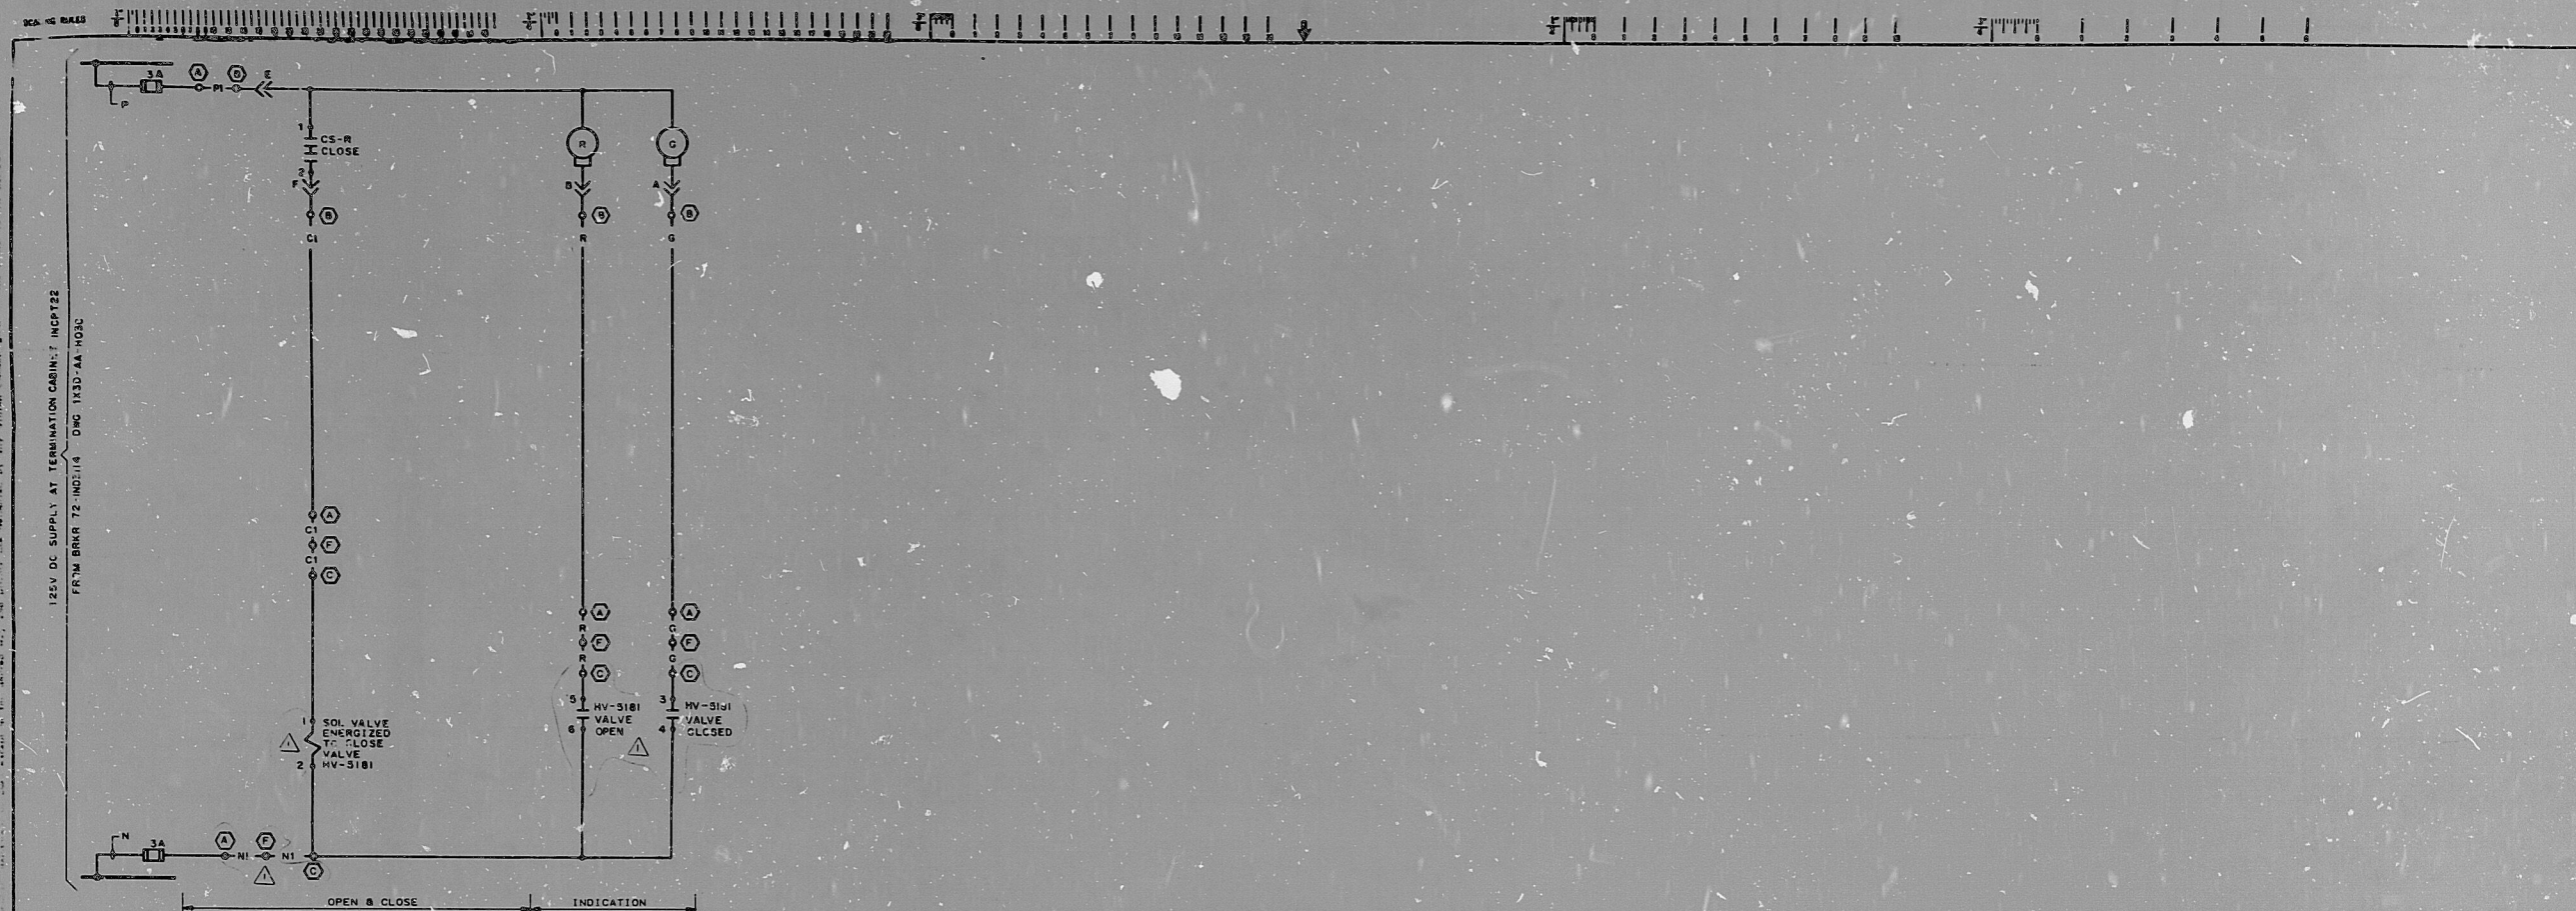


| DEVICE | MFR | TYPE | MODEL NO | REFERENCE DWGS           |
|--------|-----|------|----------|--------------------------|
|        |     |      |          | NUMBER DESCRIPTION REV   |
|        |     |      |          | IX4081-3 P & I DIAGRAM   |
|        |     |      |          | N/A ONE LINE DIAGRAM     |
|        |     |      |          | IX30N120-3 LOGIC DIAGRAM |
|        |     |      |          | BECHTEL V.P.             |

| REVISIONS | DATE | DR. | CHK. | SUPV. | EGS | CHK. | P.E. | G.A.E. | NO. |
|-----------|------|-----|------|-------|-----|------|------|--------|-----|
| 1         |      |     |      |       |     |      |      |        |     |
| 2         |      |     |      |       |     |      |      |        |     |
| 3         |      |     |      |       |     |      |      |        |     |
| 4         |      |     |      |       |     |      |      |        |     |
| 5         |      |     |      |       |     |      |      |        |     |
| 6         |      |     |      |       |     |      |      |        |     |

NOTES:  
 1. FOR SPECIAL NOTES AND SYMBOLS REFER TO D/L 1X30-AA-ADD, C.D. F. THRU N.  
 2. O DEVOTES EQUIPMENT LOCATION NUMBER. FOR COMPLETE EQUIPMENT LOCATION NUMBER REFER TO CABLING BLOCK DIAGRAM.

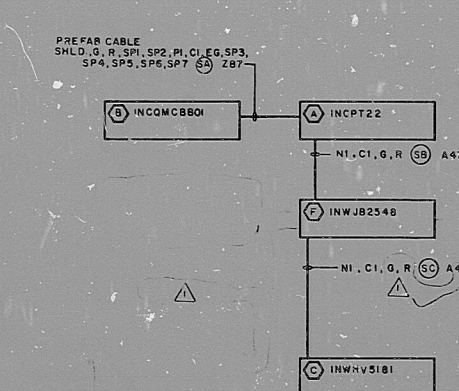

PRC  
 APERTURE  
 CARD

AUX FLOW DRAIN TO CONDENSER VALVE

**BECHTEL**  
 LOS ANGELES

**GEORGIA POWER COMPANY**  
**ALVIN W. VOGTLE NUCLEAR PLANT**

ELEMENTARY DIAGRAM  
 AUXILIARY FEEDWATER SYS  
 INV-5181

SCALE: NONE  
 DRAWING NO. 1X30-9C-F02J  
 REV. 1

RIDS

8310030027

